

UHN TRAYLINE ASSEMBLY
SYSTEM REPLACEMENT

2023-04-11
ISSUED FOR CONSTRUCTION

1475 EDMONTON STREET, PRINCE GEORGE, BC, V2M 1S2


CONTEXT PLAN

N.T.S.



LOCATION PLAN

N.T.S.

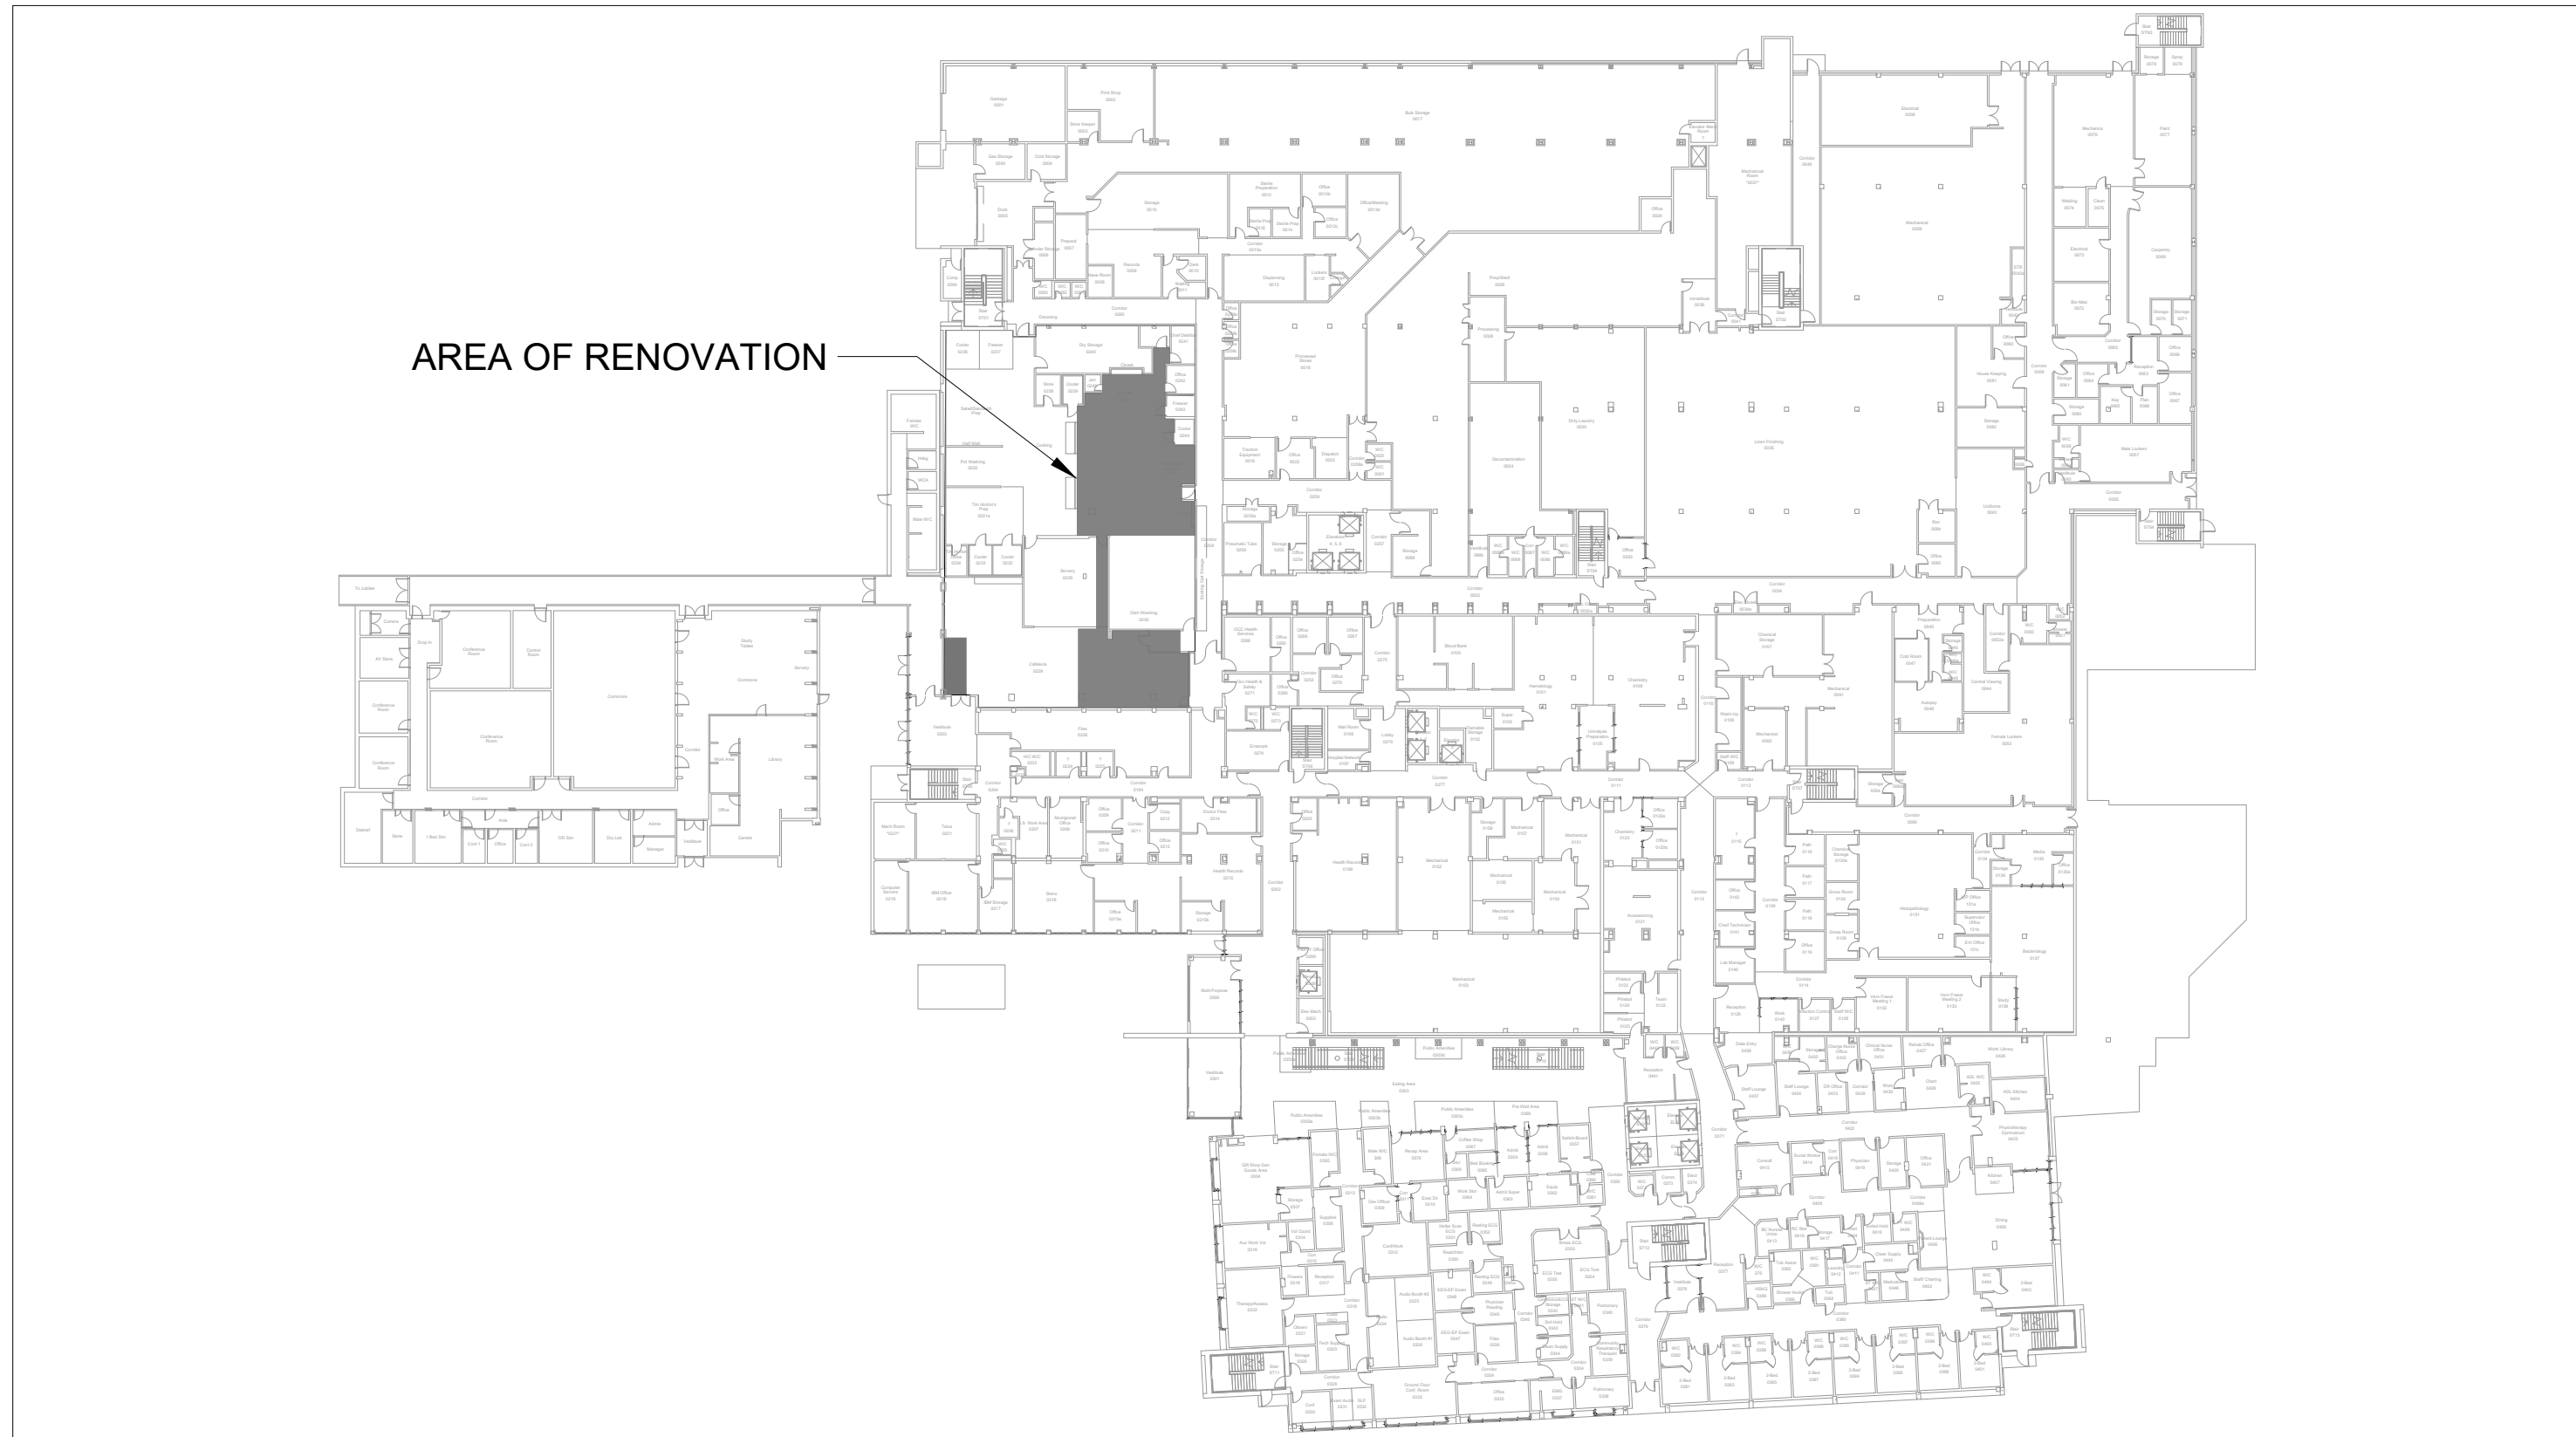

CONSULTANT AND DRAWING LIST

ARCHITECTURAL		STRUCTURAL	
THINKSPACE ARCHITECTURE PLANNING INTERIOR DESIGN SUITE 300 - 10190 152A STREET, SURREY, BC V3R 1J7 PH: (604) 581-8128 E: admin@thinkspace.ca		CWMM CONSULTING ENGINEERS LTD. 1412 W 7th AVE #200, VANCOUVER, B.C. V6H 1C1 PH: (604) 731-6584 E: engineer@cwmm.com	
A000	COVER SHEET	S1	GENERAL NOTES AND DETAILS
A001	ASSEMBLIES, SYMBOLS & ABBREVIATIONS		
A010	CODE & BYLAW REVIEW		
A011	OCCUPANT LOAD AND EXITING		
A080	PHASING		
A110	LEVEL 0 FLOOR PLAN - PHASE 1		
A111	LEVEL 0 FLOOR PLAN - PHASE 2		
A112	LEVEL 0 FLOOR PLAN - PHASE 3		
A210	LEVEL 0 REFLECTED CEILING PLAN - PHASE 1		
A211	LEVEL 0 REFLECTED CEILING PLAN - PHASE 2		
A212	LEVEL 0 REFLECTED CEILING PLAN - PHASE 3		
A750	SCHEDULES		
A751	LEVEL 0 MATERIAL PLAN		
A850	MILLWORK DETAILS		
A900	LEVEL 0 PHOTO REFERENCES		
		MECHANICAL	
		ROCKY POINT ENGINEERING LTD. 1420 ST PAUL ST #201, KELOWNA, B.C. V1Y 2E6 PH: (250) 763-3759 E: info@rpeng.ca	
		M000	SITE PLAN / SYMBOL SCHEDULE
		M111	PLUMBING PLAN - PHASE 1 - LEVEL 0
		M112	PLUMBING PLAN - PHASE 2 - LEVEL 0
		M113	PLUMBING PLAN - PHASE 3 - LEVEL 0
		M211	HVAC PLAN - PHASE 3 - LEVEL 0
		M311	SPRINKLER PLAN - PHASE 1 & 2 - LEVEL 0
		M312	SPRINKLER PLAN - PHASE 3 - LEVEL 0
		M400	MECHANICAL SCHEDULES
		M500	MECHANICAL PHOTOS
		M501	MECHANICAL PHOTOS
		M600	MECHANICAL SPECIFICATIONS
		ELECTRICAL	
		N R S ENGINEERING LTD. 556 N NECHAKO RD, PRINCE GEORGE, B.C. V2X 1A1 PH: (250) 562-0551 E: ray@nrseengineering.ca	
		E1	LEVEL 0 FLOOR PLAN - PHASE 1 ELECTRICAL
		E2	LEVEL 0 FLOOR PLAN - PHASE 2 ELECTRICAL
		E3	LEVEL 0 FLOOR PLAN - PHASE 3 ELECTRICAL
		E4	LEVEL 0 FLOOR PLAN - PHASE 4 ELECTRICAL
		E5	NEW PANEL FEED LAYOUT
		E6	ELECTRICAL DETAILS

Issued For
CONSTRUCTION

Issue Date 2023-04-11

GLOBAL REVISIONS LIST

NO.	DATE	DESCRIPTION
1	2023-02-08	ISSUED FOR BID
2	2023-03-01	ISSUED FOR ADDENDUM 01
3	2023-03-09	ISSUED FOR BLDG. PERMIT
4	2023-04-11	ISSUED FOR CONSTRUCTION

Copyright Reserved
This plan and design are the exclusive property of
Thinkspace Architecture Planning Interior Design
and shall not be reproduced or used in any way
without the written consent of Thinkspace. This office shall be
informed of any variations from the information shown
on this drawing. Do not scale drawings.
Thinkspace, a partnership of:
Todd Duff, Architect AIBC, AAA
Henk Kampman, Architect AIBC, AAA
Ray Wolfe, Architect AIBC

thinkspace60

1963-2023 YEARS

architecture planning interior design ltd.

300 - 10190 152A St. | Surrey, BC | V3R 1J7

t 604.581.8128 | f 604.581.8148 | w thinkspace.ca

Project

UHN TRAYLINE ASSEMBLY SYSTEM
REPLACEMENT

Drawing

COVER SHEET

Project Number

220937

Sheet Number

A000

NOTE1

NOTE2

Plot Date: 2023-02-08

File Path: I:\220937 pg-uhn trayline assembly system replacement\3.0 drawings\3.3 autocad\220937 - A000 cover sheet.dwg

ABBREVIATIONS

ADD	ADDENDUM	STC	SOUND TRANSMISSION CLASS
AFF	ABOVE FINISHED FLOOR	AL	ALUMINUM
ANOD	ANODIZED	STRUC	STRUCTURAL
ARCH	ARCHITECTURAL	STS	STEEL
AS	ACOUSTIC SEALANT	GLS	GLASS
AT	ACCOUSTICAL TILE	STU	STUCCO
BDM	BEDROOM	SUSP	SUSPENDED
BLDG	BUILDING	SV	STONE VENEER
BM	BENCH MARK	T/O	TOP OF
BOT	BOTTOM	T&B	TOP AND BOTTOM
BRG	BEARING	T&G	TONGUE AND GROOVE
BSMT	BASEMENT	TEL	TELEPHONE
BU	BUILT UP	TEM	TEMPERED (GLASS)
E	CENTER LINE	TEMP	TEMPORARY
E/C	CENTER TO CENTER	TERRAZZO	TERRAZZO
CG	CORNER GUARD	THK	THICK
CI	CONTROL JOINT	TF	TINT FILM
CLKG	CALLING	TR	TREAD
CMU	CONCRETE MASONRY UNIT	TRAV	TRAVERTINE
CO	CLEAN OUT	TYP	TYPICAL
CONC	CONCRETE	UH	UNIT HEATER
CONST	CONSTRUCTION	UNFIN	UNFINISHED
CPT	CARPET	UNO	UNLESS NOTED OTHERWISE
CPTT	CARPET TILE	U/S	UNDERSLIDE
CT	CERAMIC TILE	VEST	VESTIBULE
C/W	COMPLETE WITH	VOS	VERIFY ON SITE
D	DOOR	VT	VINYL TILE
DCS	DOUBLE CLEAR SAFETY GLASS	VR	VAPOR RETARDER
DEMO	DEMOLITION	W	WOOD
DET	DETAIL	W/C	WATER CLOSET
DF	DRINKING FOUNTAIN	WD	WINDOW
DIA	DIAMETER	WG	WIRED GLASS
DN	DOWN	WM	WIRE MESH
DTS	DOUBLE TINTED SAFETY GLASS	W/O	WITHOUT
DWG	DRAWING	WP	WORK POINT
ELECT	ELECTRICAL	WW	WOOD VENEER
ELEV	ELEVATOR, ELEVATION	WWF	WELED WIRE FABRIC
ENCL	ENCLOSURE		
EQ	EQUAL		
EX	EXISTING		
EXP	EXPANSION, EXPOSED		
EXT	EXTERIOR		
FA	FIRE ALARM		
FD	FLOOR DRAIN		
FDM	FOUNDATION		
FE	FIRE EXTINGUISHER		
FFE	FINISHED FLOOR		
FHC	FIRE HOSE CABINET		
FIN	FINISH		
FP	FIRE PROOF		
FRR	FIRE RESISTANCE RATING		
FRP	FIBREGLASS REINFORCED		
FURN	FURNITURE		
GA	GAUGE		
GALV	GALVANIZED		
GFA	GROSS FLOOR AREA		
GL	GLAZING		
GLB	GLASS BLOCK		
GR	GRANITE		
GWB	GYPSUM WALL BOARD		
H8	HARDBOARD		
HC	HOLLOW CORE		
HOWD	HARDWOOD		
HDW	HARDWARE		
HWIP	HIGH IMPACT WALL PANEL		
HM	HOLLOW METAL		
HMD	HOLLOW METAL DOOR		
HSS	HOLLOW STRUCTURAL STEEL		
HT	HEIGHT		
ID	INSIDE DIAMETER		
IMD	INSULATED METAL DOOR		
INSUL	INSULATION		
JST	JOIST		
JT	JOINT		
KG	KILOGRAM		
KM	KILOMETER		
KO	KNOCKOUT		
L	LENGTH, LONG		
LAM	LAMINATED GLAZING		
LAV	LAVATORY		
LH	LEFT HAND		
LIN	LINEAR		
LIND	LINE DRAIN		
LL	LIVE LOAD		
LVR	LOUVRE		
LWC	LIGHT WEIGHT CONCRETE		
M	METER		
MARB	MARBLE		
MATL	MATERIAL		
MAX	MAXIMUM		
MECH	MECHANICAL		
MEMB	MEMBRANE		
MEZ	MEZZANINE		
MIN	MINIMUM		
MISC	MISCELLANEOUS		
MM	MILLIMETER		
MTL	METAL		
N	NORTH		
NF	NEAR FACE		
NIC	NOT IN CONTRACT		
NO	NUMBER		
NOM	NOMINAL		
NTS	NOT TO SCALE		
OA	OVERALL		
OC	ON CENTER		
OD	OUTSIDE DIAMETER		
OH	OVERHEAD		
OHD	OVERHEAD DOOR		
O/O	OUT TO OUT		
OPNG	OPENING		
P	PAINT		
PLAM	PLASTIC LAMINATE		
PC	PRECAST CONCRETE		
PERP	PERPENDICULAR		
PL	PROPERTY LINE		
PLY	PLYWOOD		
PCN	PROPOSED CHANGE NOTICE		
PSF	PRESSED STEEL FRAME		
PTN	PARTITION		
PVC	POLY VINYL CHLORIDE		
QT	QUARRY TILE		
QTY	QUANTITY		
R	RISER, RADIUS		
R&S	ROD AND SHELF		
RB	RUBBER, RUBBER BASE		
RBC	RUBBER BASE COVERED		
RBS	RUBBER BASE STRAIGHT		
RD	ROOF DRAIN		
REQD	REQUIRED		
REV	REVISION		
RH	RIGHT HAND		
RO	ROUGH OPENING		
ROW	RIGHT OF WAY		
RT	RESILIENT TILE		
RS	RESILIENT SHEET		
SABF	SOUND ATTENUATION FIBERGLAS BATTS		
SC	SOLID CORE WOOD DOOR		
SCS	SINGLE CLEAR SAFETY GLASS		
SIM	SIMILAR		
SPEC	SPECIFICATION		
SS	STAINLESS STEEL		
ST	STAIN		

SYMBOLS LEGEND

MARKERS AND TAGS

GRIDS - PROPOSED

1

GRIDS - EXISTING

1

BUILDING SECTION

A

A1.01

SIM.

WALL SECTION

A

A1.01

SIM.

DETAIL CALLOUT

1

A1.00

NOTES

ELEVATION REFERENCE

ELEV

LOCATION

INTERIOR ELEVATIONS

1

A1.00

TYP.

1

A1.00

TYP.

ROOM TAG

###

NAME

AREA

SQM

NOTES

CONSTRUCTION TYPE

W1

NOTES

W1

NOTES

GLAZING/WINDOW

W1

NOTES

W1

NOTES

CASEWORK/MILLWORK

A1

NOTES

A1

NOTES

CEILING ELEVATION

3000

NOTES

3000

NOTES

REVISION

1

NOTES

KEYNOTE

1

NOTES

MATERIAL (NEW + EXISTING)

GB-1

NOTES

PHOTOGRAPH VIEW

P1

NOTES

GRADE

ELEVATION

LOCATION

ELEVATION

LOCATION

FLOOR FINISH

FE1

FE2

FE1

FE2

SLOPE

UP

2% SLOPE MIN.

BUILDING PHASES

DEMOLITION	---	---	---	---	---
EXISTING	=====				
LOW HEIGHT	=====				
TYPICAL	=====				
CONCRETE	=====				

FIRE SEPARATION RATING

DOOR MOCKUPS

TEST ###

PROPOSED

TEST ###

EXISTING

TEST ###

DEMOLITION

CONSTRUCTION TYPES

F - FLOOR ASSEMBLIES

F1	CONCRETE SLAB ON GRADE
	- FLOOR FINISH
	- CONCRETE SLAB ON GRADE
	- UNDER SLAB VAPOUR IMPERMEABLE MEMBRANE
	*REFER TO ALTERNATE PRICE 1 & 2
F2	CONCRETE SLAB ON GRADE
	- EXISTING CONCRETE SLAB ON GRADE TO REMAIN
	- UNDER SLAB VAPOUR IMPERMEABLE MEMBRANE
	*REFER TO ALTERNATE PRICE 1 & 2

P - INTERIOR WALL ASSEMBLIES

P1	STEEL STUD WALL
	FRR: N/A ULC: N/A R: N/A STC: S1
	- 16mm MOISTURE RESISTANT TYPE 'X' GWB
	- 152mm STEEL STUDS AT 400mm O.C.
	- ACOUSTIC INSULATION TO FILL STUD CAVITY
	- 16mm MOISTURE RESISTANT TYPE 'X' GWB
P2	STEEL STUD WALL
	FRR: N/A ULC: N/A R: N/A STC: S1
	- 16mm MOISTURE RESISTANT TYPE 'X' GWB
	- 2 LAYERS PLASTIC SHEET VAPOR RETARDER TO CONTINUE ABOVE CEILING LINE TO UNDERSIDE OF STRUCTURE
	- 152mm STEEL STUDS AT 400mm O.C.
	- ACOUSTIC INSULATION TO FILL STUD CAVITY
	- 16mm MOISTURE RESISTANT TYPE 'X' GWB
P3	SHAFT WALL
	FRR: N/A ULC: N/A R: N/A STC: S1
	- 16mm MOISTURE RESISTANT TYPE 'X' GWB
	- 2 LAYERS PLASTIC SHEET VAPOR RETARDER TO CONTINUE ABOVE CEILING LINE TO UNDERSIDE OF STRUCTURE
	- C-H STUDS
	- ACOUSTIC INSULATION TO FILL STUD CAVITY
	- 25mm TYPE 'X' GWB SHAFT WALL LINER
P4	STEEL STUD FURRING
	FRR: N/A ULC: N/A R: N/A STC: S1
	- AIRSPACE TO SUIT MECHANICAL & ELECTRICAL
	- 92mm STEEL STUDS @400mm O.C.
	- 16mm TYPE 'X' MOISTURE RESISTANT GWB
P5	STEEL STUD WALL
	FRR: N/A ULC: N/A R: N/A STC: S1
	- 16mm TYPE 'X' MOISTURE RESISTANT GWB
	- STEEL STUDS @ 400mm O.C. WIDTH TO MATCH EXISTING
	- ACOUSTIC INSULATION TO FILL STUD CAVITY
	- 16mm TYPE 'X' MOISTURE RESISTANT GWB
P6	REPAIR FOR FINISH
	FRR: N/A ULC: N/A R: N/A STC: S1
	- 16mm TYPE 'X' MOISTURE RESISTANT GWB
P7	STEEL STUD WALL
	FRR: N/A ULC: N/A R: N/A STC: S1
	- FULL HEIGHT WATERPROOF MEMBRANE
	- 16mm TYPE 'X' MOISTURE RESISTANT GWB
	- STEEL STUDS @ 400mm O.C. WIDTH TO MATCH EXISTING
	- ACOUSTIC INSULATION TO FILL STUD CAVITY
	- 16mm TYPE 'X' MOISTURE RESISTANT GWB
	- FULL HEIGHT WATERPROOF MEMBRANE

*GWB & STEEL STUDS TO U/S T.BAR CEILING TYPICAL.

C - INTERIOR CEILING ASSEMBLIES

C1	SUSPENDED GWB CEILING
	FRR: N/A ULC: N/A R: N/A STC: N/A
	- 16mm MOISTURE RESISTANT TYPE 'X' GWB WITH FULL PERIMETER SEAL OF ACOUSTIC SYSTEM
	- SUSPENSION SYSTEM

GENERAL NOTES

- CONTRACTOR TO INFORM THE CONSULTANT OF ANY DISCREPANCIES WITH SITE CONDITIONS OR DRAWINGS CAUSING DESIGN CHANGES TO THE PROJECT PRIOR TO PROCEEDING WITH THE WORK.
- CONTRACTOR TO MAKE THE CONSULTANTS AND THE AHA AWARE OF ANY AND ALL REQUIRED INSPECTIONS WITH ADEQUATE NOTICE TO ARRANGE REQUIRED SITE REVIEWS. PROVIDE MINIMUM OF 24/48 HOURS NOTICE.
- ALL LOOSE FURNITURE SHOWN AS GREY DASHED IS NOT INCLUDED IN CONTRACT AND IS OWNER SUPPLIED UNLESS NOTED OTHERWISE.
- SLOPE EXTERIOR SURFACES TO PREVENT WATER PONDING. SLOPE AWAY FROM EXISTING BUILDING AND TOWARD EXISTING DRAINS. TO BE MAINTAINED AFTER ALL EXTERIOR FOUNDATION WORK AND FINISHED GRADING IS COMPLETE.

DIMENSIONS

- CONFIRM ALL DIMENSIONS ON SITE. REPORT ANY DISCREPANCIES TO THE ARCHITECT.
- ALL HORIZONTAL DIMENSIONS ARE TO:
 - FACE OF EXISTING CONSTRUCTION ASSEMBLIES
 - FACE OF SHEATHING AT EXTERIOR WALLS
 - CENTRE OF STUD AT INTERIOR WALLS
 - FACE OF CONCRETE BLOCK OR CONCRETE WALLS
 - UNLESS NOTED OTHERWISE
- ALL VERTICAL DIMENSIONS ARE TO:
 - TOP OF STRUCTURE
 - UNLESS NOTED OTHERWISE
- GRID LINES ARE FOR REFERENCE ONLY.
- DO NOT SCALE DRAWINGS.

EXISTING BUILDINGS

- PATCH AND MAKE GOOD ALL EXISTING FINISHES, SUBSTRATES, AND SURFACES AFFECTED BY WORK OF THIS CONTRACT.
- PROTECT AND WORK AROUND EXISTING SERVICES, INCLUDING SPRINKLER PIPING AND HEADS, BEFORE AND DURING CARRYING OUT REQUIRED WORK
- REMOVAL OF HAZARDOUS MATERIALS, RE-INSPECTION AND TESTING BY OWNER RETAINED HAZARDOUS MATERIALS CONSULTANT MUST BE COMPLETED PRIOR TO DEMOLITION. ALL HAZARDOUS MATERIALS, ASSOCIATED FINISHES AND RELATED ITEMS TO BE REMOVED IN ACCORDANCE WITH PROCEDURES AND STANDARDS INDICATED IN THE HAZARDOUS MATERIALS REPORT.
- HOARDING TO BE PROVIDED BY CONSTRUCTION MANAGER BASED ON PHASING. REFER TO SPECIFICATIONS FOR INTERIOR AND EXTERIOR HOARDING REQUIREMENTS.
- REFER TO DRAWINGS AND KEYNOTES FOR ITEMS TO BE SALVAGED FOR REUSE. SALVAGED ITEMS NOT USED OR SCHEDULED TO BE TURNED OVER TO OWNER TO BE REMOVED FROM SITE BY CONTRACTOR.

HEALTHCARE

- PROVIDE INFECTION PREVENTION AND CONTROL HOARDING TO HEALTH AUTHORITY (IP&C STANDARDS).
- AREA OF RENOVATION SHALL BE UNDER NEGATIVE PRESSURE IN ACCORDANCE WITH HEALTH AUTHORITY INFECTION PREVENTION AND CONTROL (IP&C) REQUIREMENTS.

INTERIOR WALLS AND CEILINGS

- WALL TYPES CONTINUOUS AROUND CORNERS UNLESS NOTED OTHERWISE.
- GYPSUM BOARD TO BE TAPED AND FILLED TO FULL HEIGHT OF WALL.
- WALL TYPES ARE TO BE CONTINUOUS ABOVE AND BELOW WINDOWS AND DOORS UNLESS NOTED OTHERWISE.
- BRACE WALLS AS REQUIRED ABOVE CEILINGS.
- PROVIDE A DEFLECTION HEAD AT TOP OF STUD WALLS AT UNDERSIDE OF STRUCTURE/DECK.
- ALIGN DIFFERENT WALL TYPES TO ENSURE FINISH LINES UP UNLESS NOTED OTHERWISE. WHERE REQUIRED, PLYWOOD SHEATHING FOR WALL BACKING IS TO RUN FROM CORNER TO CORNER AND FLOOR TO U/S OF DECK FOR UNIFORM ARCHITECTURAL FINISHED SURFACE.
- PROVIDE MISCELLANEOUS STUD, FURRING AND BLOCKING AS REQUIRED.
- SEE DOOR SCHEDULE FOR TYPICAL WALL RETURNS AT DOORS UNLESS DIMENSIONED.
- PROVIDE MISCELLANEOUS BLOCKING FOR OWNER EQUIPMENT AND/OR FURNISHINGS.
- REFER TO BUILDING SECTIONS, WALL SECTIONS, AND DETAILS FOR ADDITIONAL WALL INFORMATION.
- GYPSUM BOARD ON RATED WALLS TO BE CONTINUOUS AT INTERSECTING PARTITION FOR CONTINUITY OF FIRE SEPARATION.
- USE CEMENT BOARD IN LIEU OF GYPSUM BOARD WHERE PORCELAIN/CERAMIC WALL TILE IS SCHEDULED OR SHOWN ON ELEVATIONS.
- ALL WALLS AND PARTITIONS AND BULKHEADS (EXISTING AND NEW) SHALL EXTEND TO THE UNDERSIDE OF STRUCTURE UNLESS NOTED OTHERWISE.
- CONTRACTOR TO ENSURE ALL CAVITIES AND OBJECTS ARE FREE OF CONSTRUCTION DUST MATERIALS AND DEBRIS PRIOR TO CLOSING UP PARTITIONS OR INSTALLING BULKHEAD AND CEILING SYSTEMS.
- FIRE OR SOUND RATED WALL ASSEMBLIES LOCATED ABOVE SUSPENDED CEILINGS SHALL HAVE GYPSUM BOARD JOINTS FIRE TAPED.
- PROVIDE SOLID BLOCKING IN CEILINGS & WALLS WHERE REQUIRED FOR ALL MECHANICAL EQUIPMENT, ELECTRICAL EQUIPMENT, HANDRAILS, GRAB BARS & MILLWORK.

CONSTRUCTION TYPES

- REFER TO SPECIFICATION FOR STEEL STUD FRAMING REQUIREMENTS.
- REFER TO SPECIFICATION FOR BLOCKING & BACKING REQUIREMENTS.
- ALL GYPSUM BOARD TO BE TYPE 'X'.
- UNLESS NOTED OTHERWISE ALL WALLS TO EXTEND TO U/S OF STRUCTURE.
- PARTITIONS WITH GYPSUM BOARD CEILINGS ON BOTH SIDES TO TERMINATE 100mm ABOVE GYPSUM BOARD CEILING.
- PLYWOOD SHEATHING FOR WALL BACKING IS TO RUN FROM CORNER TO CORNER AND FLOOR TO U/S OF DECK FOR UNIFORM ARCHITECTURAL FINISHED SURFACE.
- AT OPENINGS THROUGH WALLS WITH FIRE RESISTANCE RATINGS, PROVIDE SOLID BLOCKING OR RETURN GYPSUM BOARD.

Issue Date: 2023-04-11

Copyright Reserved

This plan and design are the exclusive property of Thinkspace Architecture Planning Interior Design Inc. (Thinkspace). No part of this drawing shall be reproduced, stored in a retrieval system, or transmitted in any form or by any means, electronic, mechanical, photocopying, recording, or by any information storage and retrieval system, without the prior written consent of Thinkspace. This office shall be informed of any variations from the information shown on this drawing. Do not scale drawings.

Thinkspace a partnership of:
Todd Dust, Architect AIBC, AAA
Henk Kampman, Architect AIBC, AAA
Ray Wolfe, Architect AIBC

GLOBAL REVISIONS LIST*

NO.	DATE	DESCRIPTION
1	2023-02-08	ISSUED FOR BID
2	2023-02-08	ISSUED FOR ADDENDUM 01
3	2023-03-01	ISSUED FOR BUG, PERMIT
4	2023-04-11	ISSUED FOR CONSTRUCTION

*Sheet changes clouded and tagged respectively.

thinkspace60

1963-2023 YEARS

architecture planning interior design ltd.

300 - 10190 152A St. | Surrey, BC | V3R 1J7

t 604.581.8128 | f 604.581.8148 | w thinkspace.ca

Project

UHN TRAYLINE ASSEMBLY SYSTEM REPLACEMENT

Drawing

ASSEMBLIES, SYMBOLS & ABBREVIATIONS

Project Number

220937

Sheet Number


A001

NOTE1

NOTE2

File Path: I:\220937_ag-uhh-trayline-assembly-system-replacement\3.0.drawing\3.3 autocad\220937 - A001 abbreviations and symbols.dwg

Plot Date: 2023-02-08

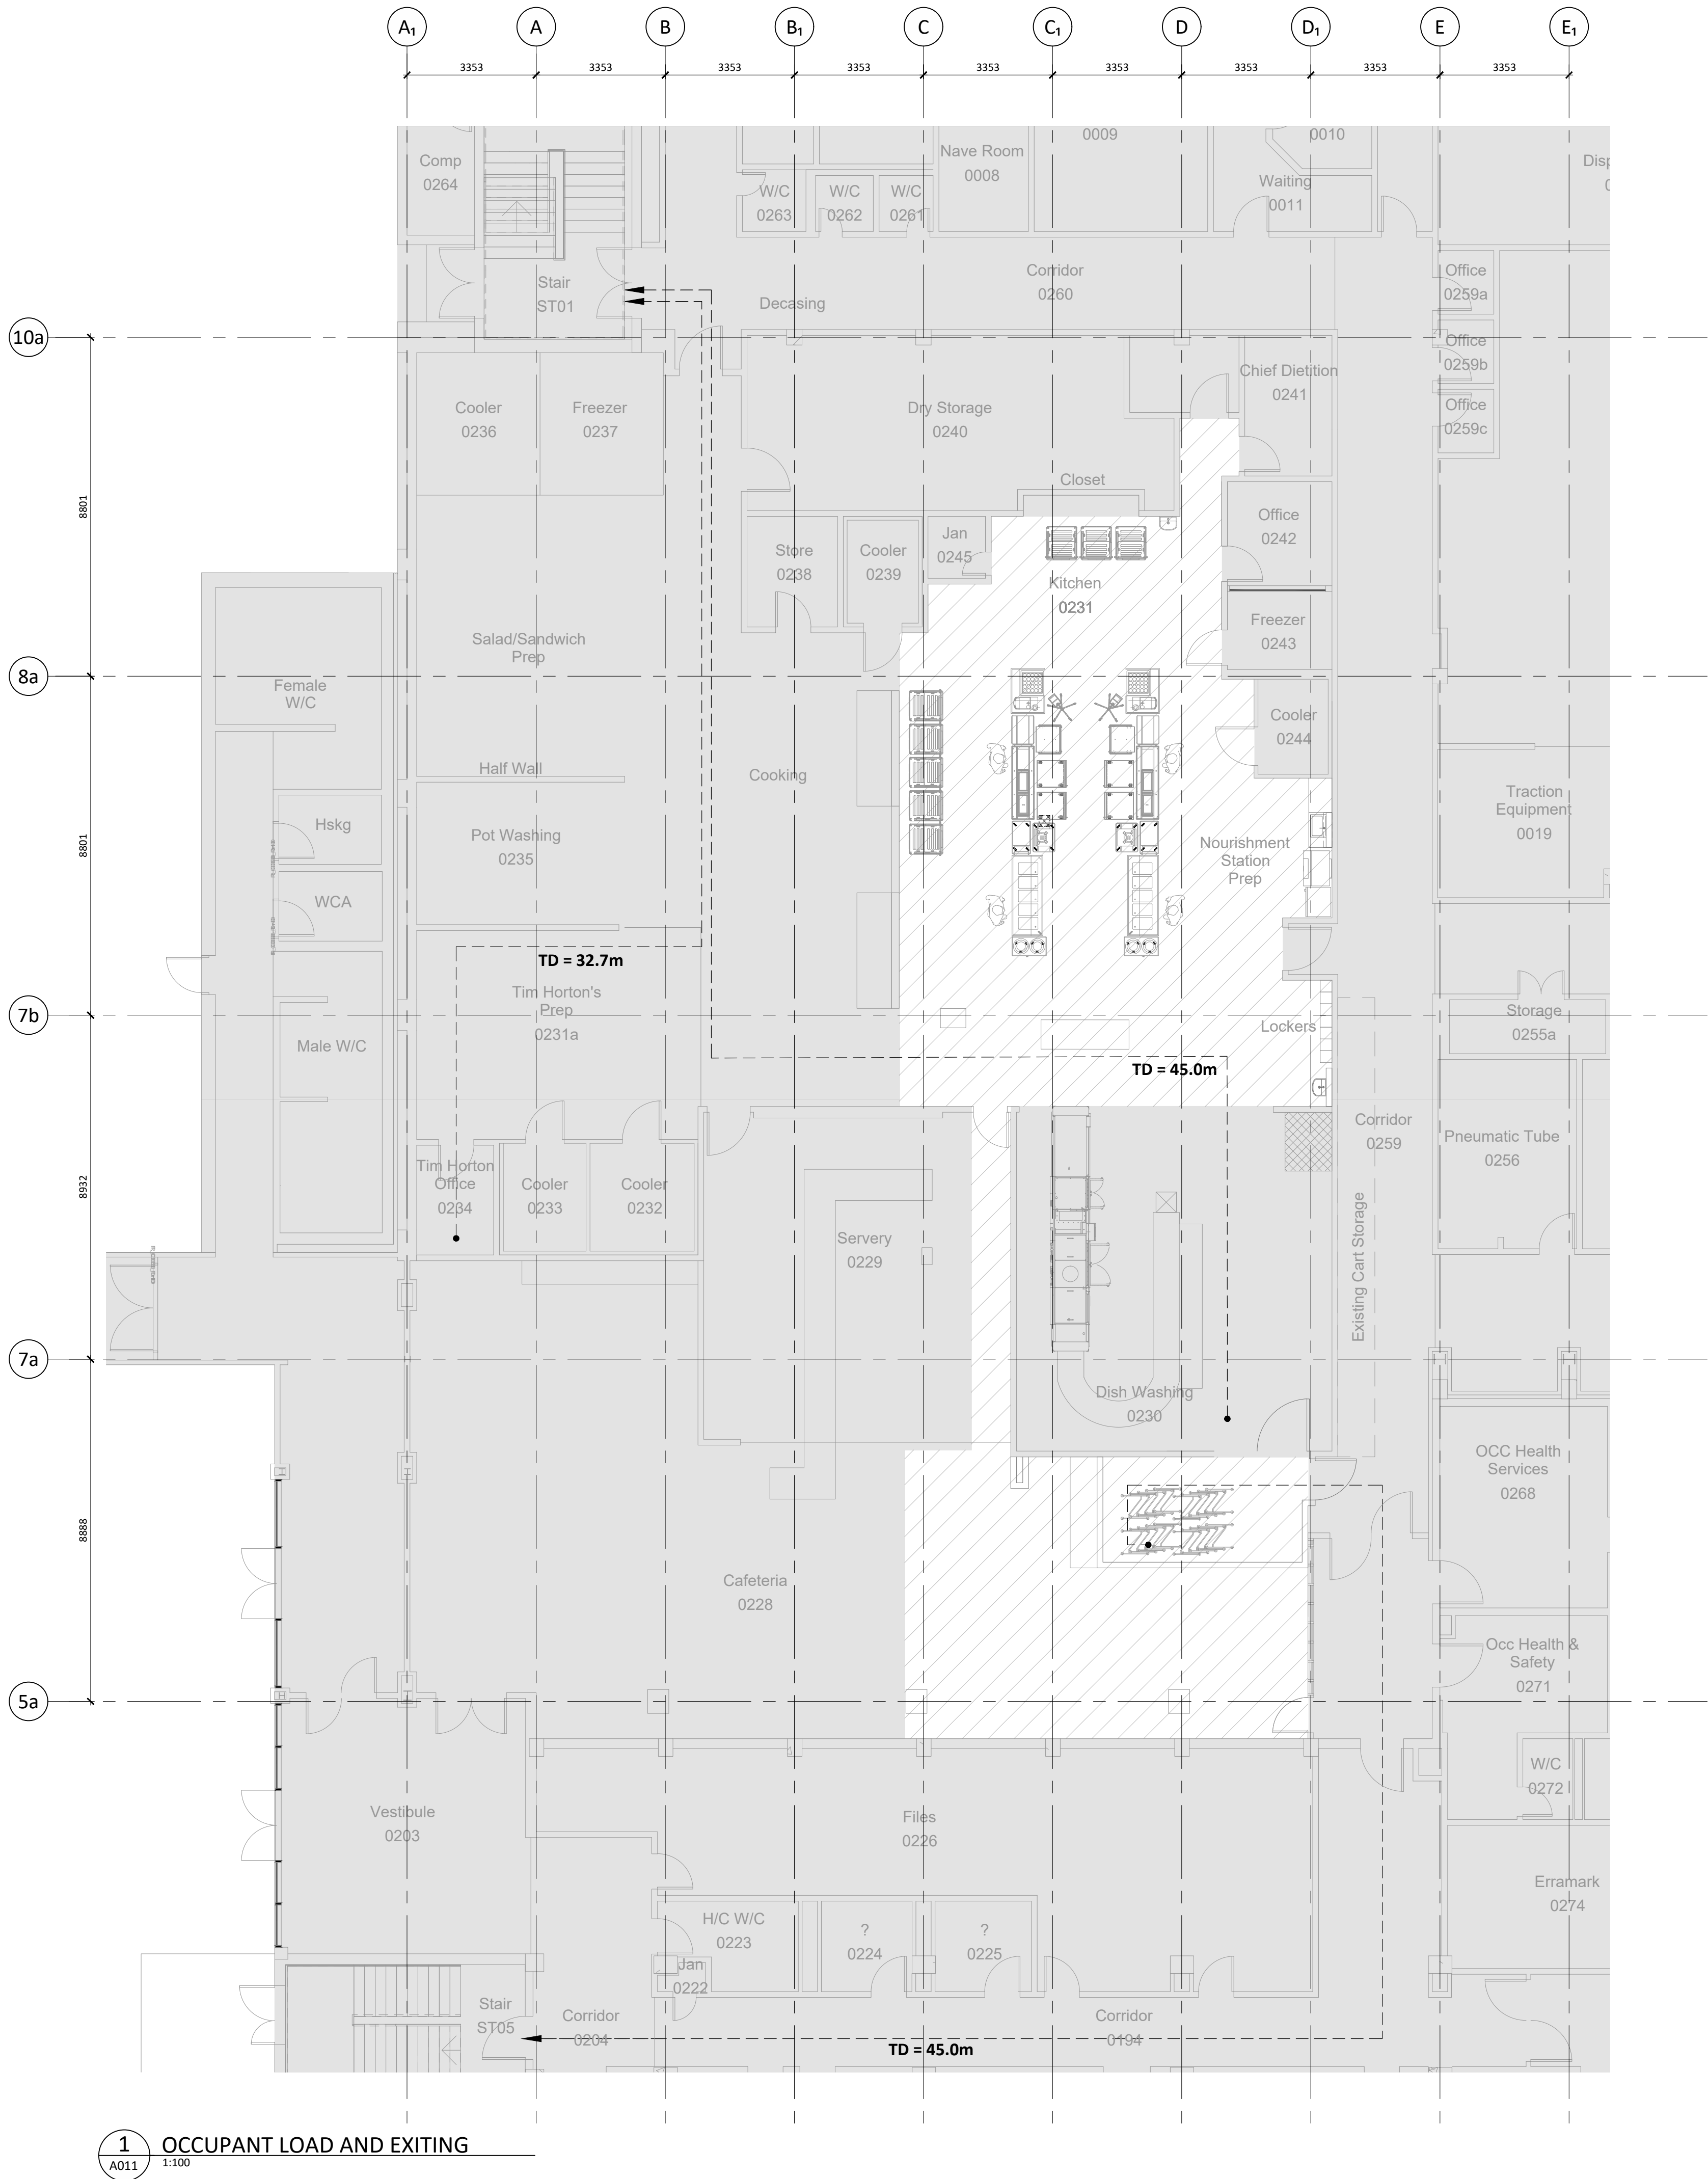


1 OCCUPANT LOAD AND EXITING
A011 1:100

FLOOR PLAN LEGEND

- TRAVEL DISTANCE (TD) TO ROOM EGRESS
- AREA OF SCOPE
- AREA OUT OF SCOPE

KEY PLAN

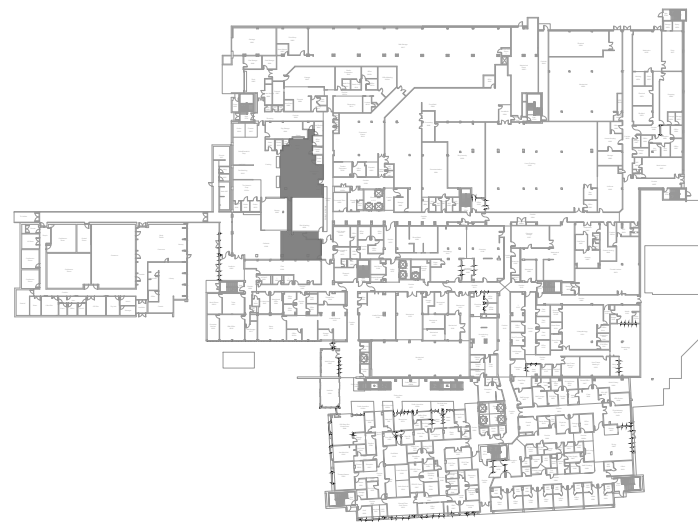

N.T.S.

Project Number
220937

Project
UHN TRAYLINE ASSEMBLY SYSTEM REPLACEMENT

Sheet Number
A011

NOTE1

NOTE2

NOTE3

1475 EDMONTON STREET, PRINCE GEORGE, BC, V2M 1S2

10190 152A St. | Surrey, BC | V3R 1J7

604.581.8128 | 604.581.8148 | w.thinkspace.ca

Occupant Load and Exiting

Occupant Load and Exiting

Occupant Load and Exiting

Issue Date: 2023-04-11

Issue For
CONSTRUCTION

GLOBAL REVISIONS LIST

NO. DATE DESCRIPTION

1. 2023-02-08 ISSUED FOR BID

2. 2023-03-01 ISSUED FOR ADDENDUM 01

3. 2023-03-09 ISSUED FOR BLDG. PERMIT


4. 2023-04-11 ISSUED FOR CONSTRUCTION

Copyright Reserved


This plan and design are the exclusive property of Thinkspace Architecture and Planning Inc. (Thinkspace). No part of this drawing may be reproduced, stored in a retrieval system, or transmitted in any form or by any means, electronic, mechanical, photocopying, recording, or by any information storage and retrieval system, without the prior written consent of Thinkspace. This office shall be informed of any variations from the information shown on this drawing. Do not scale drawings.

Thinkspace is a partnership of:
Todd Duff, Architect AIBC, AIA
Heidi Kampanian, Architect AIBC, AIA
Ray Wolfe, Architect AIBC

*Sheet changes clouded and tagged respectively.

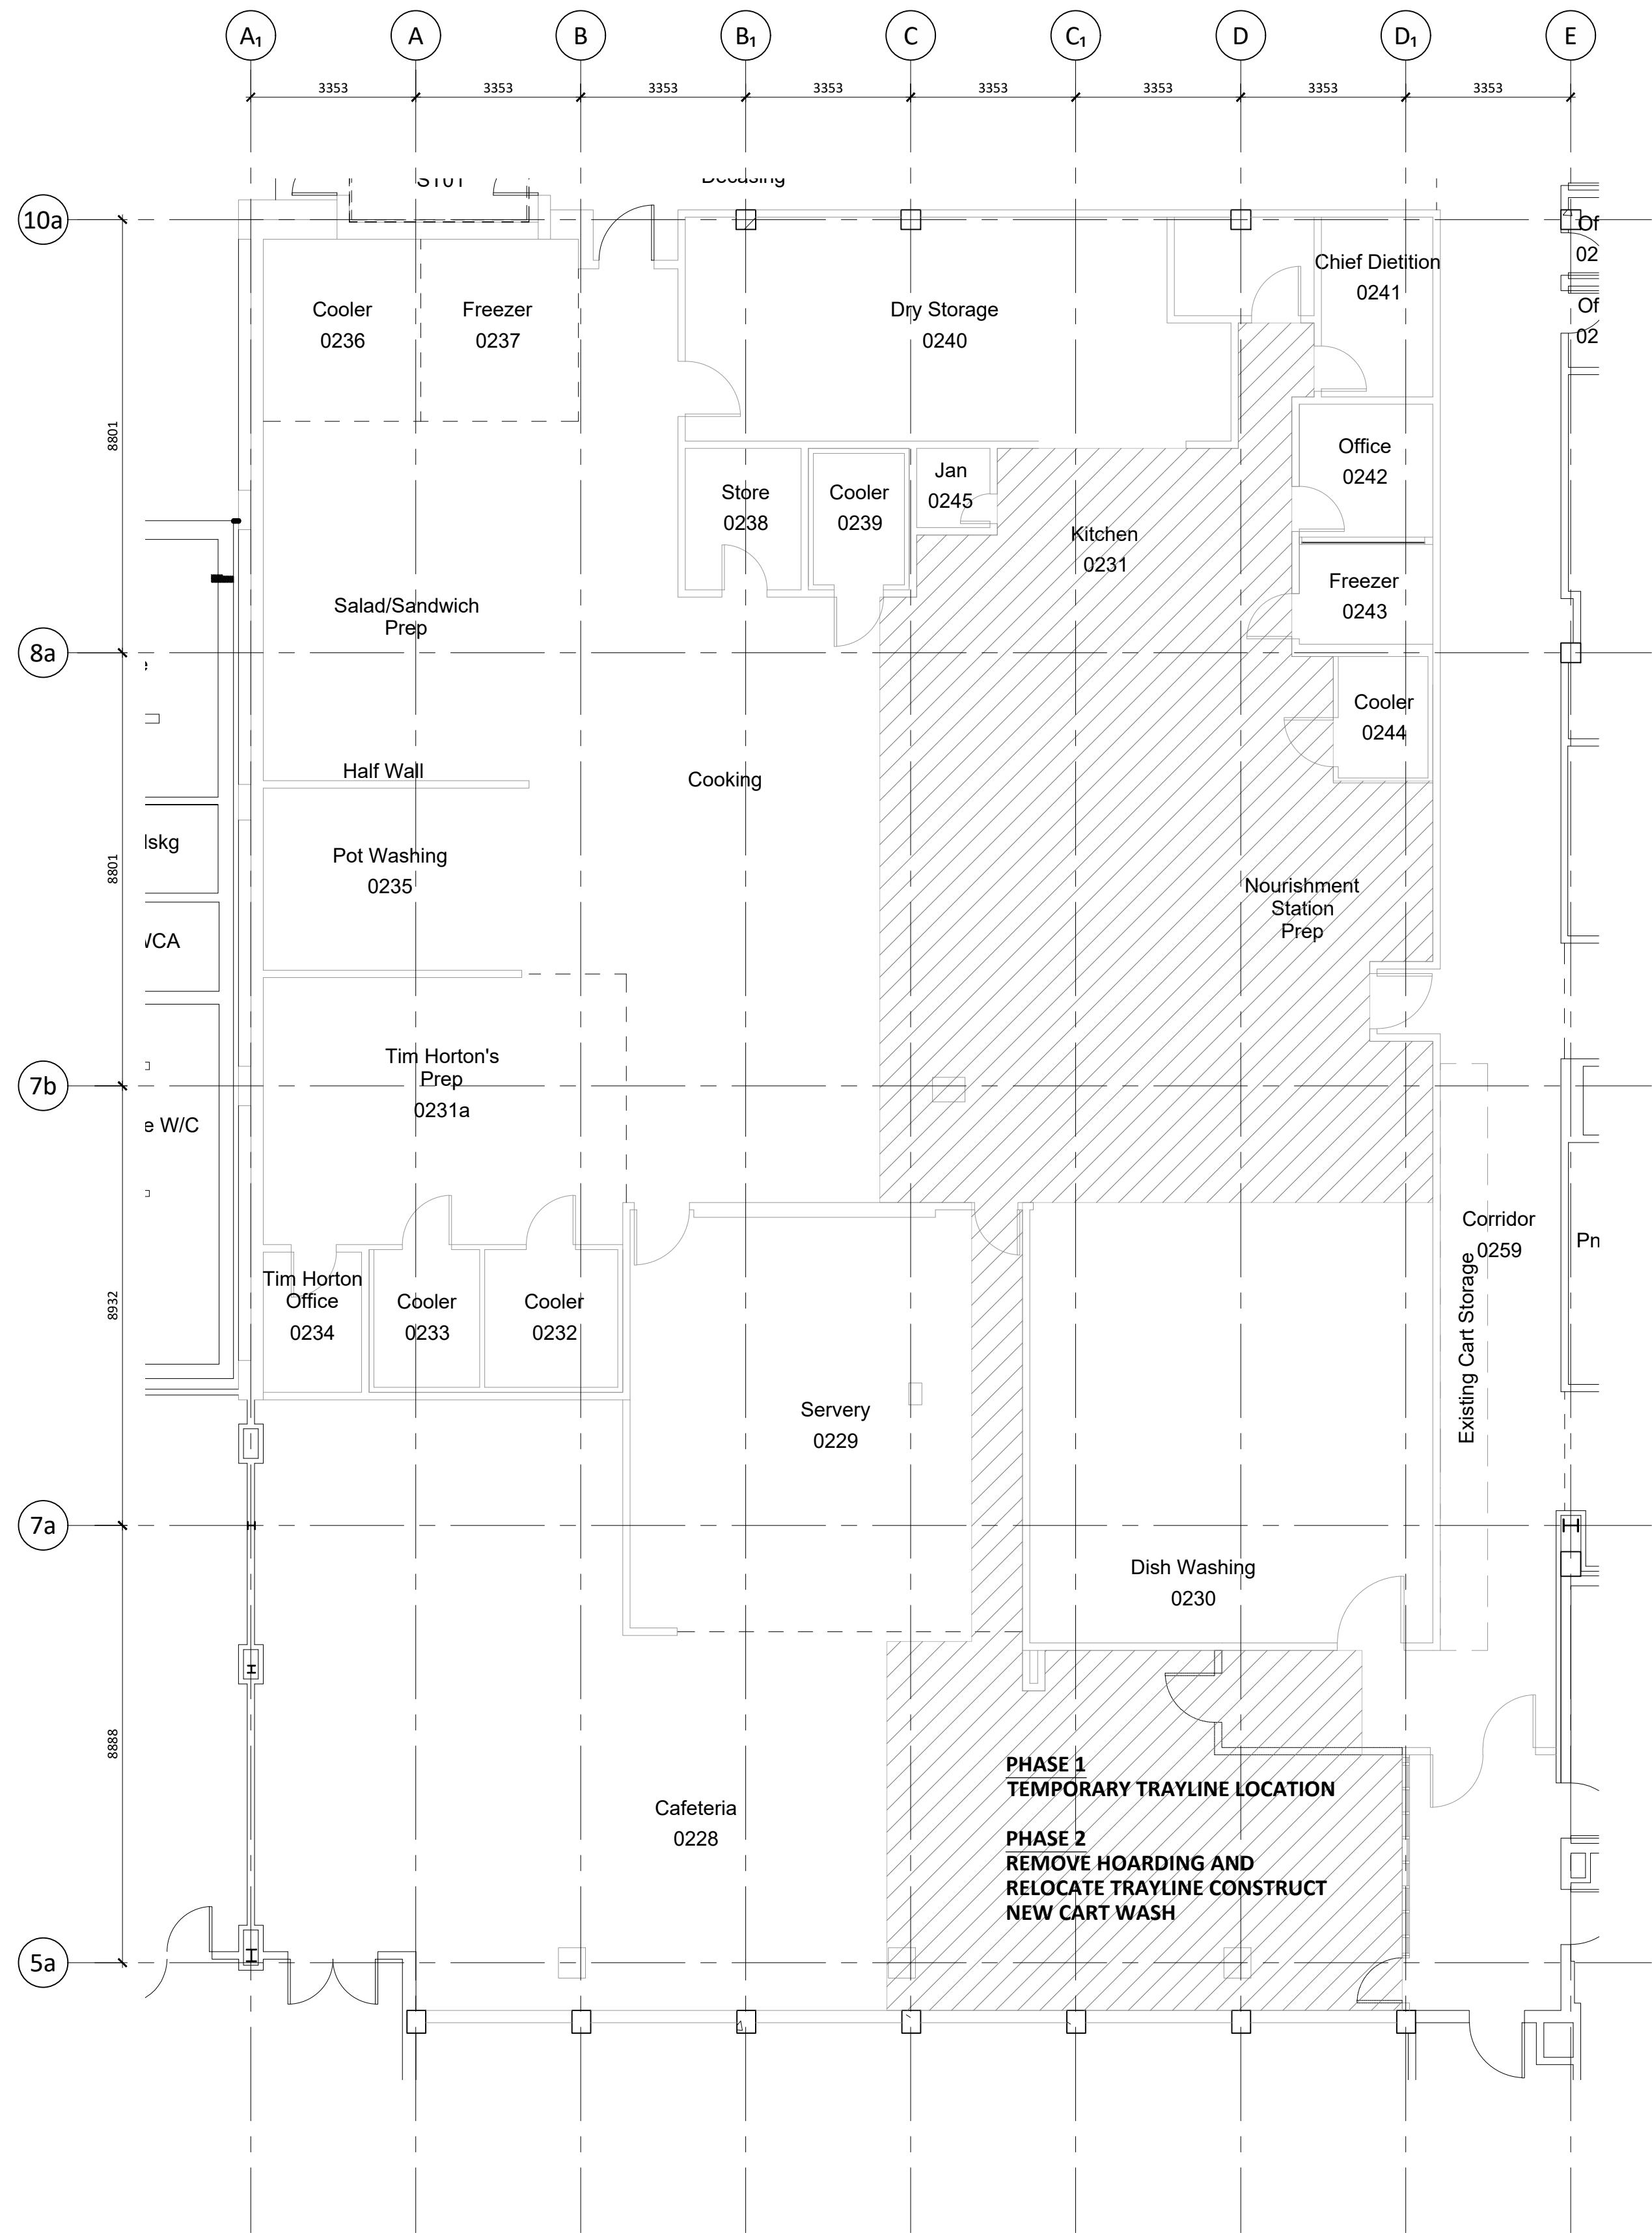

1 PHASES 1, 2 AND 3
A080 1:100

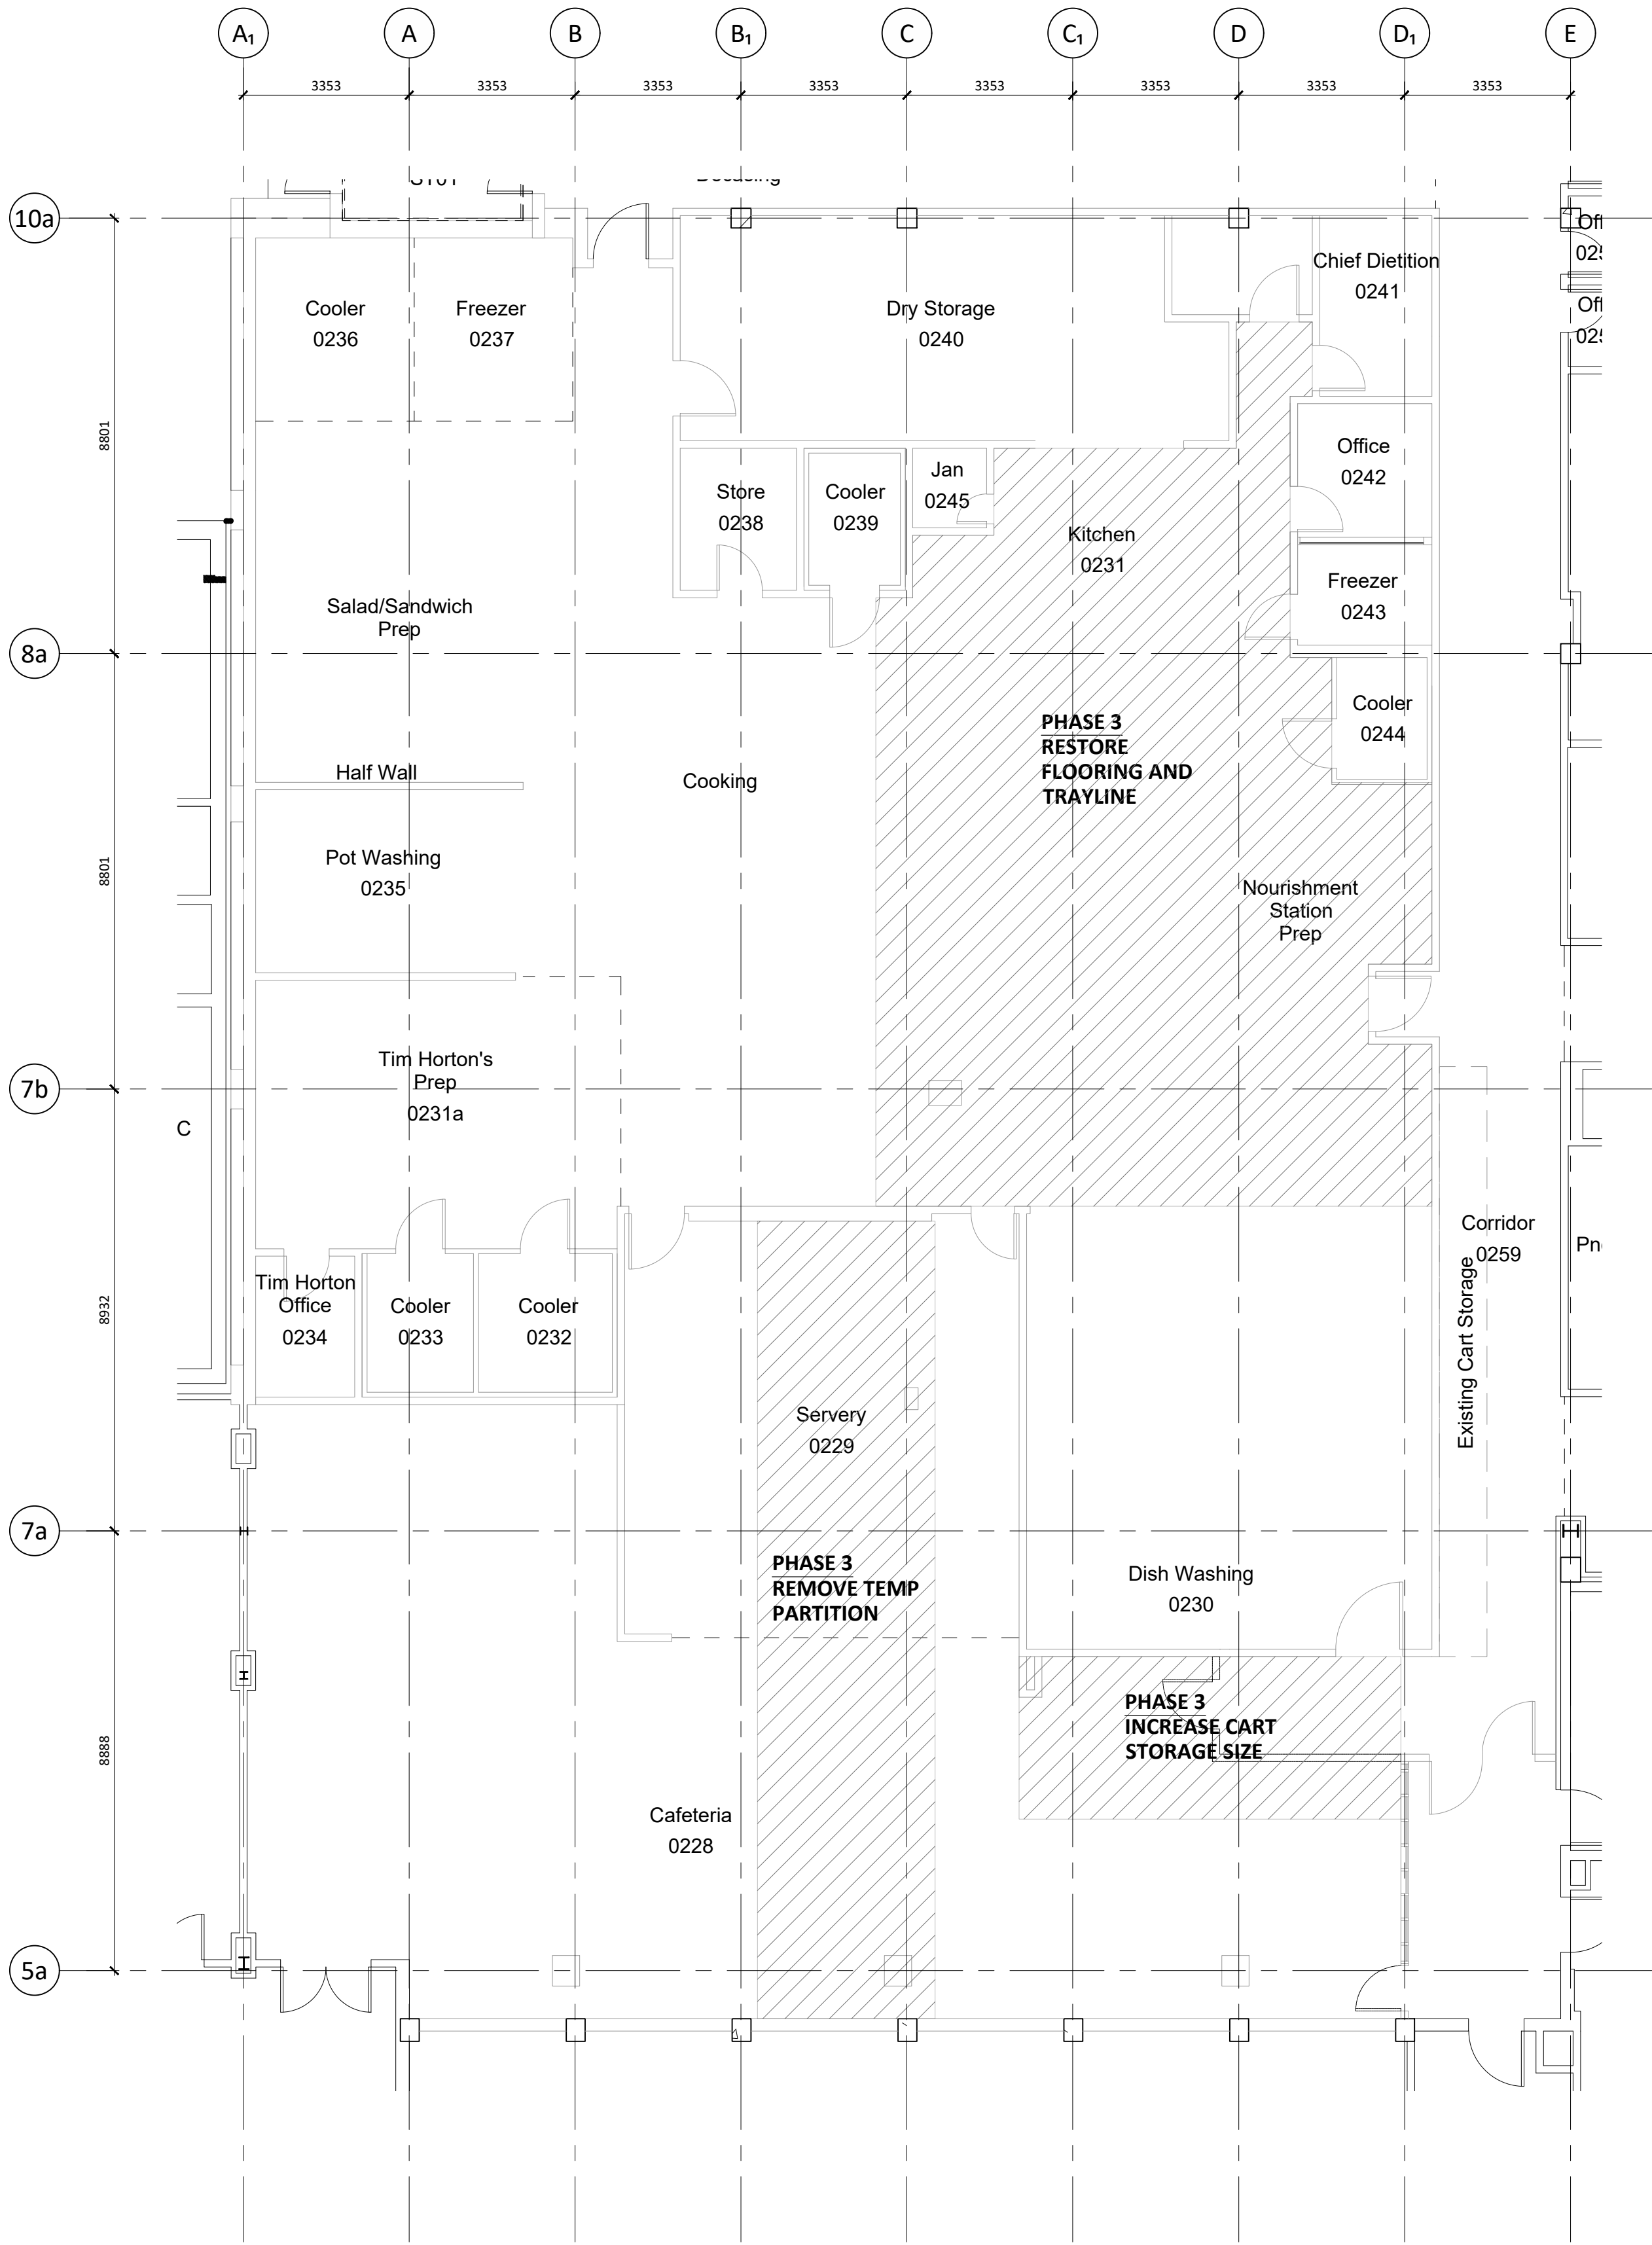


2 PHASE 4
A080 1:100

FLOOR PLAN LEGEND

AREA OF SCOPE

KEY PLAN

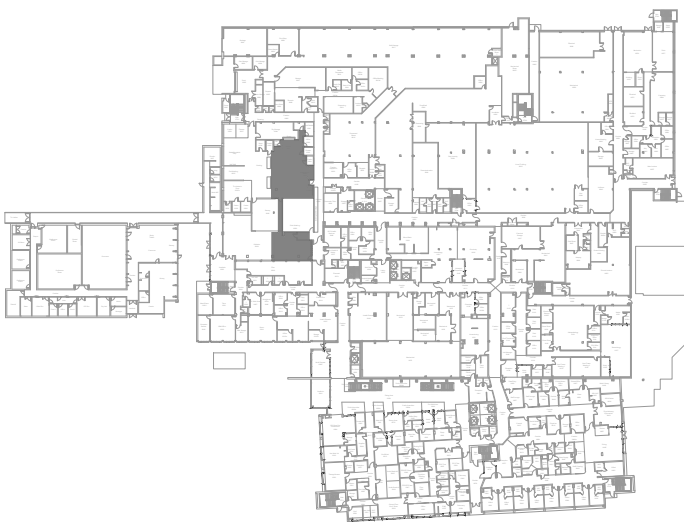

Copyright Reserved

This plan and design are the exclusive property of Thinkspace Architecture. No part of this drawing may be reproduced, stored in a retrieval system, or transmitted in any form or by any means, electronic, mechanical, photocopying, recording, or by any information storage and retrieval system, without the prior written consent of Thinkspace. This office shall be informed of any variations from the information shown on this drawing. Do not scale drawing.

Thinkspace a partnership of:
Todd Dusi, Architect ABC, AAA
Henk Kampman, Architect ABC, AAA
Ray Wolfe, Architect ABC

Issue Date: 2023-04-11

NO.	DATE	DESCRIPTION
1	2023-02-08	ISSUED FOR BID
2	2023-03-01	ISSUED FOR ADDENDUM 01
3	2023-03-09	ISSUED FOR BLDG. PERMIT
4	2023-04-11	ISSUED FOR CONSTRUCTION

*Sheet changes clouded and tagged respectively.


thinkspace 50
1963-2023 YEARS

architecture planning interior design ltd.
300 - 10190 152A St. | Surrey, BC | V3R 1J7
t 604.581.8128 | f 604.581.8148 | w thinkspace.ca


Project: UHN TRAYLINE ASSEMBLY SYSTEM REPLACEMENT
Drawing: PHASING
Sheet Number: A080

NOTE1
NOTE2

Plot Date: 2023-02-08
File Path: I:\220937 ag-uhh trayline assembly system replacement\3.0 drawings\3.3 autocad\220937 - a080 phasing.dwg

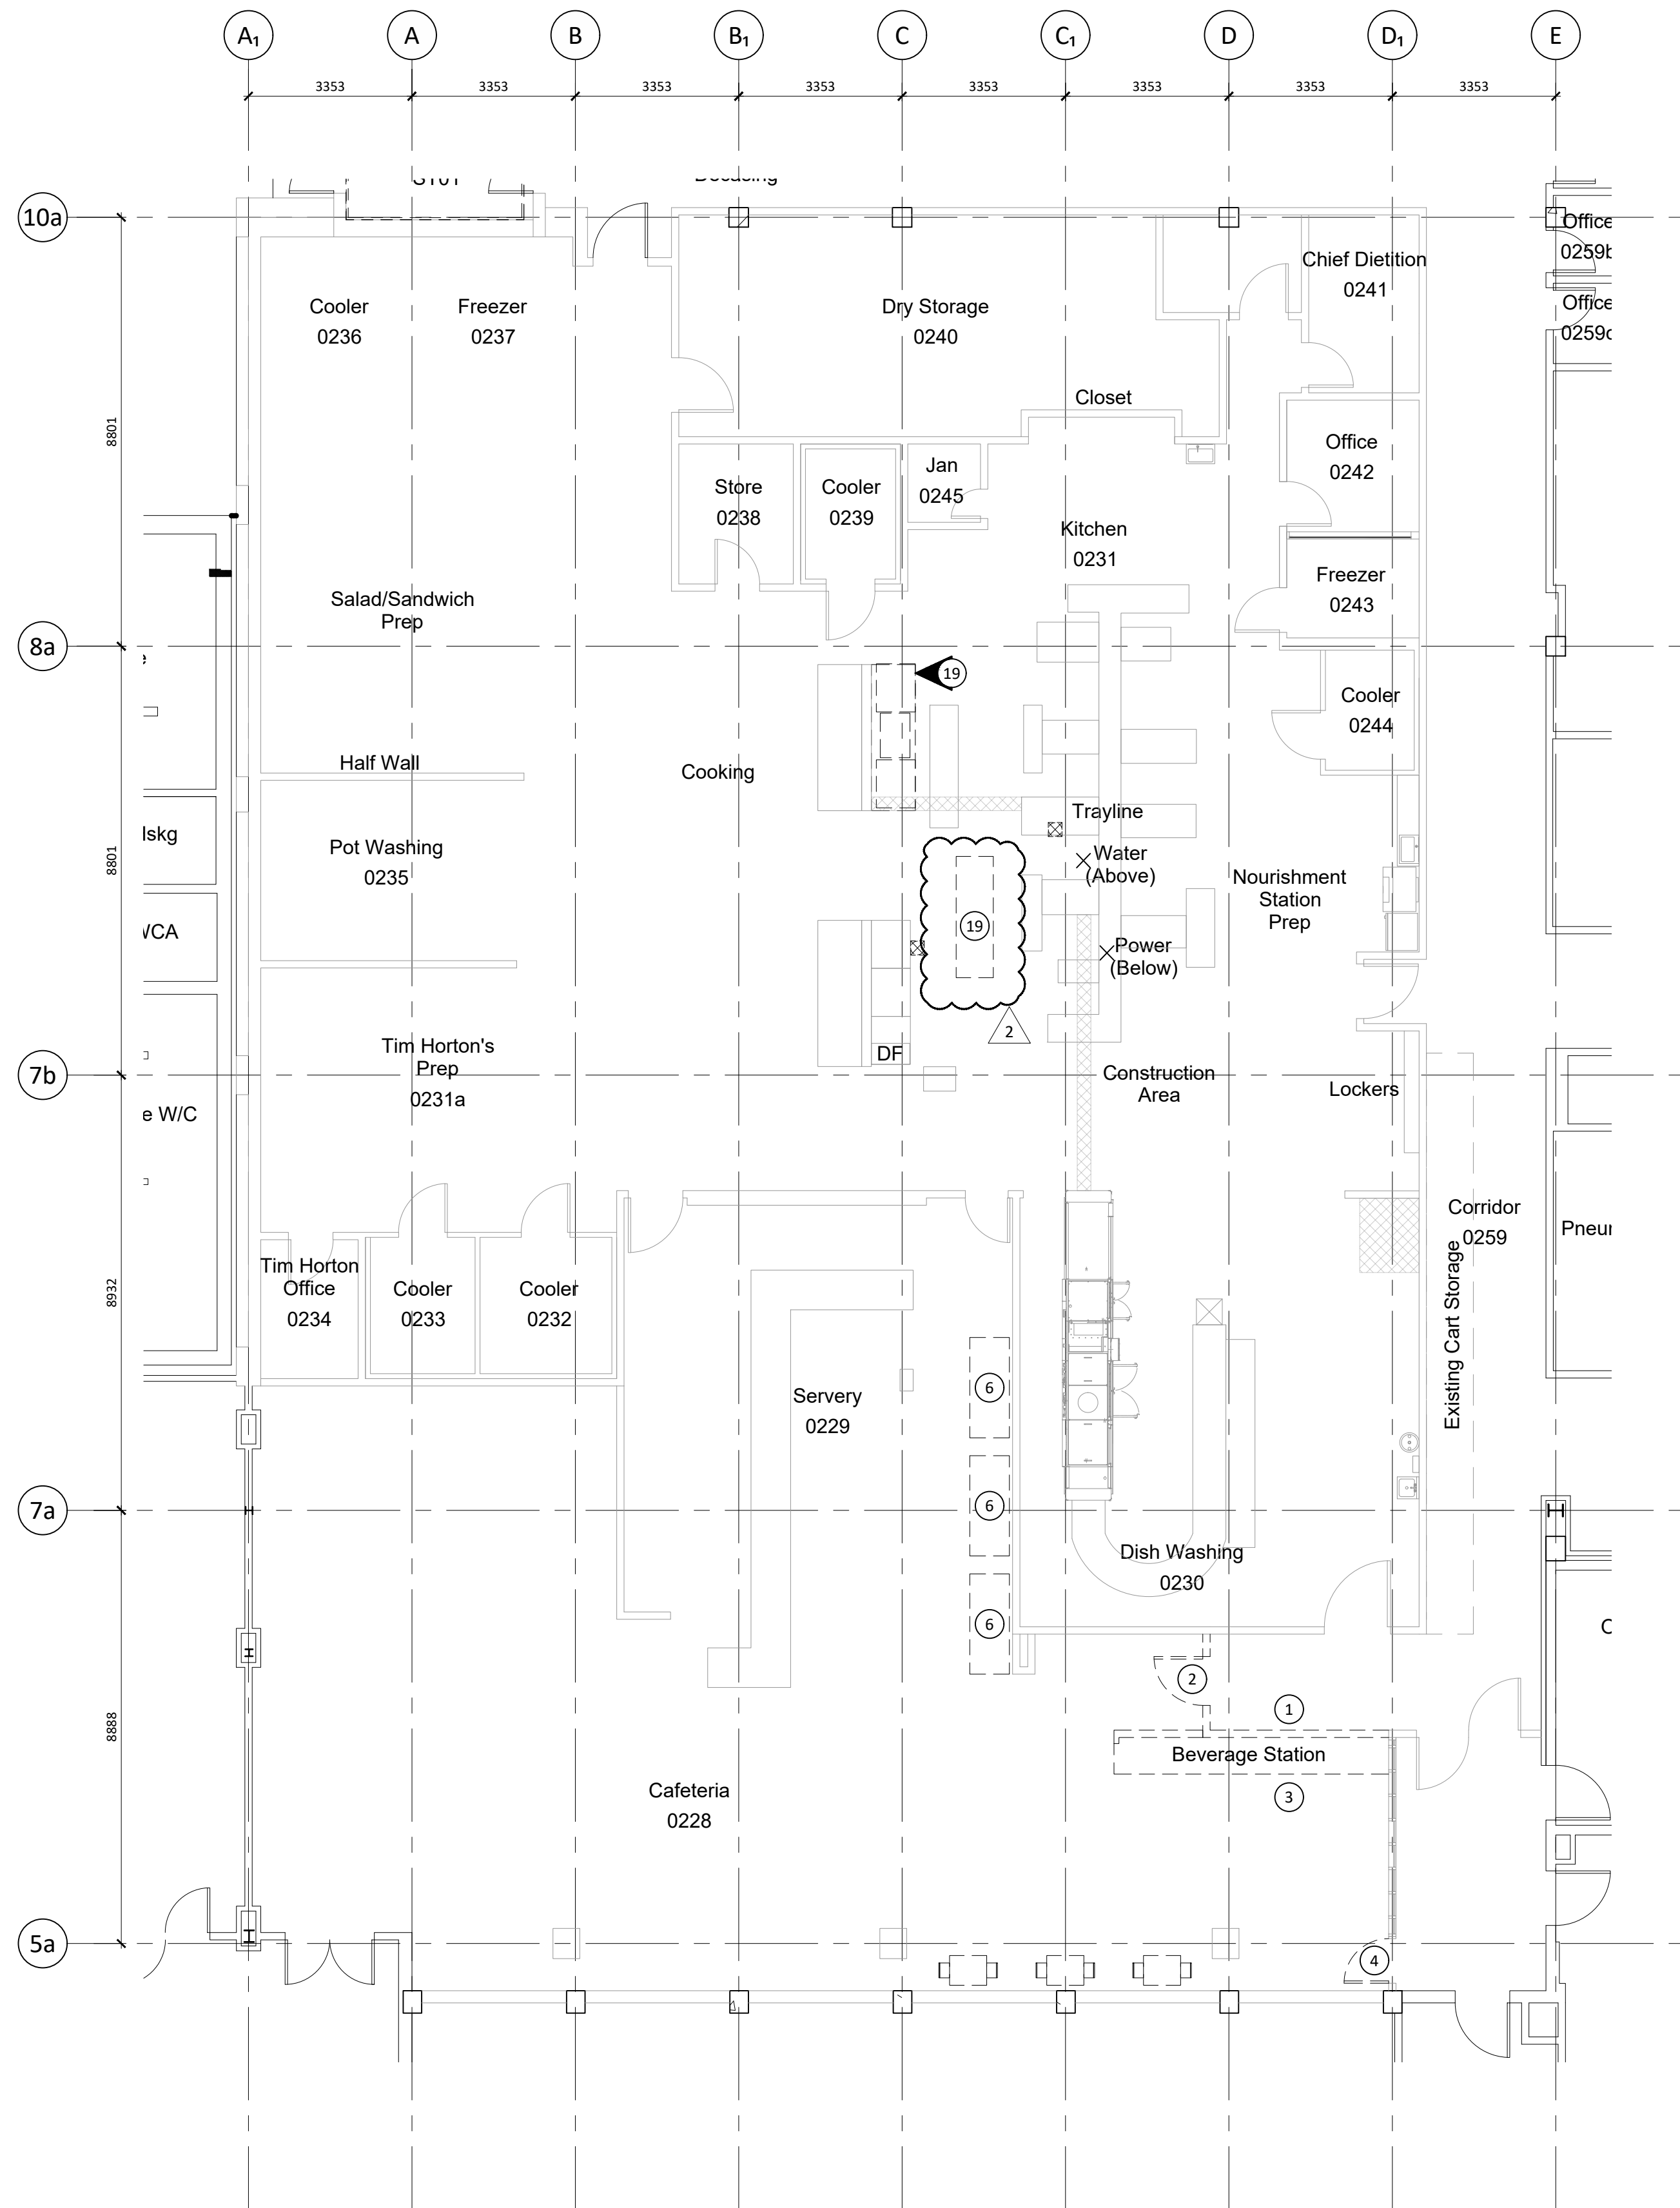

1 LEVEL 0 DEMO PLAN - PHASE 1
A110 1:100 TEMPORARY TRAYLINE

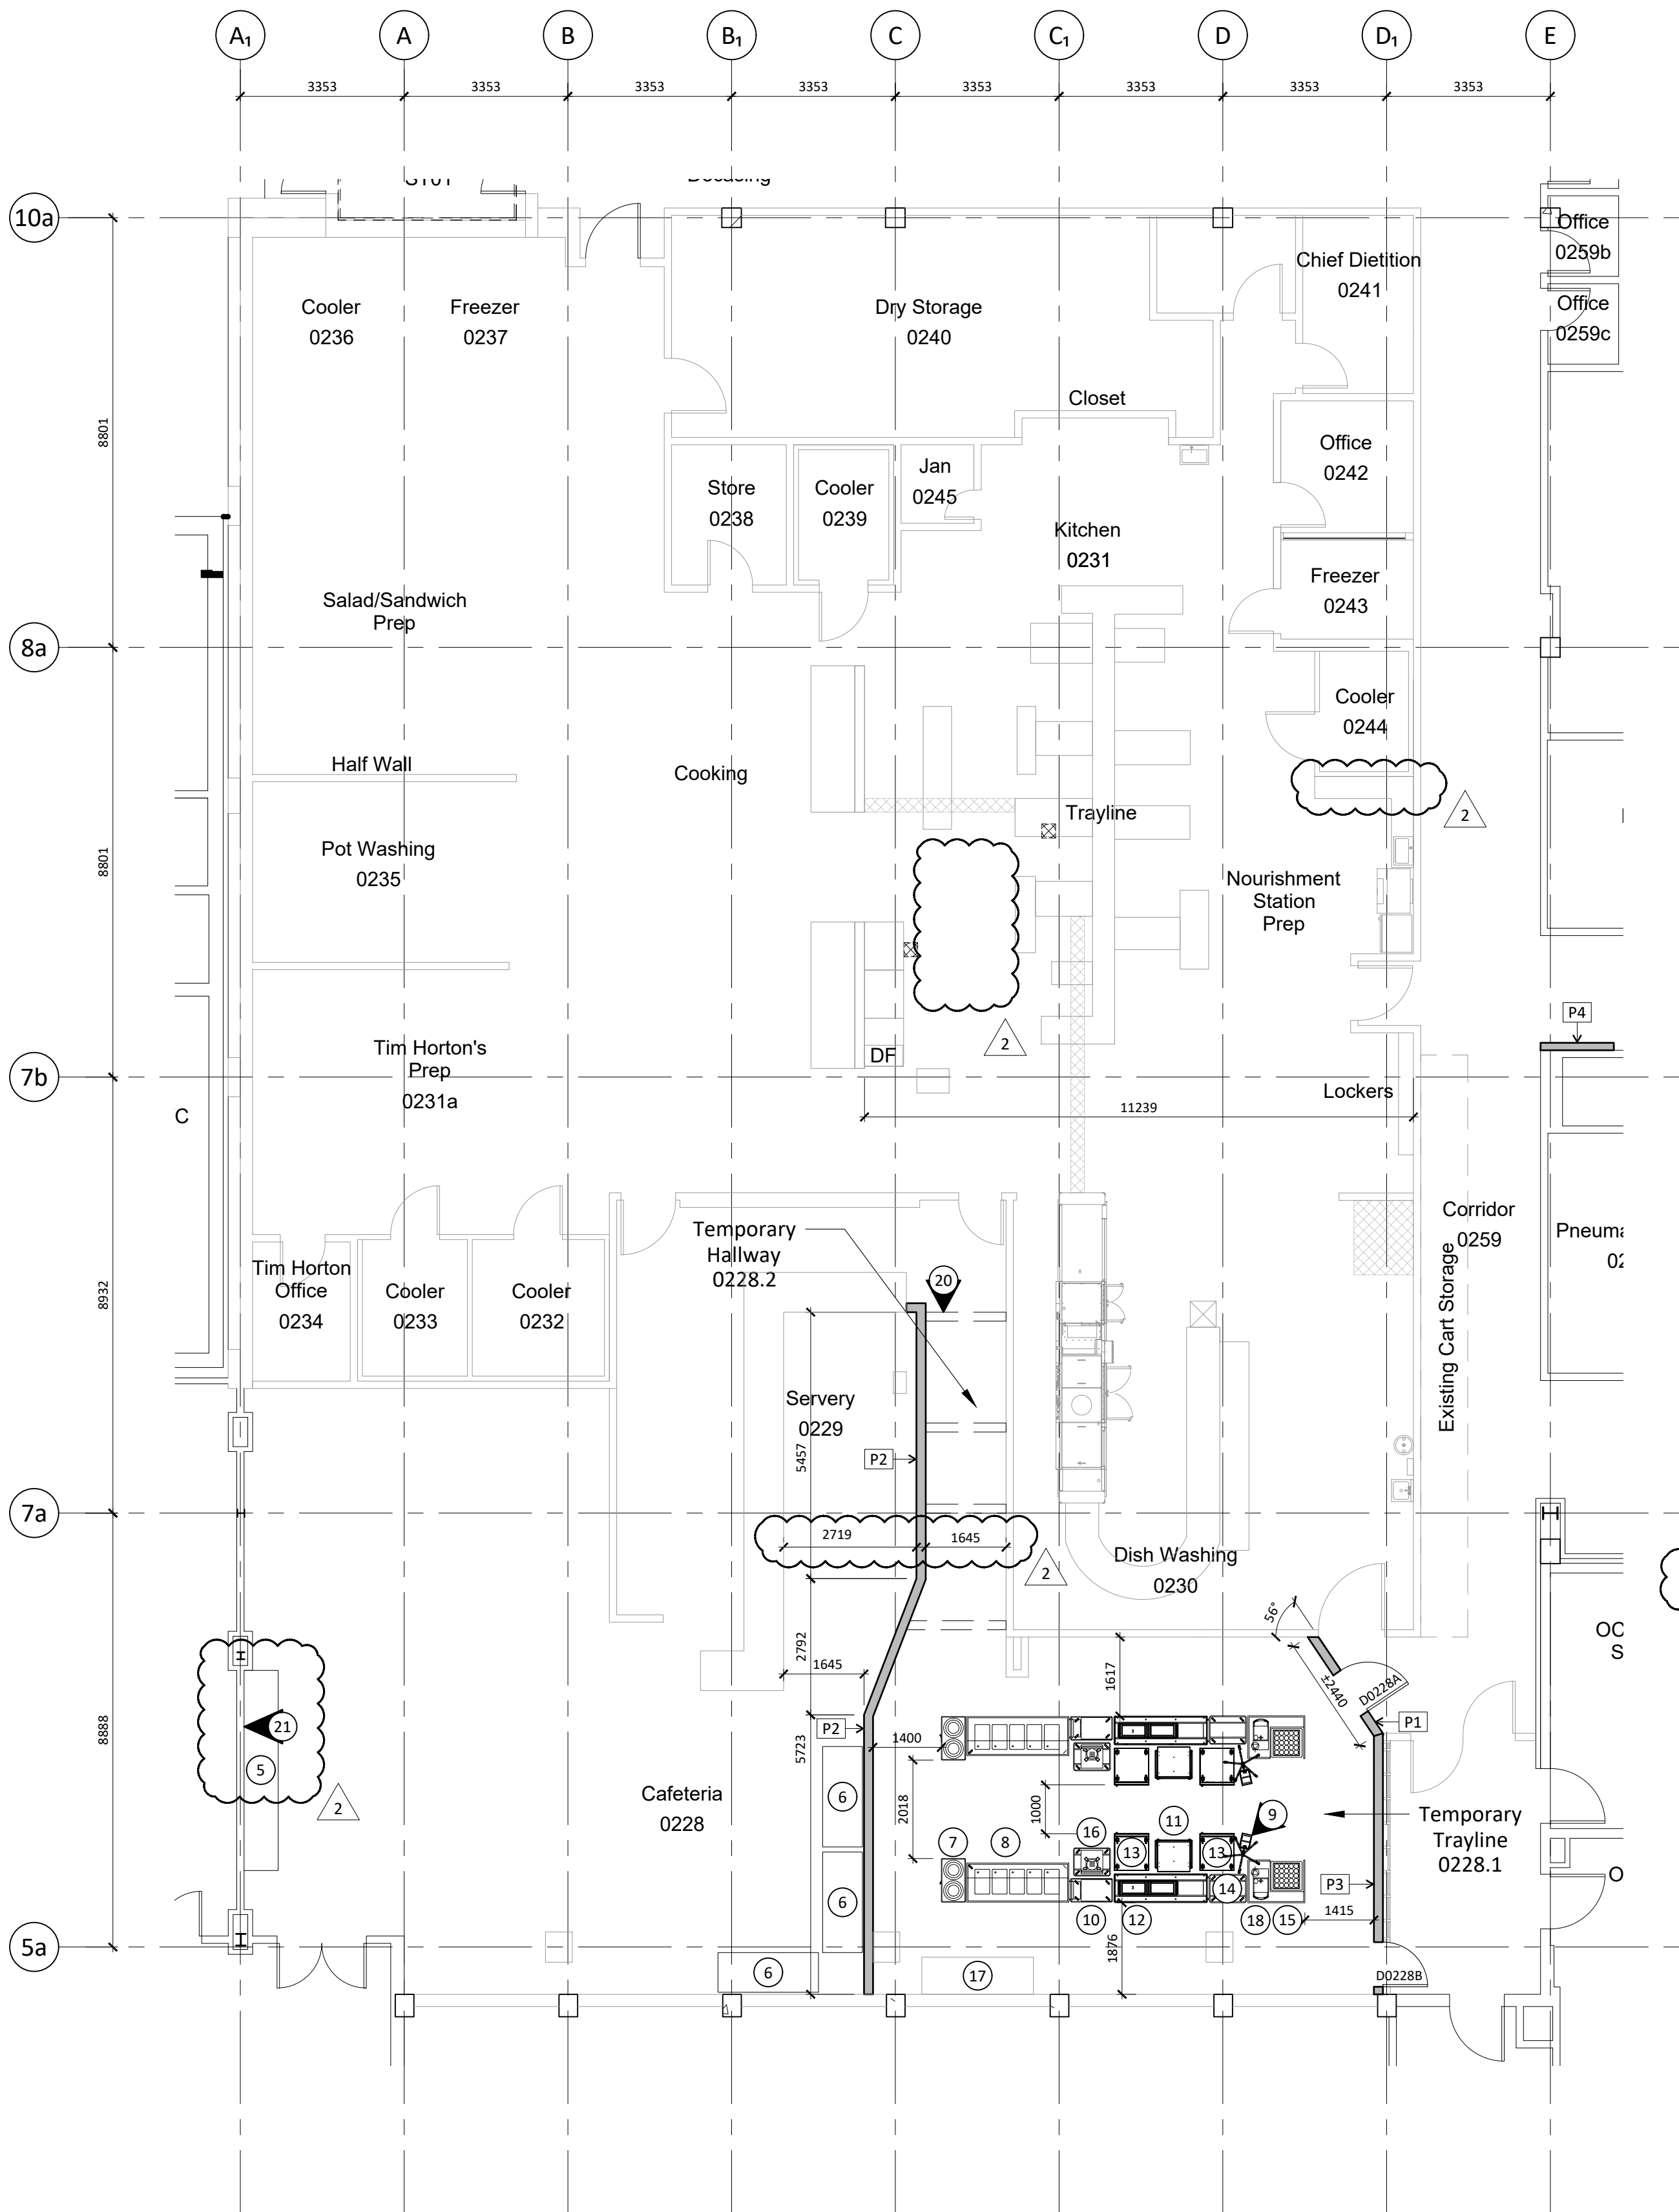

2 LEVEL 0 FLOOR PLAN - PHASE 1
A110 1:100 TEMPORARY TRAYLINE

DEMO PLAN GENERAL NOTES

- GENERAL CONTRACTOR TO COORDINATE ALL DEMOLITION. CONTRACTORS TO INSPECT EXISTING SITE TO FAMILIARIZE THEMSELVES WITH ALL CONDITIONS AND THE ENTIRE PROJECT DOCUMENTATION. NO ALLOWANCE WILL BE MADE FAILING TO DO SO.
- DEMOLITION TO TERMINATE CLEAN TO FACE OF ABUTTING STRUCTURE. PREP SURFACE TO SUIT APPLICATION OF NEW MATERIALS UNLESS NOTED OTHERWISE.
- ALL DEBRIS TO BE REMOVED FROM SITE ON A REGULAR BASIS. PREMISES TO BE KEPT CLEAN AT ALL TIMES.
- ELECTRICAL AND MECHANICAL CONTRACTORS TO COORDINATE ALL ELECTRICAL AND MECHANICAL DEMOLITION. DEVICES TO BE SALVAGED FOR RE-USE. GENERAL CONTRACTOR TO COORDINATE STORAGE LOCATION.
- COMPLY WITH CONSTRUCTION WASTE MANAGEMENT AND DISPOSAL REQUIREMENTS FOR LEED INDICATED IN THE SPECIFICATION.
- CONTRACTOR IS TO RETURN ALL SALVAGED DEMOLITION ITEMS TO THE OWNER UNLESS DIRECTED OTHERWISE.
- REMOVE ALL EXISTING FLOOR FINISHES AND ASSOCIATED BASEBOARDS AS NOTED.
- EXISTING TRAYLINE, PREP TABLE AND EXISTING STAINLESS STEEL COUNTER ADJACENT TO THE COOLER WILL BE REMOVED AND STORED BY NORTHERN HEALTH.
- ALL OTHER EXISTING EQUIPMENT TO BE REMOVED AND HANDED OVER TO OWNER.
- KEYNOTES DENOTING TRAYLINE EQUIPMENT ARE TYPICAL TO BOTH TRAYLINES.

DEMO PLAN LEGEND

- DEMOLISH PARTITION
- EXISTING PARTITION
- EXISTING WINDOW TO REMAIN
- EXISTING DOOR & FRAME TO BE REMOVED
- EXISTING FLOOR & FRAME TO REMAIN
- EXISTING EQUIPMENT TO BE REMOVED
- PLAN KEYNOTE INDICATOR
- EXISTING FLOOR FINISH TO BE REMOVED
- EXISTING FLOOR DRAIN

PLAN KEYNOTES


- DEMOLISH PARTITION
- REMOVE DOOR & FRAME, DOOR OPERATOR, ELECTRIC STRIKE, & CARD READER AND STORE FOR REUSE OR TURN OVER TO OWNER
- BEVERAGE STATION C/W EQUIPMENT TO BE RELOCATED
- REMOVE DOOR & HARDWARE & STORE FOR REUSE
- MODIFY AND RELOCATE BEVERAGE STATION
- RELOCATED COOLER LOCATION

EQUIPMENT KEYNOTES

- DISH DISPENSER
- 5 WELL HOT TABLE
- TELESCOPIC BIN HOLDER
- MOBILE ADJUSTABLE TRAY LOWERATOR
- GRAVITY SHELF
- REFRIGERATED TRAY SLIDE TABLE
- AIR CURTAIN REFRIGERATOR
- SHORT TRAY SLIDE TABLE
- BEVERAGE STATION
- ALADDIN TEMP-RITE HOD
- NEW PREP TABLE
- HOT WATER DISPENSER, TYPICAL
- PREP TABLE TO BE REMOVED
- ADD OVERHEAD BRACES SECURED TO EXISTING WALLS TO SUPPORT NEW WALL AND MINIMIZE FASTENING POINTS TO FLOOR, TYP.
- INSTALL GLAZING FILM TO 1067MM AFF PRIOR TO RELOCATING BEVERAGE STATION

KEY PLAN

N.T.S.

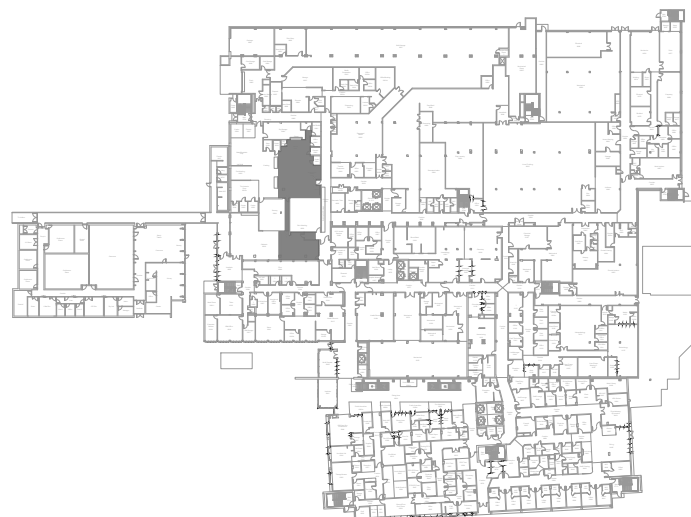

Copyright Reserved

This plan and design are the exclusive property of Thinkspace Architecture Inc. and shall not be reproduced, stored in a retrieval system, or transmitted in any form or by any means, electronic, mechanical, photocopying, recording, or by any information storage and retrieval system, without the prior written consent of Thinkspace. This office shall be informed of any variations from the information shown on this drawing. Do not scale drawing.

Thinkspace is a partnership of:
Todd Dust, Architect ABC, AAA
Henk Kampman, Architect ABC, AAA
Ray Wolfe, Architect ABC

Issue Date: 2023-04-11

NO.	DATE	DESCRIPTION
1	2023-02-08	ISSUED FOR BID
2	2023-03-01	ISSUED FOR ADDENDUM 01
3	2023-03-09	ISSUED FOR BLDG. PERMIT
4	2023-04-11	ISSUED FOR CONSTRUCTION

*Sheet changes clouded and tagged respectively.

thinkspace 50 YEARS
1963-2023

architecture planning interior design ltd.


300 - 10190 152A St. | Surrey, BC | V3R 1J7
t 604.581.8128 | f 604.581.8148 | w thinkspace.ca

Project: **UHN TRAYLINE ASSEMBLY SYSTEM REPLACEMENT**
Drawing: 1475 EDMONTON STREET, PRINCE GEORGE, BC, V2M 1S2
Sheet Number: **A110**


NOTE1
NOTE2

LEVEL 0 FLOOR PLAN - PHASE 1

Plot Date: 2023-02-08 File Path: I:\220937 ag-uhh trayline assembly system replacement\3.0 drawings\3.3 autocad\220937 - a110 level 0 floor plan - phase 1.dwg

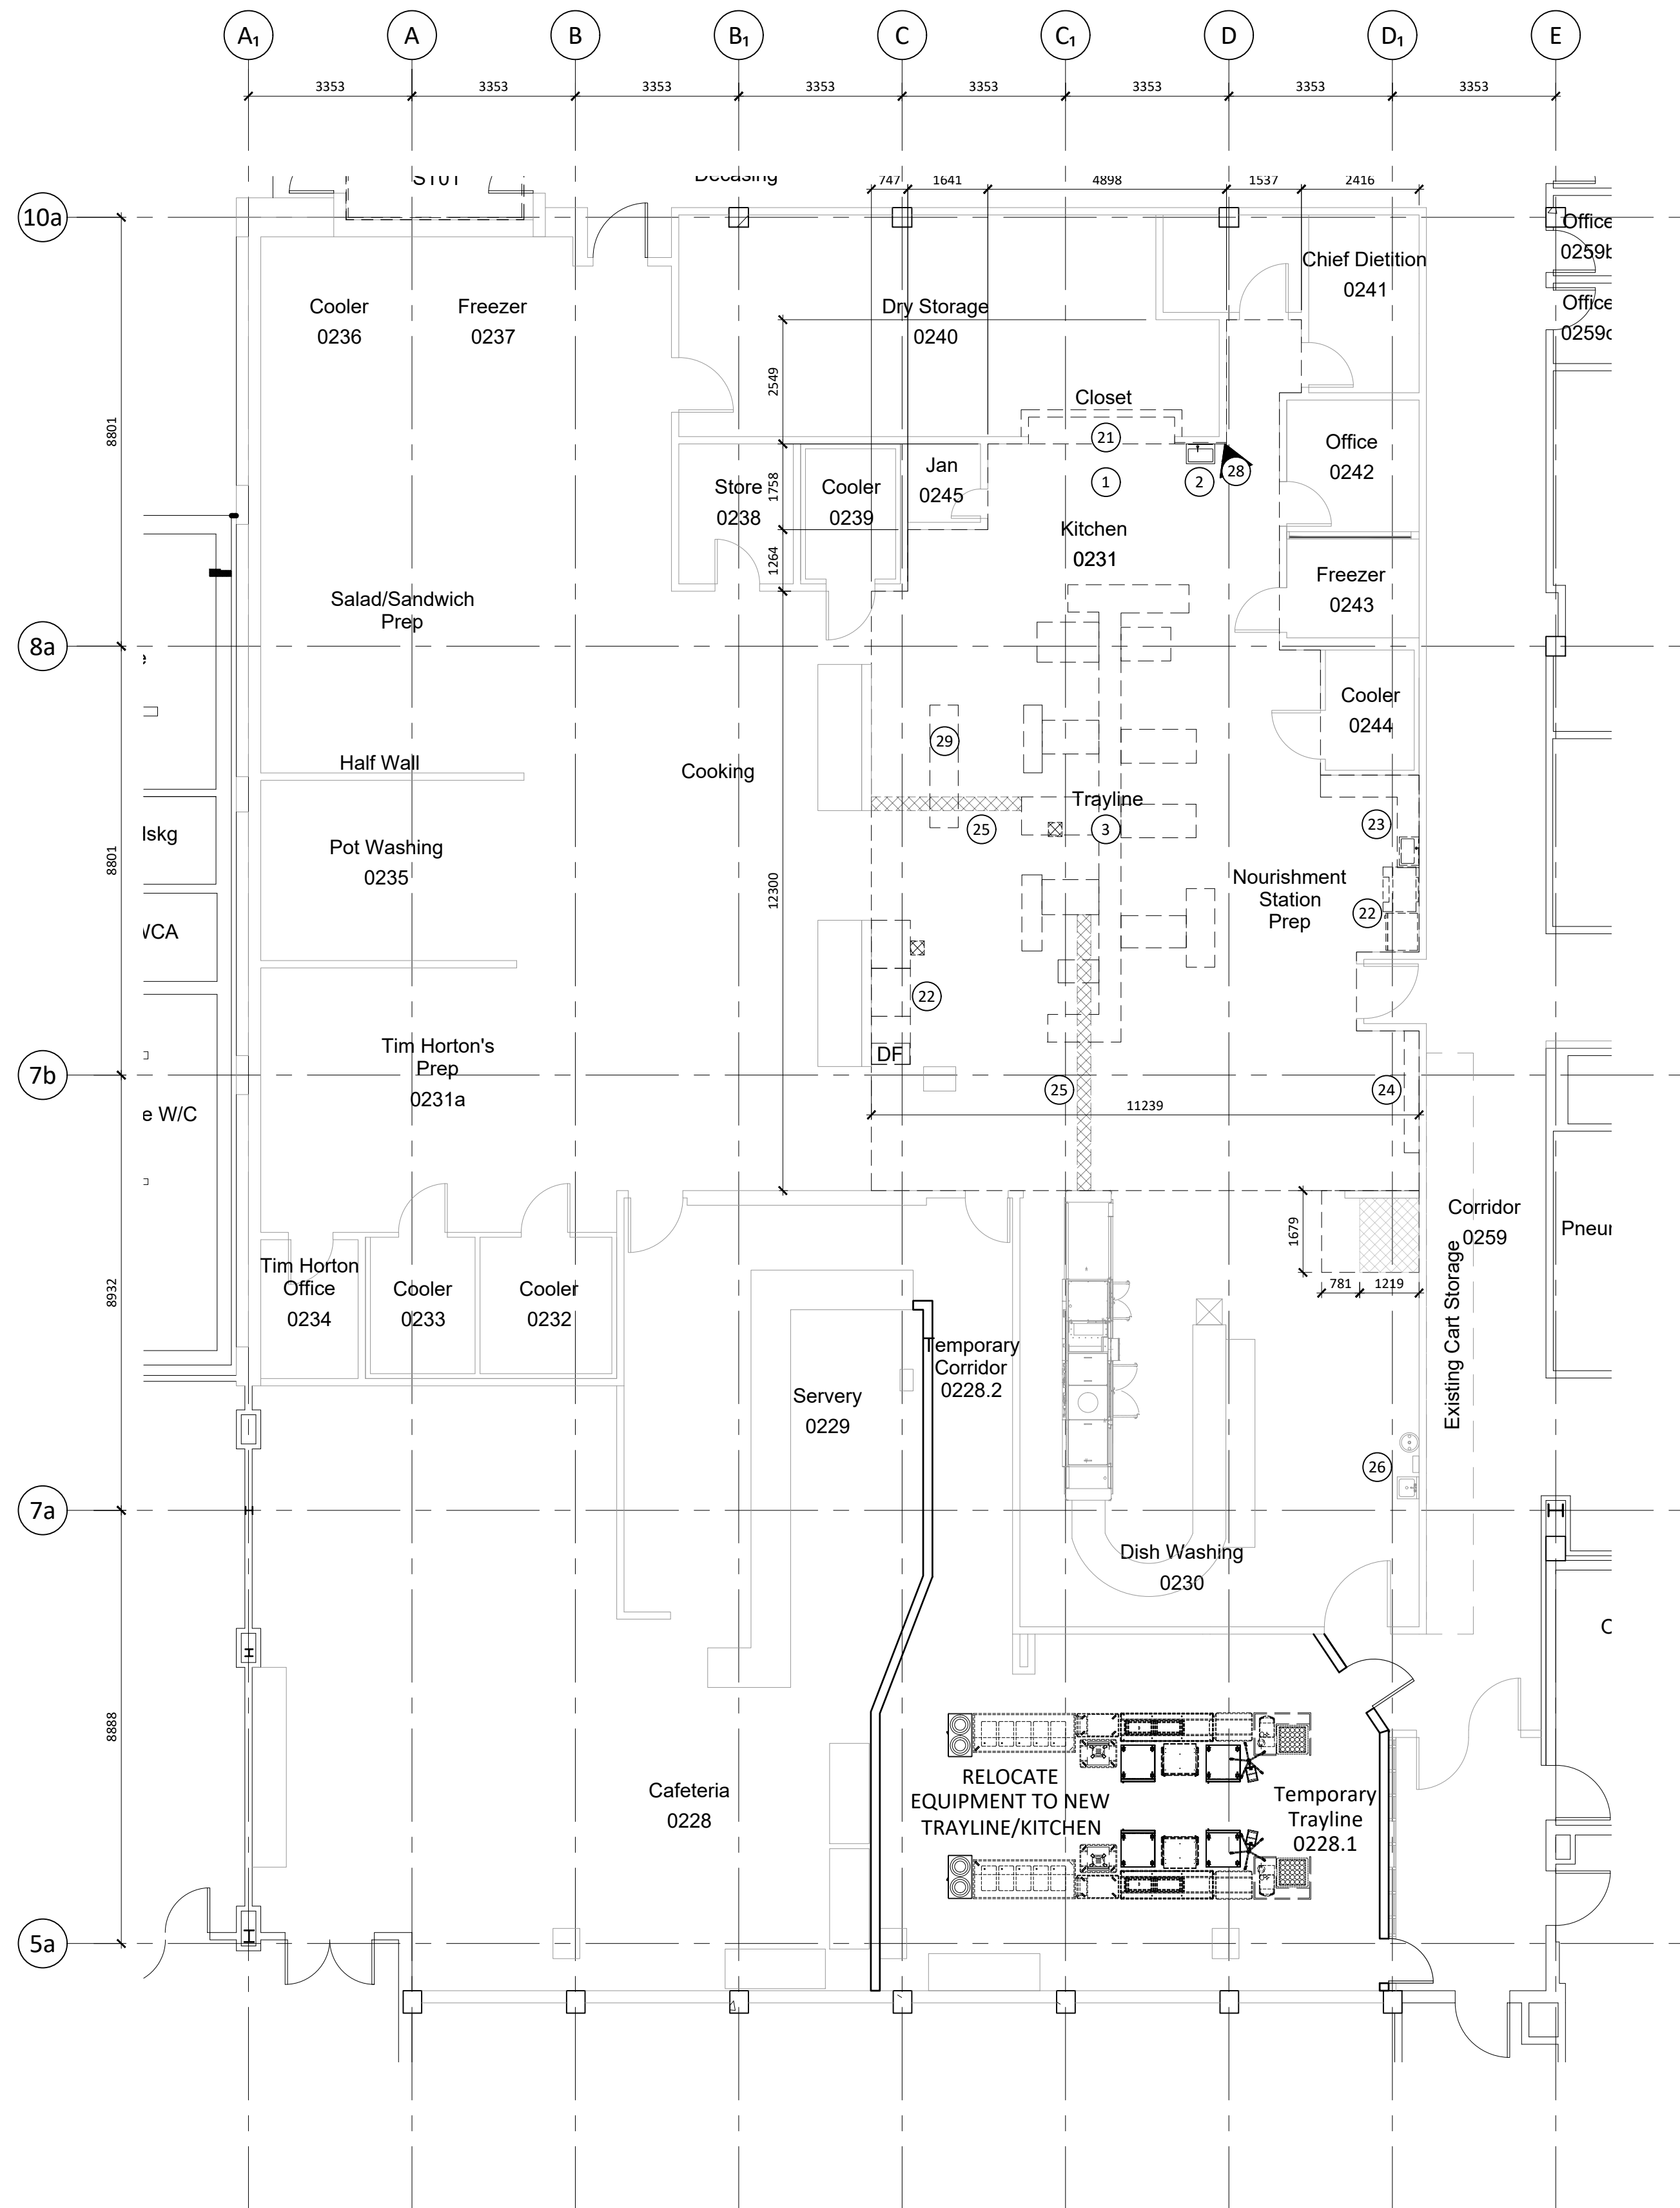

1 LEVEL 0 DEMO PLAN - PHASE 2
A111 1:100 EXISTING TRAYLINE

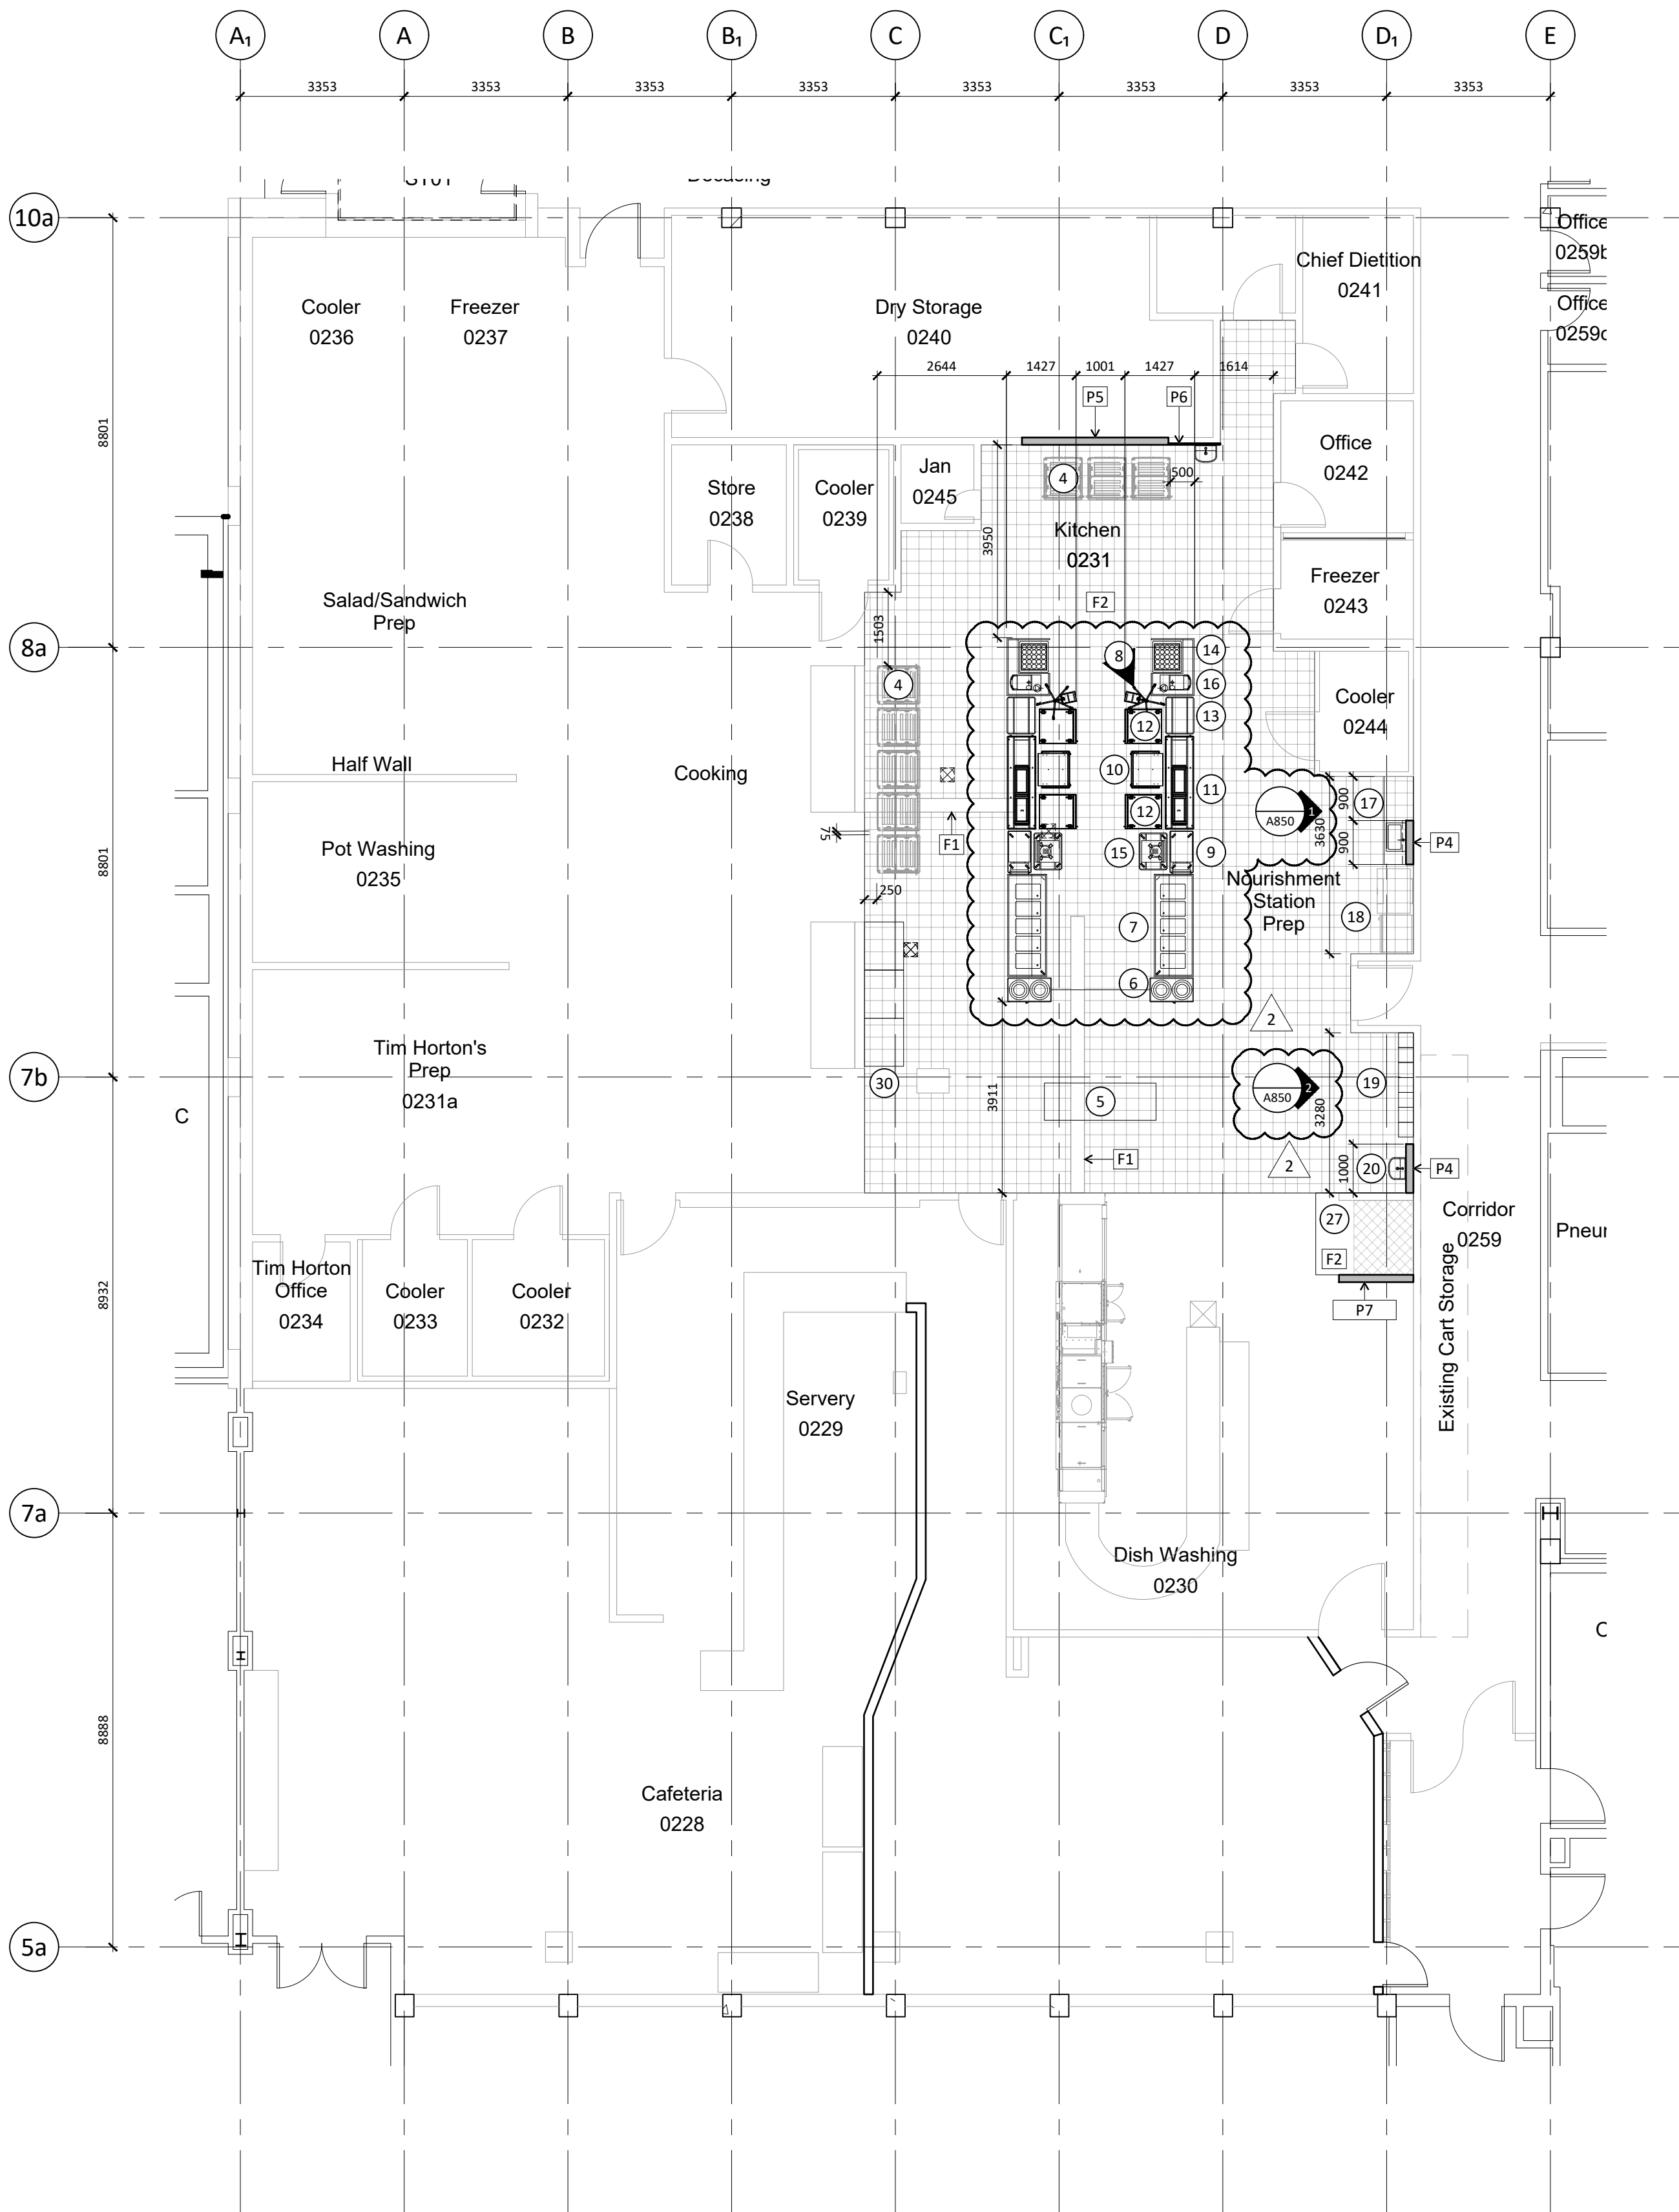

2 LEVEL 0 FLOOR PLAN - PHASE 2
A111 1:100 NEW TRAYLINE

FLOOR PLAN GENERAL NOTES

- REPAIR AND LEVEL ALL FLOOR SUBSTRATES IN PREPARATION FOR INSTALLATION OF NEW FLOORING FINISHES AS REQUIRED.
- THE CONTRACTOR IS TO SUBMIT ALL FINISH SAMPLES TO THE ARCHITECT FOR REVIEW PRIOR TO INSTALLATION.
- ALL NEW TRAYLINE EQUIPMENT IS TO BE INSTALLED BY THE VENDOR.
- KEYNOTES DENOTING TRAYLINE EQUIPMENT ARE TYPICAL TO BOTH TRAYLINES.

FLOOR PLAN LEGEND

- NEW PARTITION
- EXISTING PARTITION
- EXIT SIGNAGE
- AD - AREA DRAIN
- FD - FLOOR DRAIN
- RD - ROOF DRAIN
- RAIN WATER LEADER
- NEW RESILIENT SHEET FLOORING (REFER TO ALTERNATE PRICE)
- EXISTING FLOOR DRAIN
- DEMOLISHED PARTITION


FLOOR PLAN KEYNOTES

- REMOVE TILE FLOOR & BASE & PREPARE FOR NEW FLOOR FINISH
- REMOVE EXISTING WALL MOUNTED SINK. OPEN EXISTING GYPSUM BOARD PARTITION IN PREPARATION FOR NEW SINK. REFER TO MECHANICAL DRAWINGS
- DISCONNECT SERVICES TO TRAYLINE AND TURN TRAYLINE OVER TO OWNER
- NEW MILLWORK & SINK
- REINSTALL STORED EQUIPMENT
- NEW LOCKERS
- NEW HAND HYGIENE SINK. REFER TO MECHANICAL
- DEMOLISH EXISTING MILLWORK & PARTITIONS
- REMOVE EXISTING EQUIPMENT & STORE FOR REUSE
- REMOVE EXISTING SS COUNTER C/W SINK AND TURN OVER TO OWNER
- DEMOLISH LOCKERS
- DEMOLISH EXISTING FLOOR TRENCH
- REMOVE STAINLESS STEEL SHROUD, SINK, AND EYEWASH
- SLOPE TO DRAIN
- REMOVE EXISTING DRYWALL AND WALL FINISH TO ACCOMMODATE MECHANICAL
- DISCONNECT SERVICES TO STAINLESS STEEL COUNTER AND TURN COUNTER AND SINK OVER TO OWNER
- REINSTALL EQUIPMENT

EQUIPMENT PLAN KEYNOTES

- BASE STATIONS, TYP x8
- PREP TABLE
- DISH DISPENSER
- 5 WELL HOT TABLE
- TELESCOPIC BIN HOLDER
- MOBILE ADJUSTABLE TRAY LOWERATOR
- GRAVITY SHELF
- REFRIGERATED TRAY SLIDE TABLE
- AIR CURTAIN REFRIGERATOR
- SHORT TRAY SLIDE TABLE
- BEVERAGE STATION
- ALADDIN TEMP-RITE HOD
- HOT WATER DISPENSER, TYPICAL

KEY PLAN

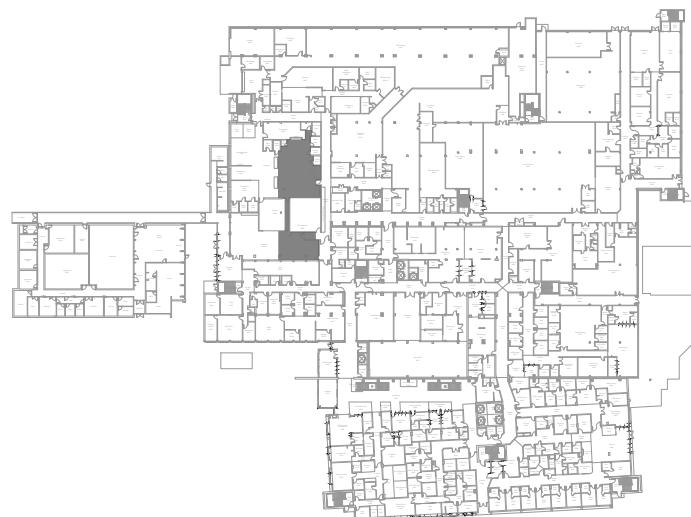

Copyright Reserved

This plan and design are the exclusive property of Thinkspace Architecture & Planning Interior Design (Pty) Ltd. No part of this drawing may be reproduced, stored in a retrieval system, or transmitted in any form or by any means, electronic, mechanical, photocopying, recording, or by any information storage and retrieval system, without the prior written consent of Thinkspace. This office shall be informed of any variations from the information shown on this drawing. Do not scale drawing.

Thinkspace a partnership of:
Todd Dust, Architect ABC, AAA
Henk Kampan, Architect ABC, AAA
Ray Wolfe, Architect ABC

Issue Date: 2023-04-11

NO.	DATE	DESCRIPTION
1	2023-02-08	ISSUED FOR BID
2	2023-03-01	ISSUED FOR ADDENDUM 01
3	2023-03-09	ISSUED FOR BLDG. PERMIT
4	2023-04-11	ISSUED FOR CONSTRUCTION

*Sheet changes clouded and tagged respectively.

thinkspace 50
1963-2023 YEARS

architecture planning interior design ltd.


300 - 10190 152A St. | Surrey, BC | V3R 1J7
t 604.581.8128 | f 604.581.8148 | w thinkspace.ca

Project Number: 220937
Drawing: LEVEL 0 FLOOR PLAN - PHASE 2
Sheet Number: A111


Project: UHN TRAYLINE ASSEMBLY SYSTEM REPLACEMENT
1475 EDMONTON STREET, PRINCE GEORGE, BC, V2M 1S2

NOTE1: UHN TRAYLINE ASSEMBLY SYSTEM REPLACEMENT V3.0 drawings V3.3 autocad 220937 - A111 Level 0 floor plan - phase 2.dwg
NOTE2: UHN TRAYLINE ASSEMBLY SYSTEM REPLACEMENT V3.0 drawings V3.3 autocad 220937 - A111 Level 0 floor plan - phase 2.dwg

Plot Date: 2023-02-08

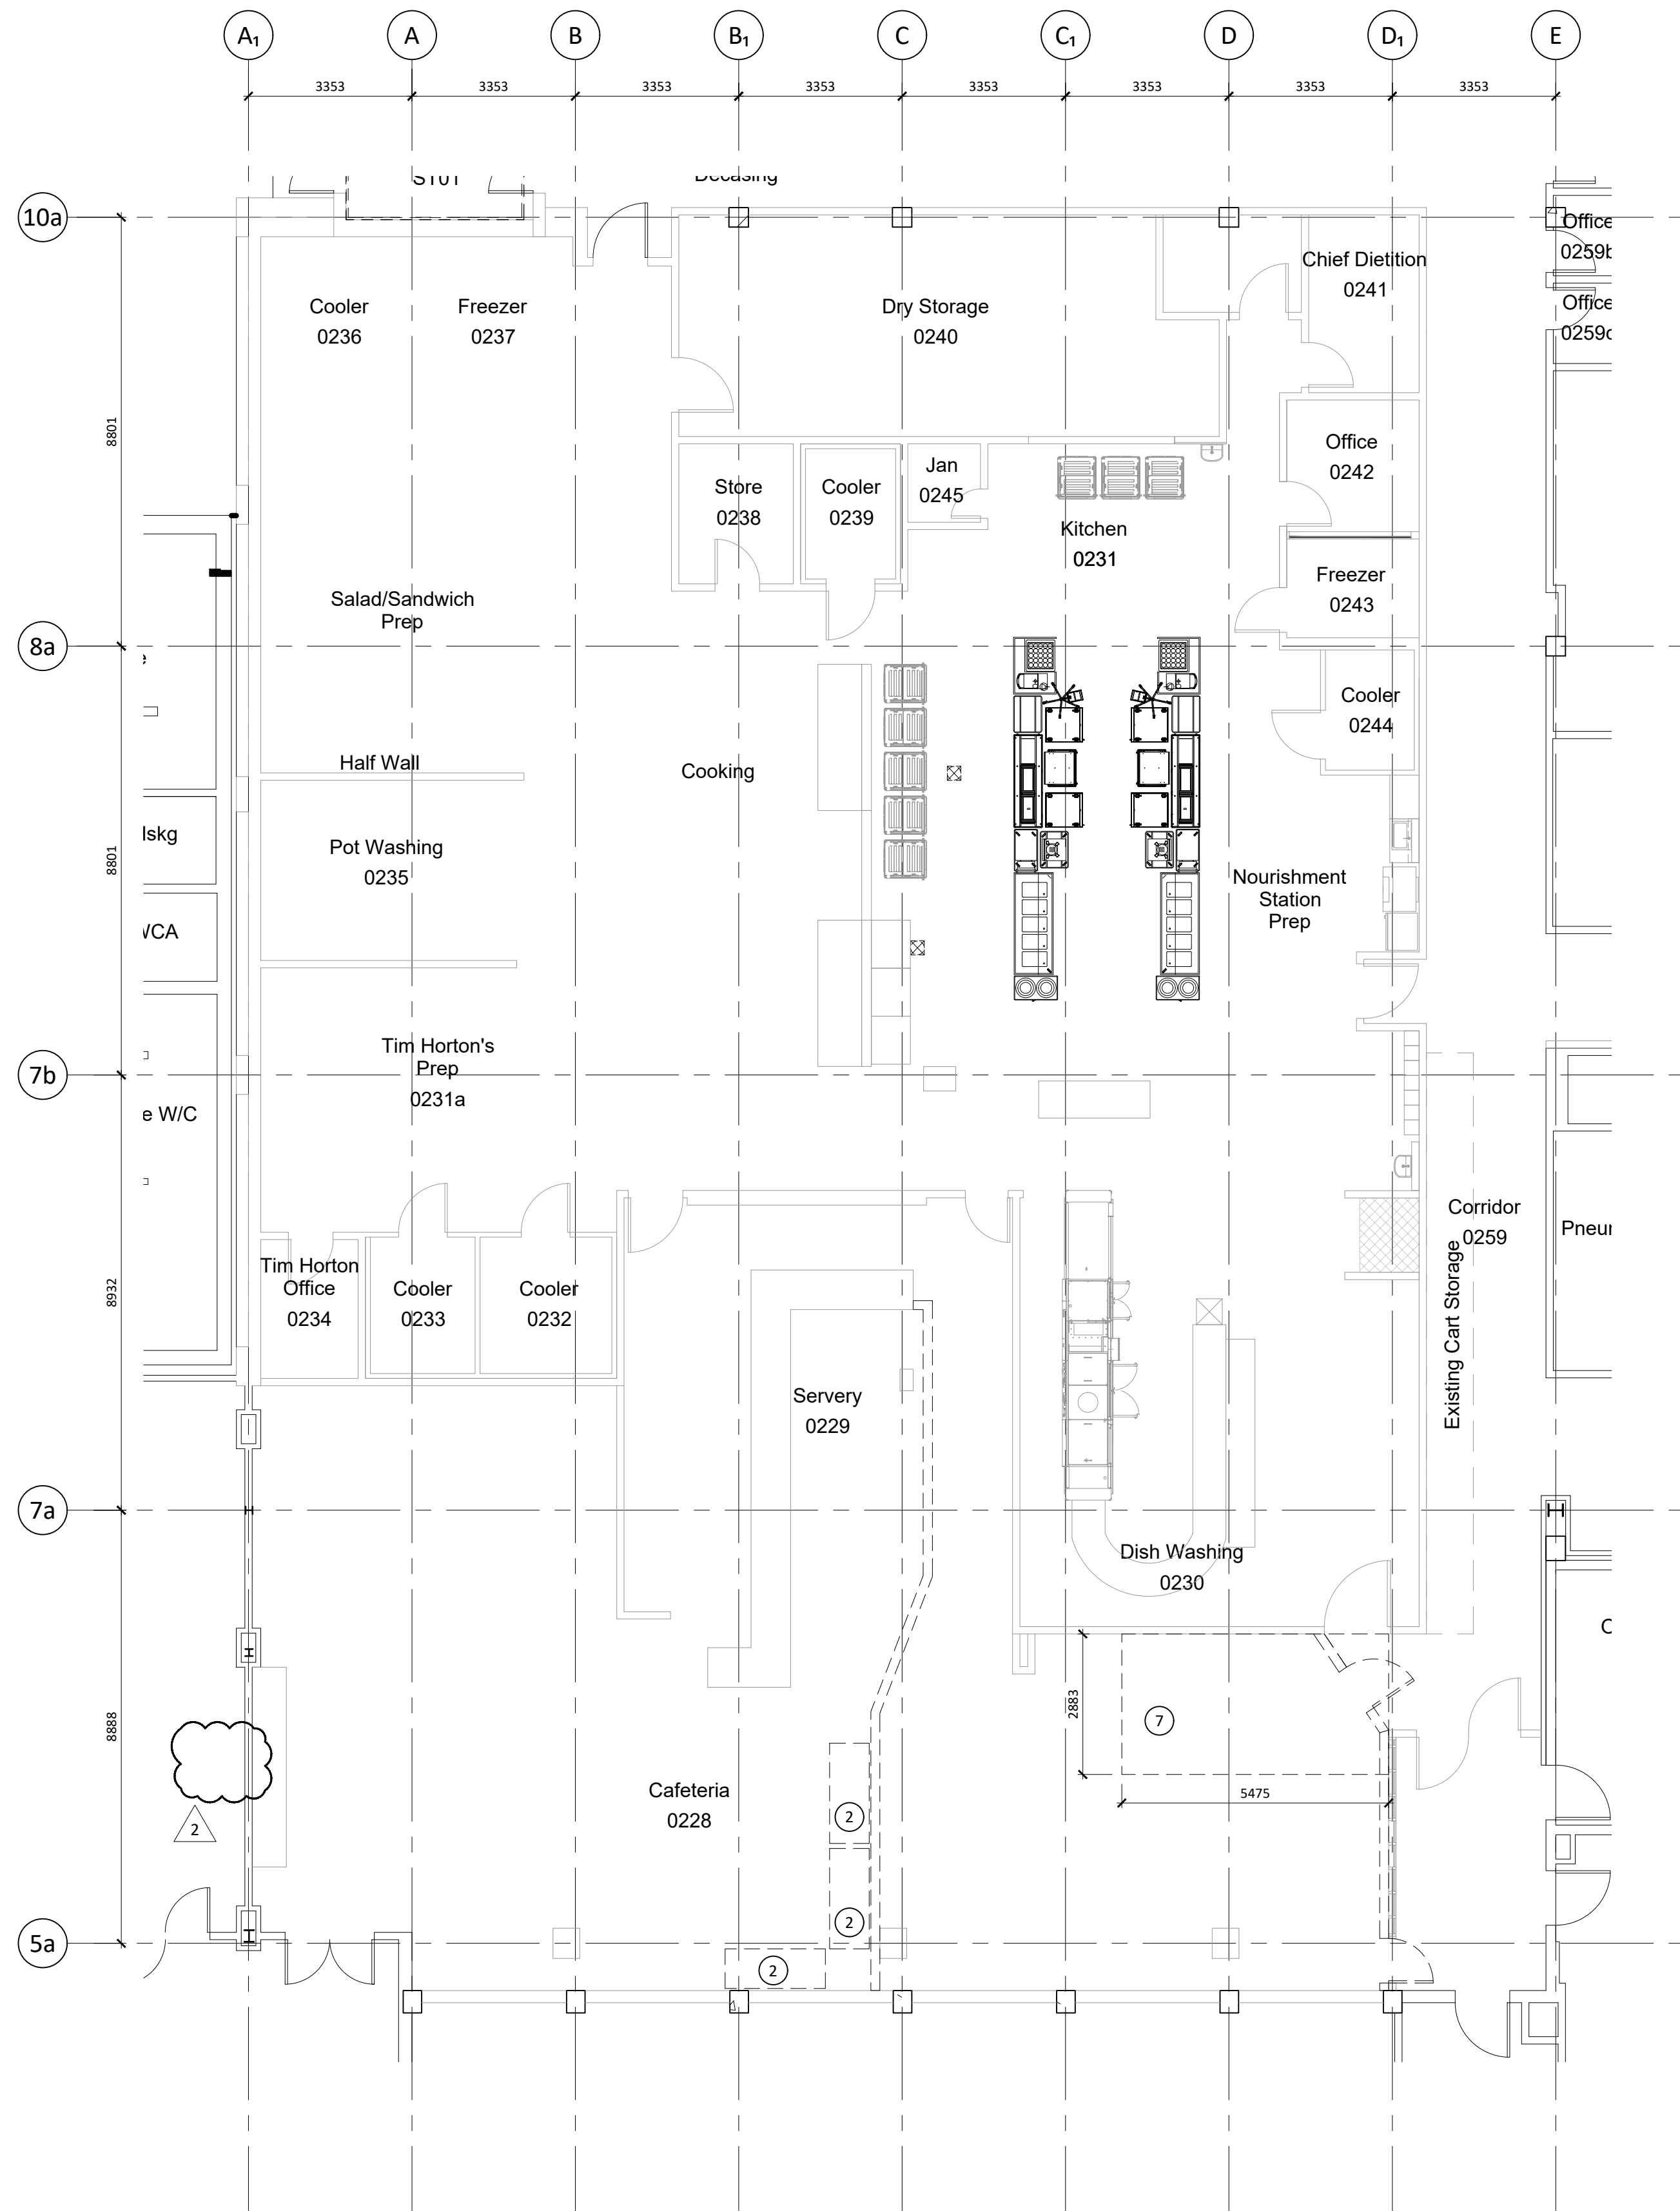

1 LEVEL 0 DEMO PLAN - PHASE 3
A112 1:100

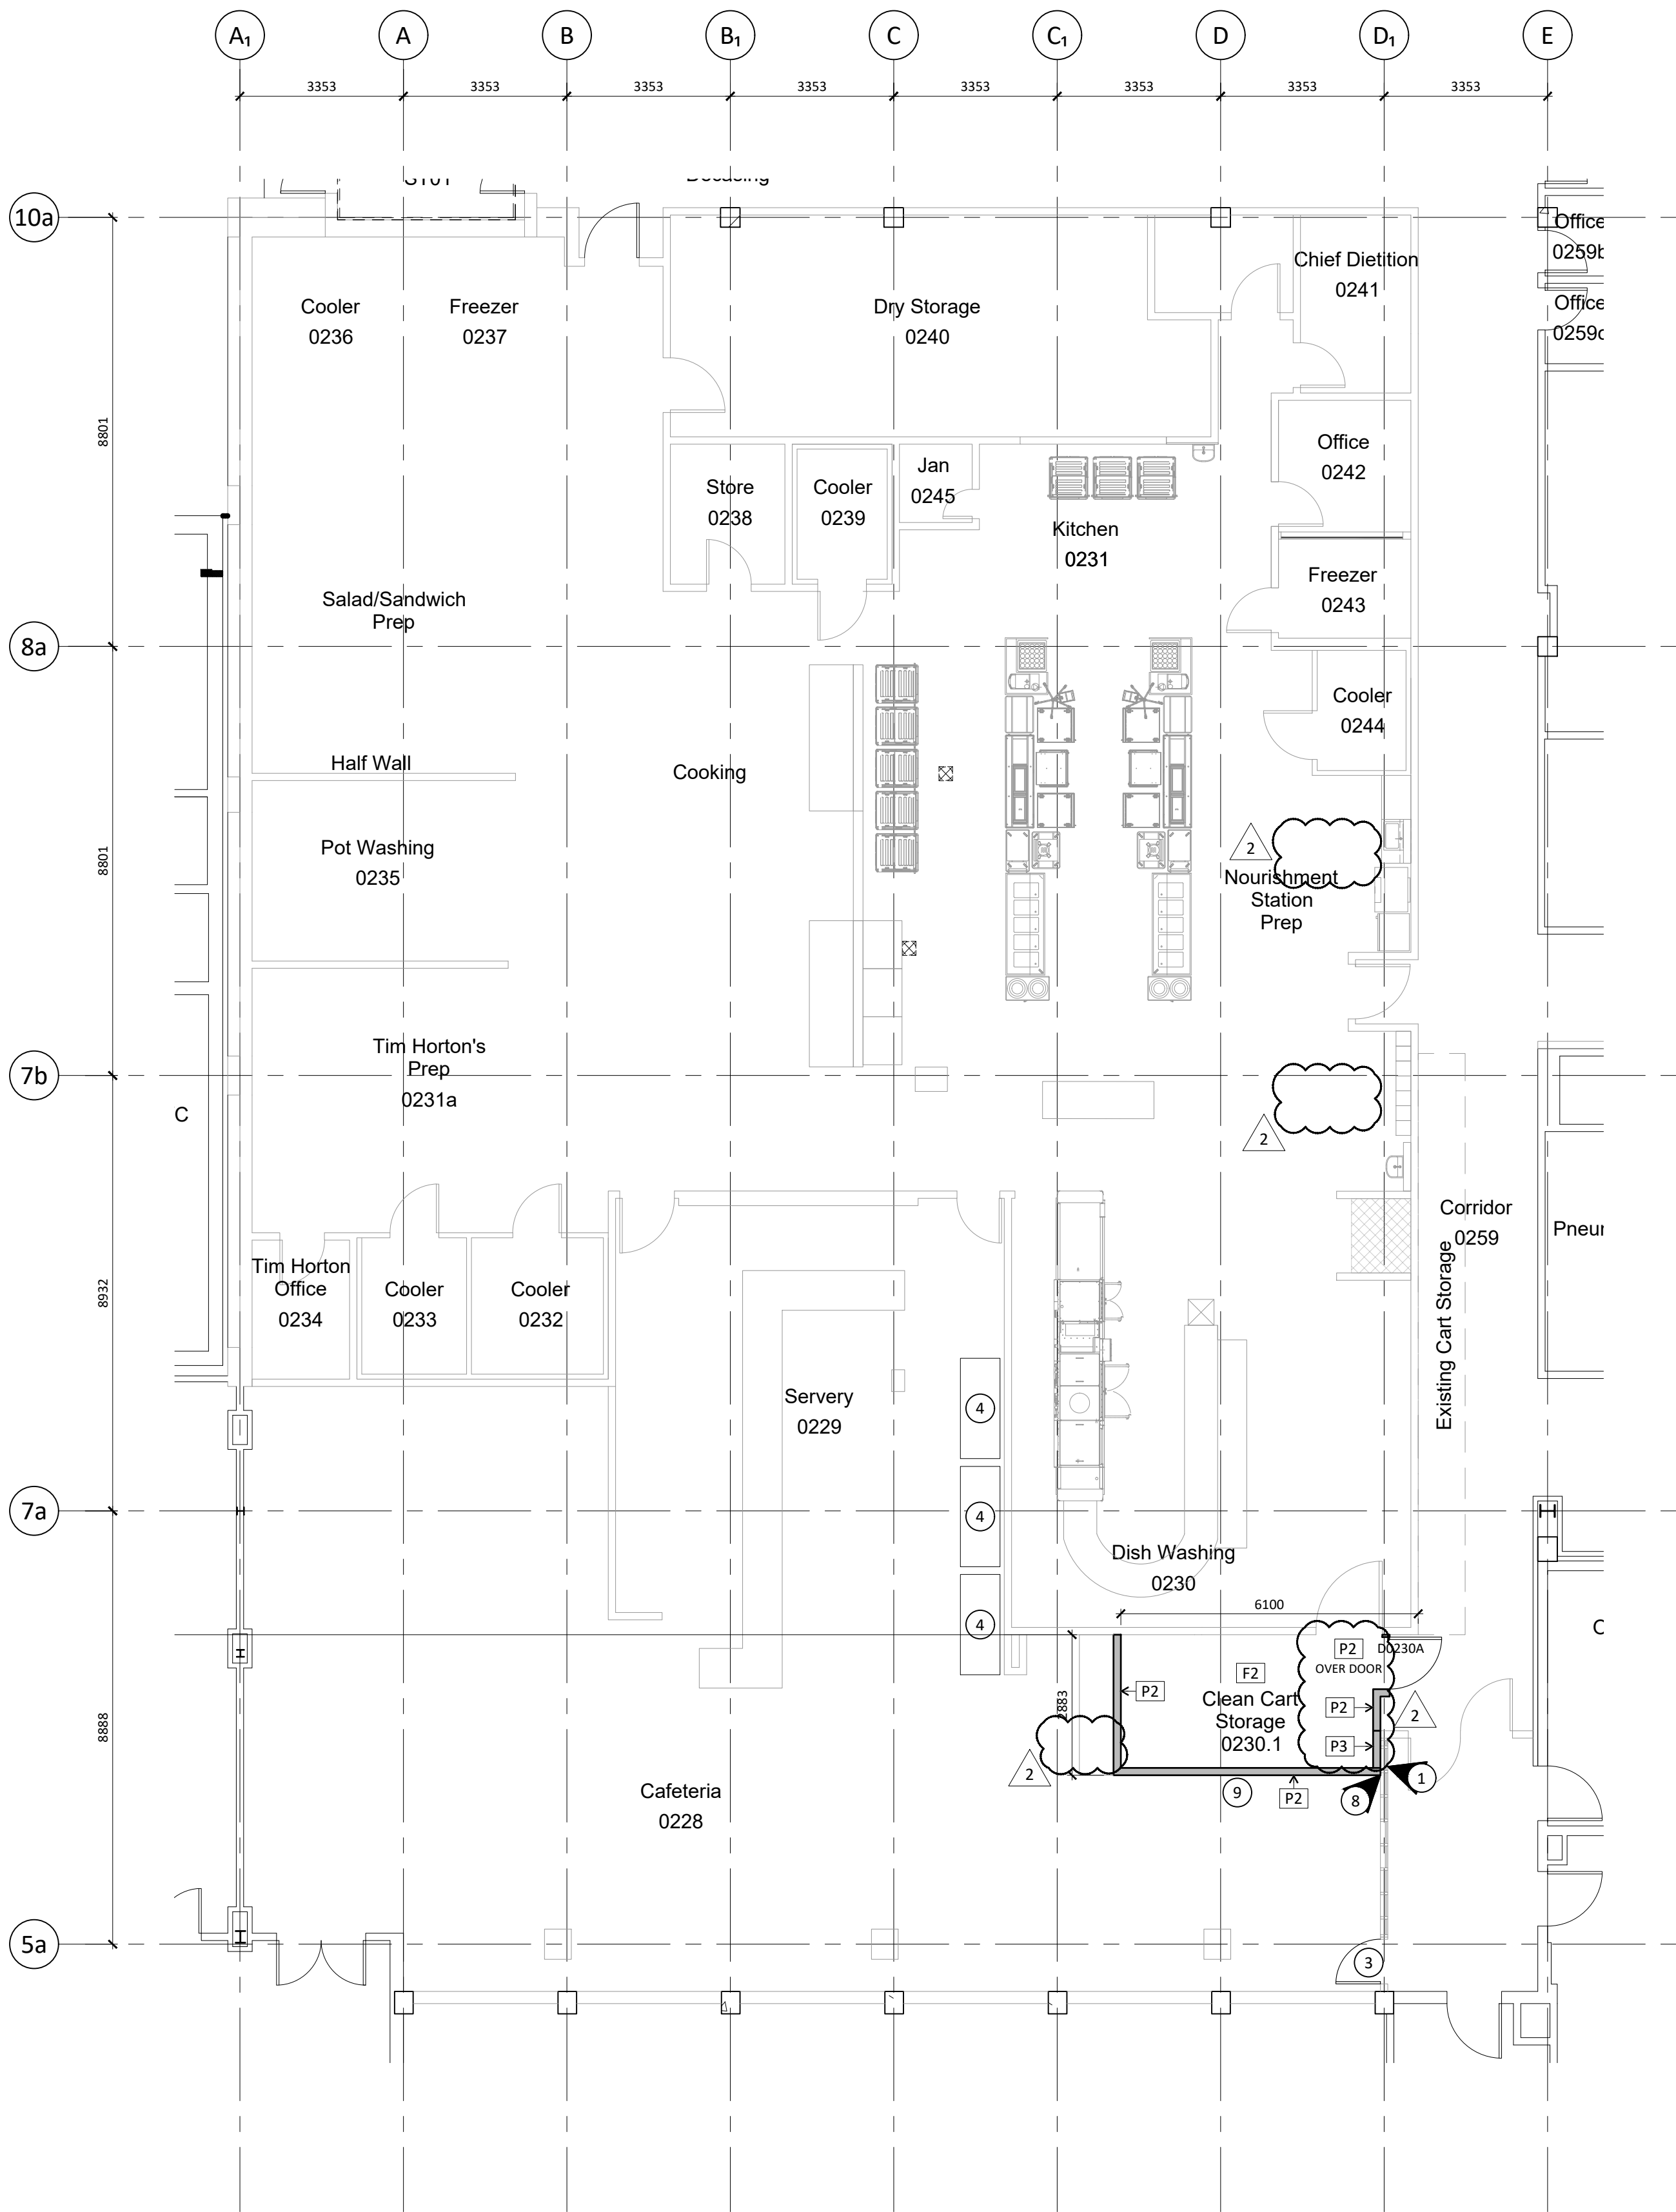

2 LEVEL 0 FLOOR PLAN - PHASE 3
A112 1:100

FLOOR PLAN GENERAL NOTES

- REPAIR AND LEVEL ALL FLOOR SUBSTRATES IN PREPARATION FOR INSTALLATION OF NEW FLOORING FINISHES AS REQUIRED.
- THE CONTRACTOR IS TO SUBMIT ALL FINISH SAMPLES TO THE ARCHITECT FOR REVIEW PRIOR TO INSTALLATION.
- ALL NEW TRAYLINE EQUIPMENT IS OWNER SUPPLIED, CONTRACTOR INSTALLED.


FLOOR PLAN LEGEND

- NEW PARTITION
- EXISTING PARTITION
- EXIT SIGNAGE
- AD - AREA DRAIN
- FD - FLOOR DRAIN
- RD - ROOF DRAIN
- RAIN WATER LEADER
- EXISTING FLOOR DRAIN
- DEMOLISHED PARTITION

FLOOR PLAN KEYNOTES

- INSTALL GLAZING FILM TO WINDOWS AT SHAFT WALL
- COOLERS TO BE RELOCATED
- REINSTALL DOOR & HARDWARE
- RELOCATE COOLERS
- NOT USED
- NOT USED
- REMOVE FLOOR & BASE & PREPARE FOR NEW FLOORING
- ALIGN EDGE OF WALL WITH WINDOW FRAME & SEAL
- ADD RUBBER BASE AT THE OUTSIDE OF THE ROOM

KEY PLAN

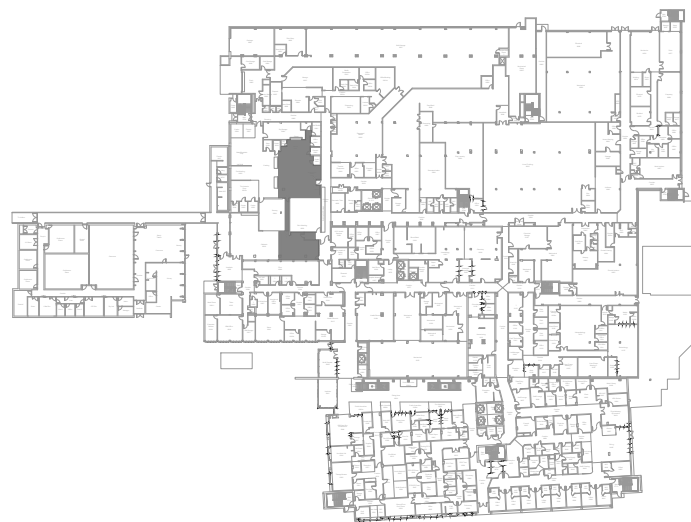

Copyright Reserved

This plan and design are the exclusive property of Thinkspace Architecture & Planning Inc. (Thinkspace). No part of this drawing may be reproduced, stored in a retrieval system, or transmitted in any form or by any means, electronic, mechanical, photocopying, recording, or by any information storage and retrieval system, without the prior written consent of Thinkspace. This office shall be informed of any variations from the information shown on this drawing. Do not scale drawings.

Thinkspace is a partnership of:
Todd Duff, Architect ABC, AAA
Heidi Kampan, Architect ABC, AAA
Ray Wolfe, Architect ABC


NO.	DATE	DESCRIPTION
1	2023-02-08	ISSUED FOR BID
2	2023-03-01	ISSUED FOR ADDENDUM 01
3	2023-03-09	ISSUED FOR BLDG. PERMIT
4	2023-04-11	ISSUED FOR CONSTRUCTION

thinkspace 50
1963-2023 YEARS
architecture planning interior design ltd.
300 - 10190 152A St. | Surrey, BC | V3R 1J7
t 604.581.8128 | f 604.581.8148 | w thinkspace.ca


Project Number	Project	NOTE1
220937	UHN TRAYLINE ASSEMBLY SYSTEM REPLACEMENT	

Sheet Number	Drawing	NOTE2
A112	LEVEL 0 FLOOR PLAN - PHASE 3	

Plot Date: 2023-02-08 File Path: I:\220937 ag-uhh trayline assembly system replacement\3.0 drawings\3.3 autocad\220937 - a112 level 0 floor plan - phase 3.dwg

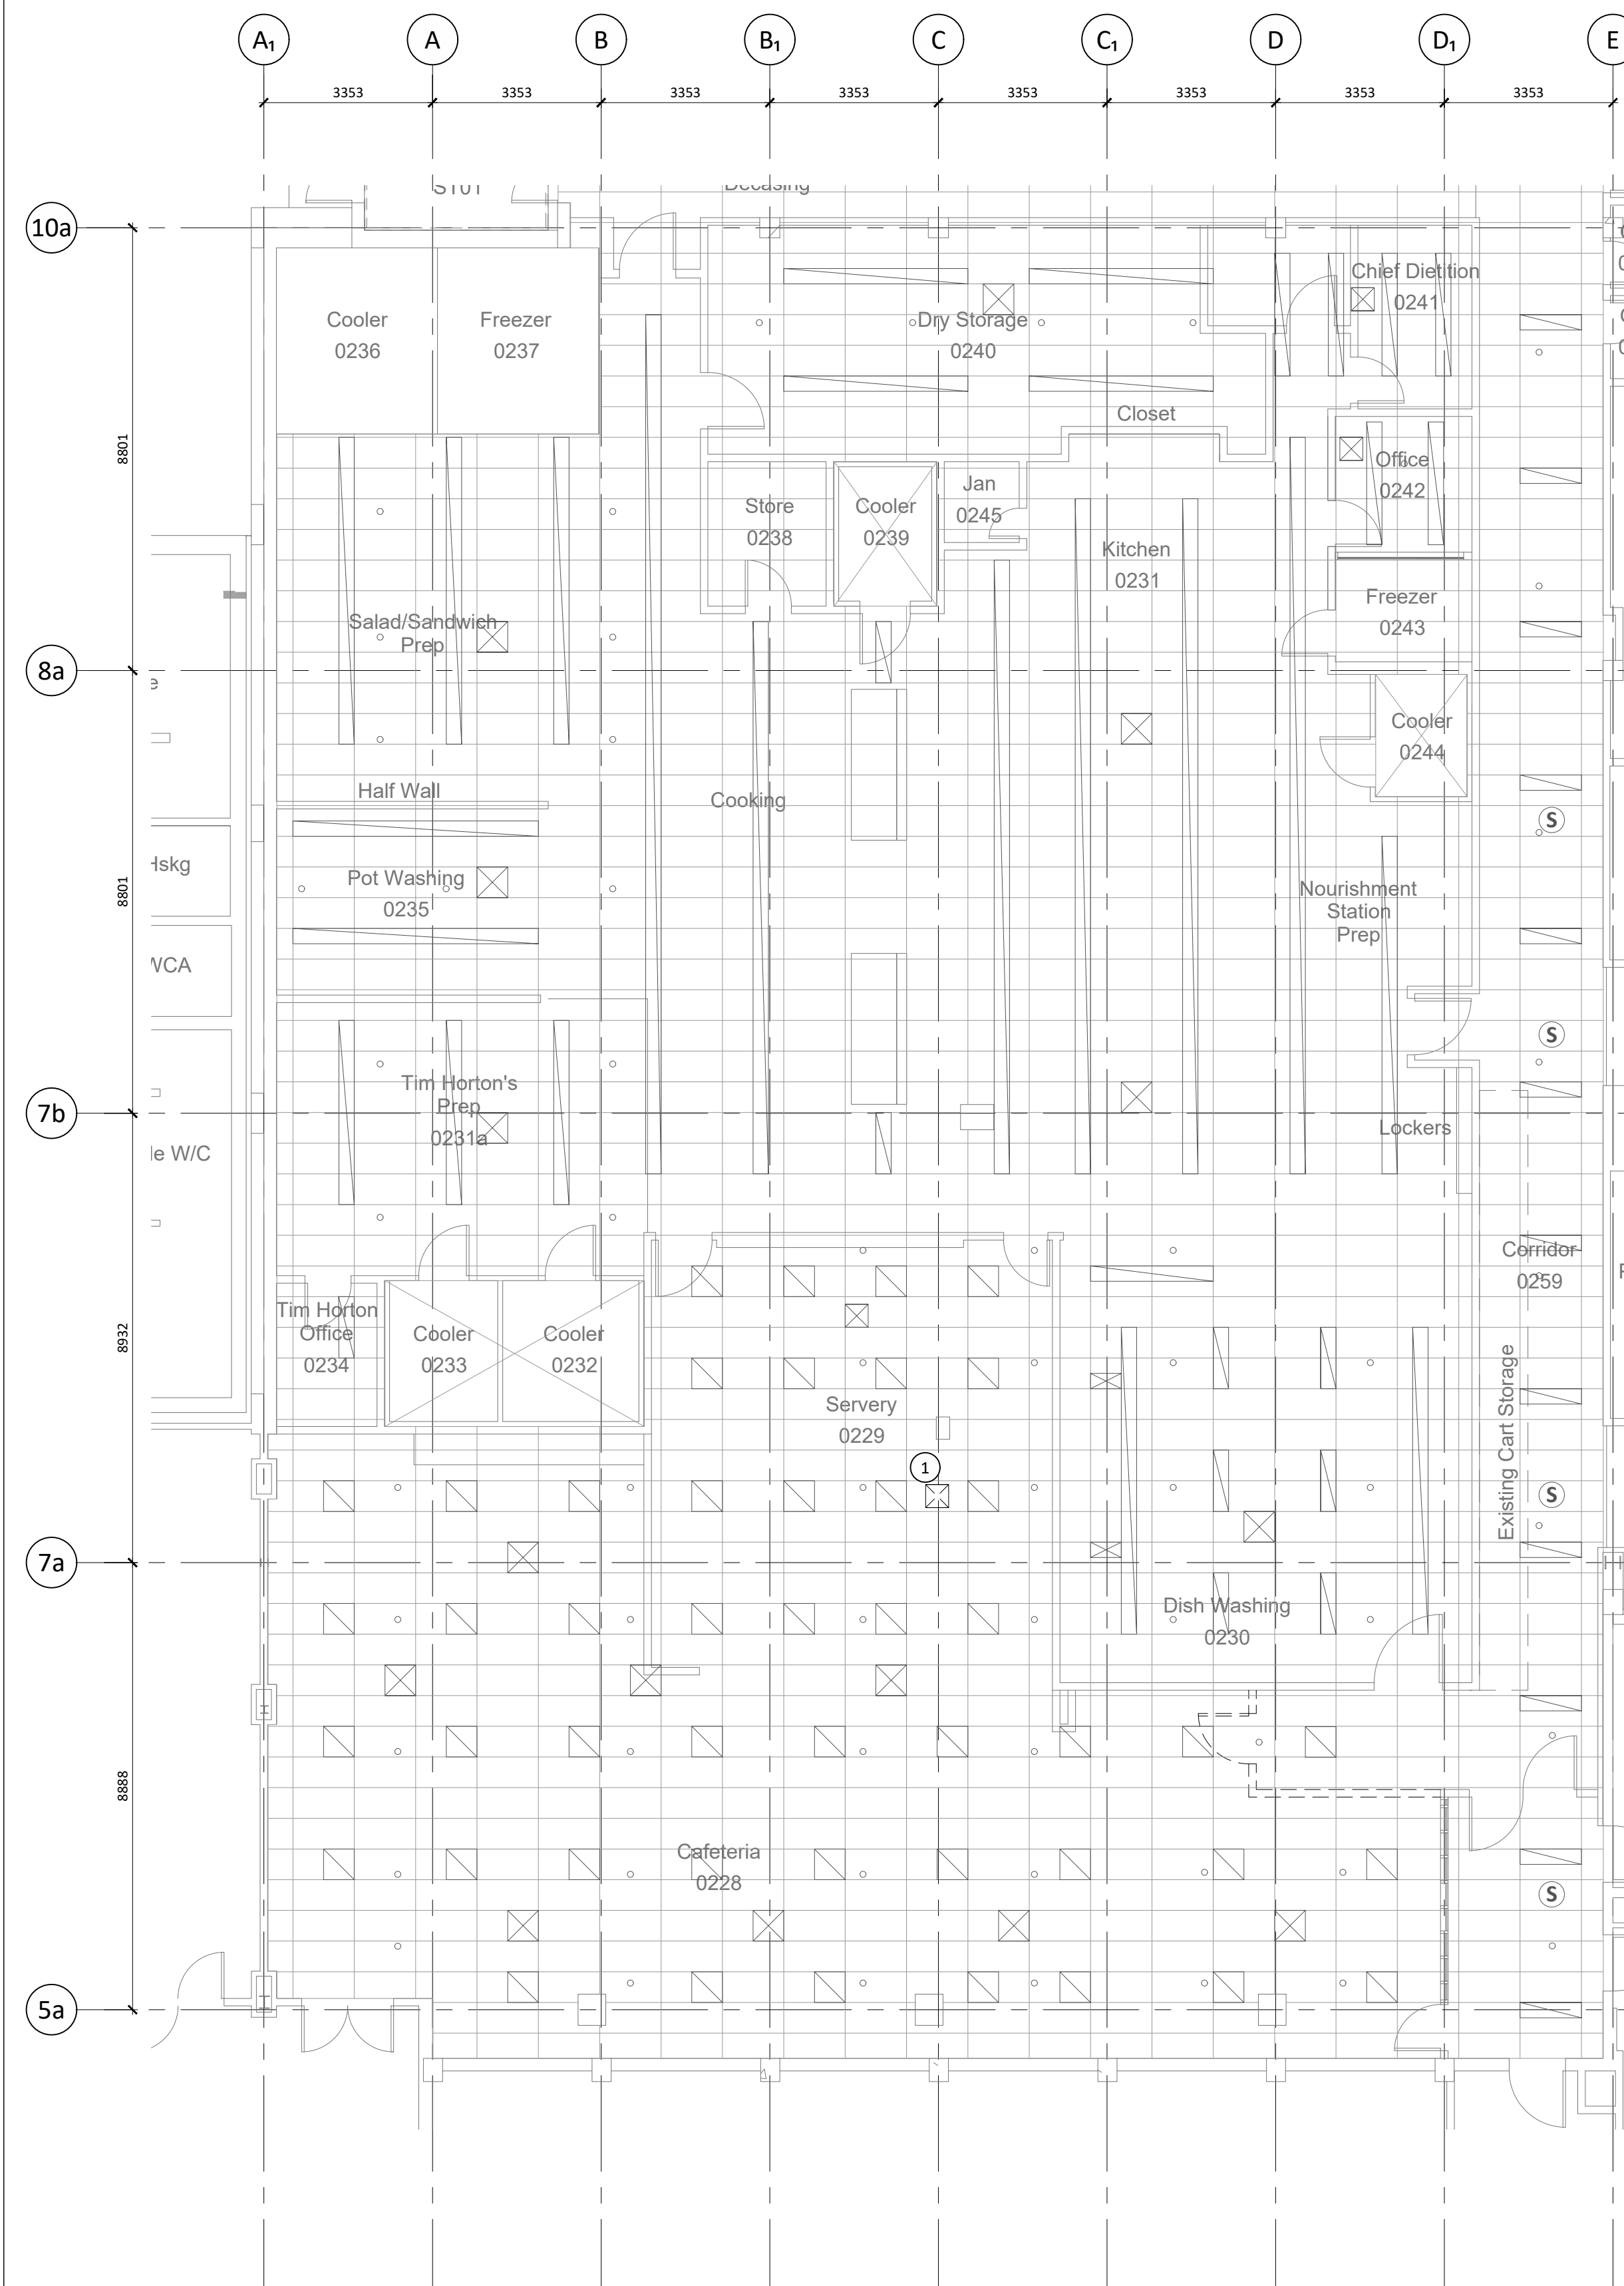

1 LEVEL 0 DEMO RCP - PHASE 1
A210 1:100

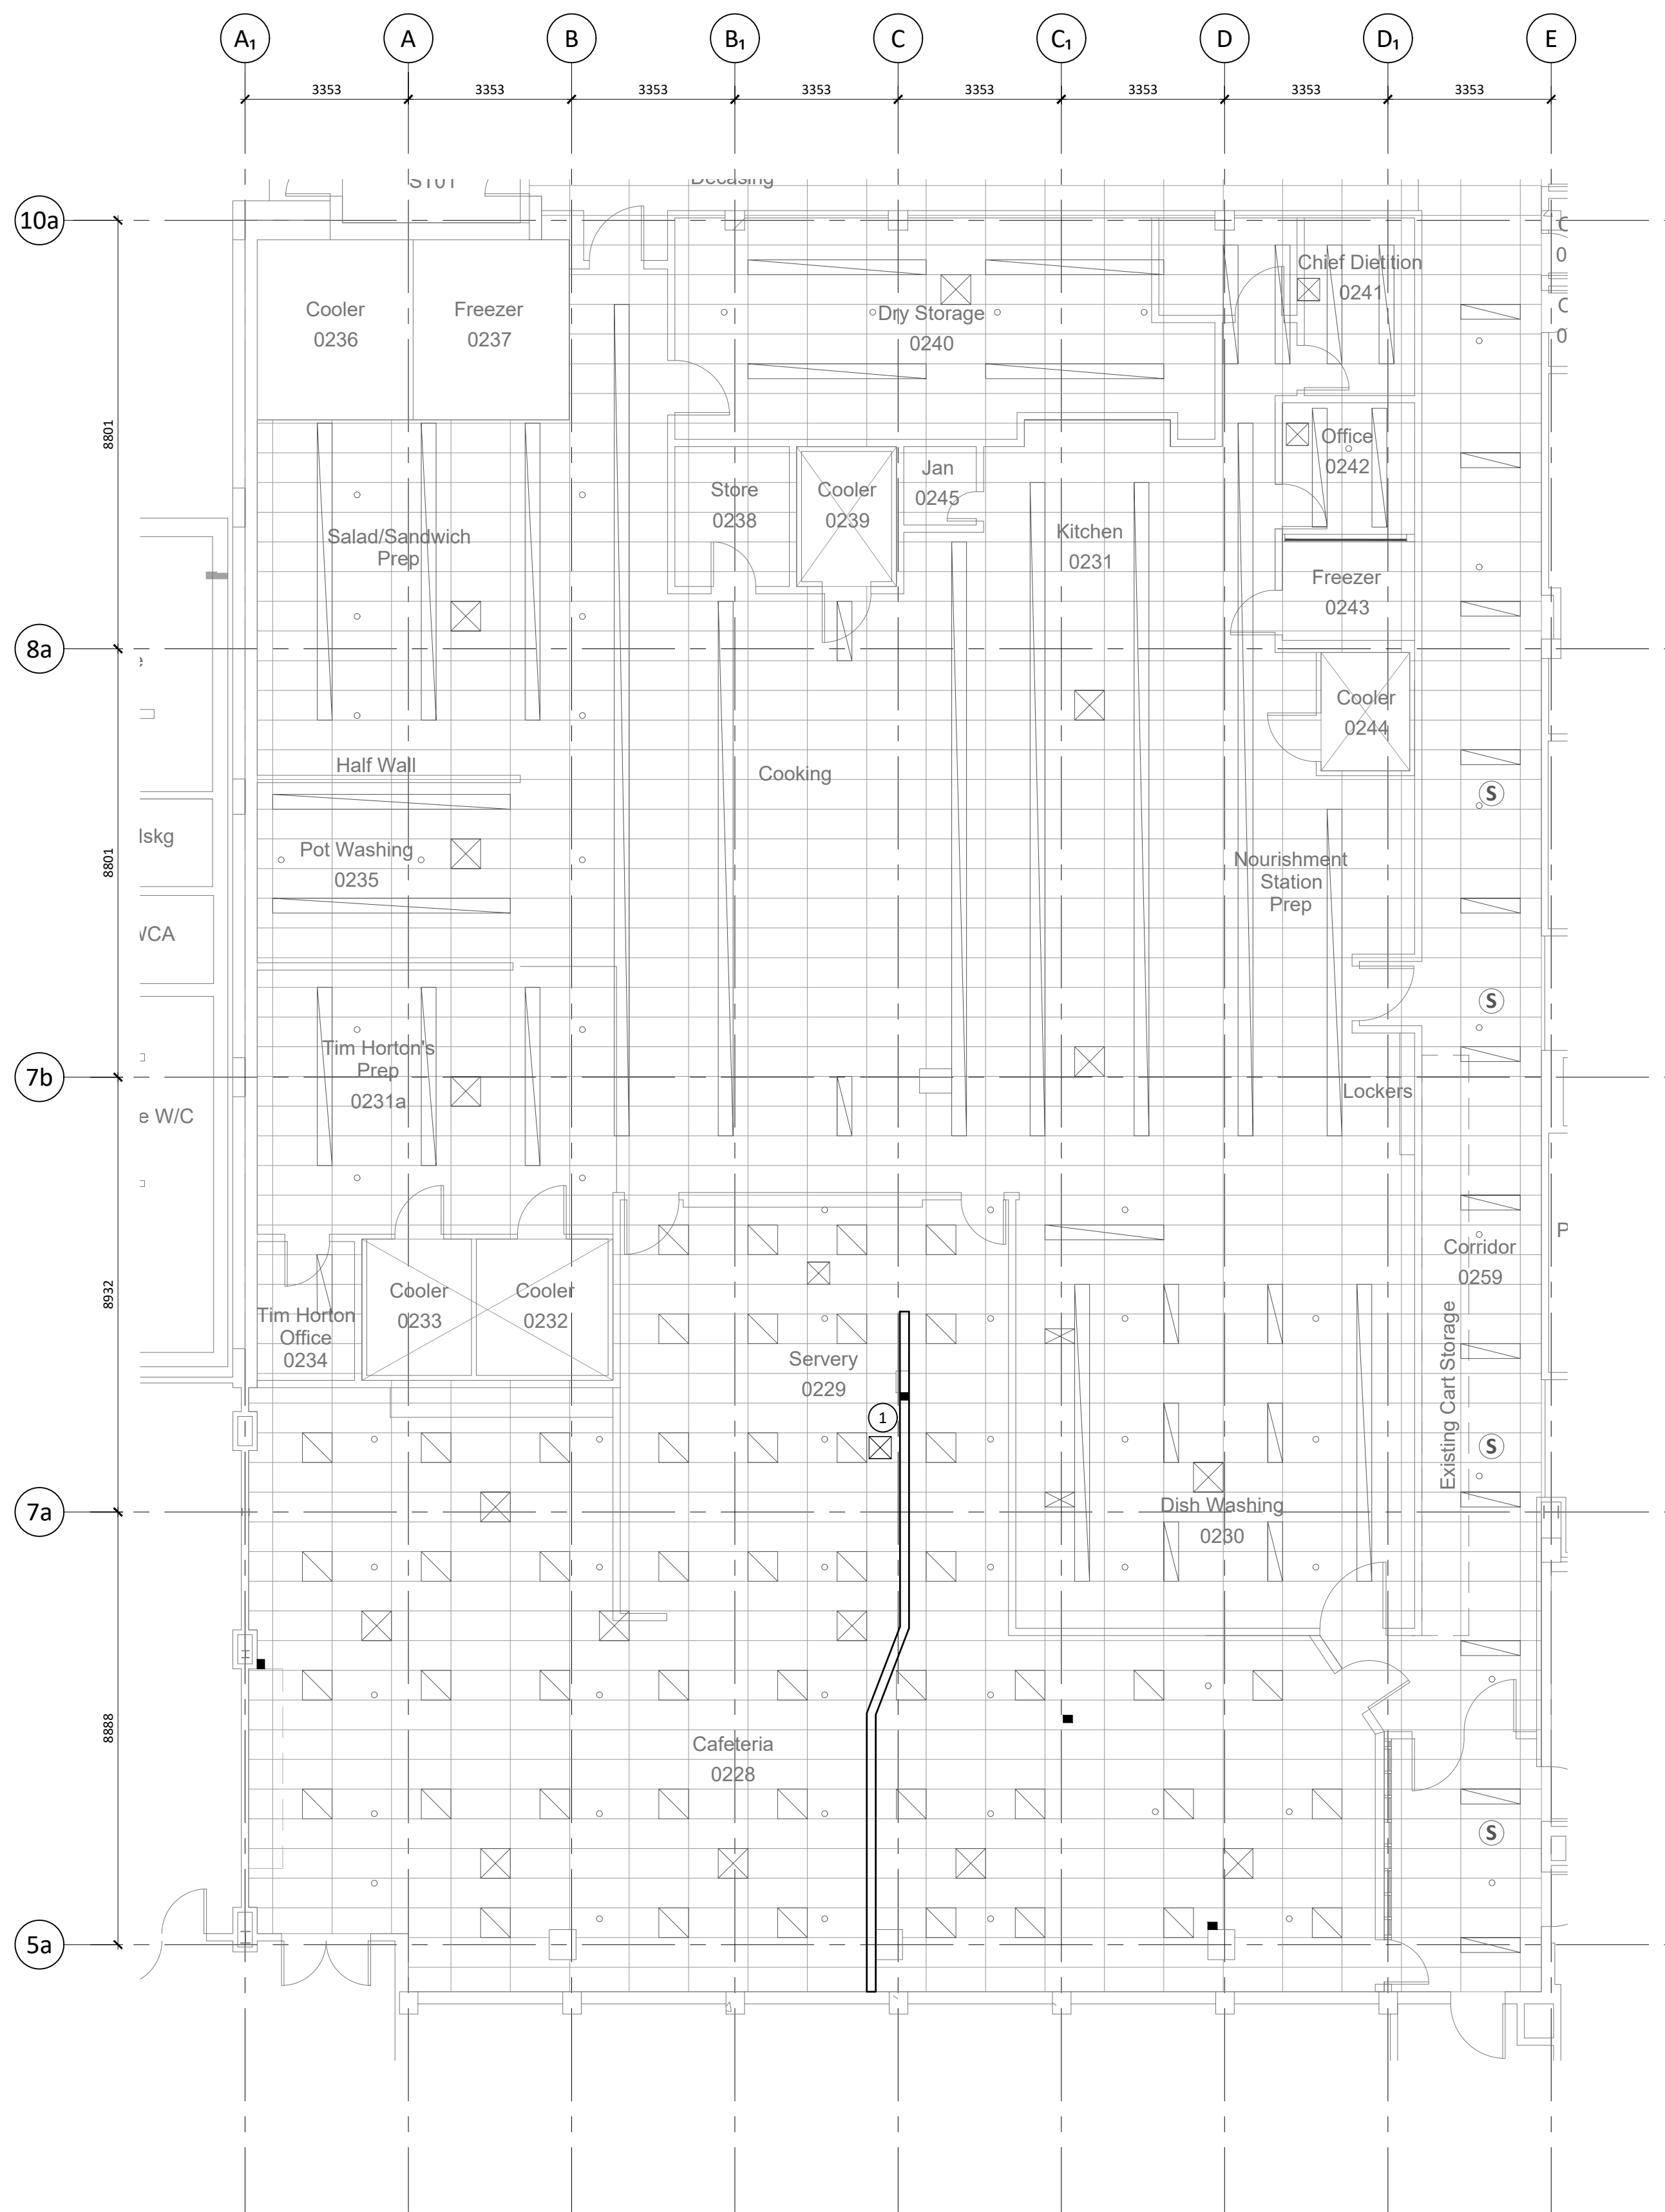

2 LEVEL 0 NEW RCP - PHASE 1
A210 1:100

REFLECTED CEILING PLAN LEGEND

- DUCT OPENING
- SOUND SYSTEM
- FLUORESCENT LIGHT FIXTURES
- SPRINKLERS
- DROP DOWN ELECTRICAL POWER SUPPLY. COORDINATE WITH ELECTRICAL


GENERAL NOTES

RE & RE CEILING AS REQUIRED TO ACCOMMODATE MECHANICAL & ELECTRICAL SERVICES

REFLECTED CEILING PLAN KEYNOTES

- TEMPORARY RELOCATE SUPPLY GRILLE TO ACCOMMODATE WITH TEMPORARY CORRIDOR. COORDINATE WITH MECHANICAL

KEY PLAN

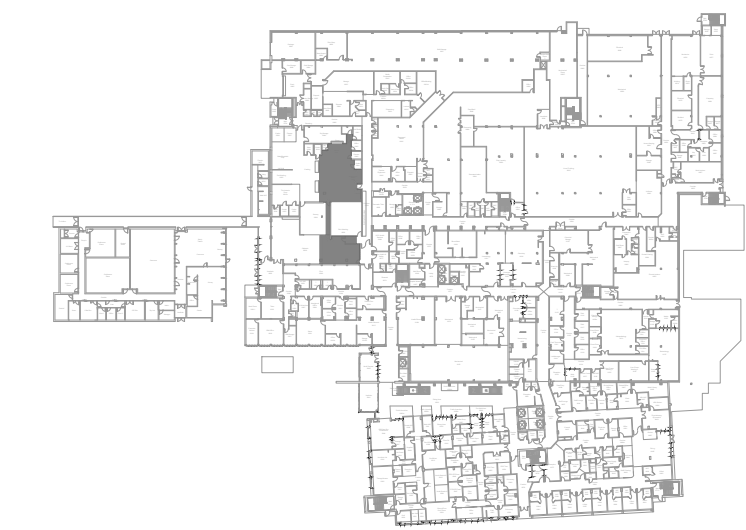

Copyright Reserved

This plan and design are the exclusive property of Thinkspace Architecture Inc. All rights reserved. No part of this drawing may be reproduced, stored in a retrieval system, or transmitted in any form or by any means, electronic, mechanical, photocopying, recording, or by any information storage and retrieval system, without the prior written consent of Thinkspace. This office shall be informed of any variations from the information shown on this drawing. Do not scale drawing.

Thinkspace, a partnership of:
Todd Duff, Architect ABC, AAA
Henk Kampman, Architect ABC, AAA
Ray Wolfe, Architect ABC

Issue Date: 2023-04-11

NO.	DATE	DESCRIPTION
1	2023-02-08	ISSUED FOR BID
2	2023-03-01	ISSUED FOR ADDENDUM 01
3	2023-03-09	ISSUED FOR BLDG. PERMIT
4	2023-04-11	ISSUED FOR CONSTRUCTION

*Sheet changes clouded and tagged respectively.

thinkspace 1963-2023 YEARS
architecture planning interior design ltd.


300 - 10190 152A St. | Surrey, BC | V3R 1J7
t 604.581.8128 | f 604.581.8148 | w thinkspace.ca

Project: **UHN TRAYLINE ASSEMBLY SYSTEM REPLACEMENT**
Drawing: 1475 EDMONTON STREET, PRINCE GEORGE, BC, V2M 1S2
Sheet Number: **A210**


NOTE1: LEVEL 0 REFLECTED CEILING PLAN - PHASE 1

NOTE2: LEVEL 0 REFLECTED CEILING PLAN - PHASE 1

Plot Date: 2023-02-08 File Path: I:\220937\pg-uhn-trayline-assembly-system-replacement\3.0 drawings\3.3 autocad\220937 - a210 level 0 reflected ceiling plan - phase 1.dwg

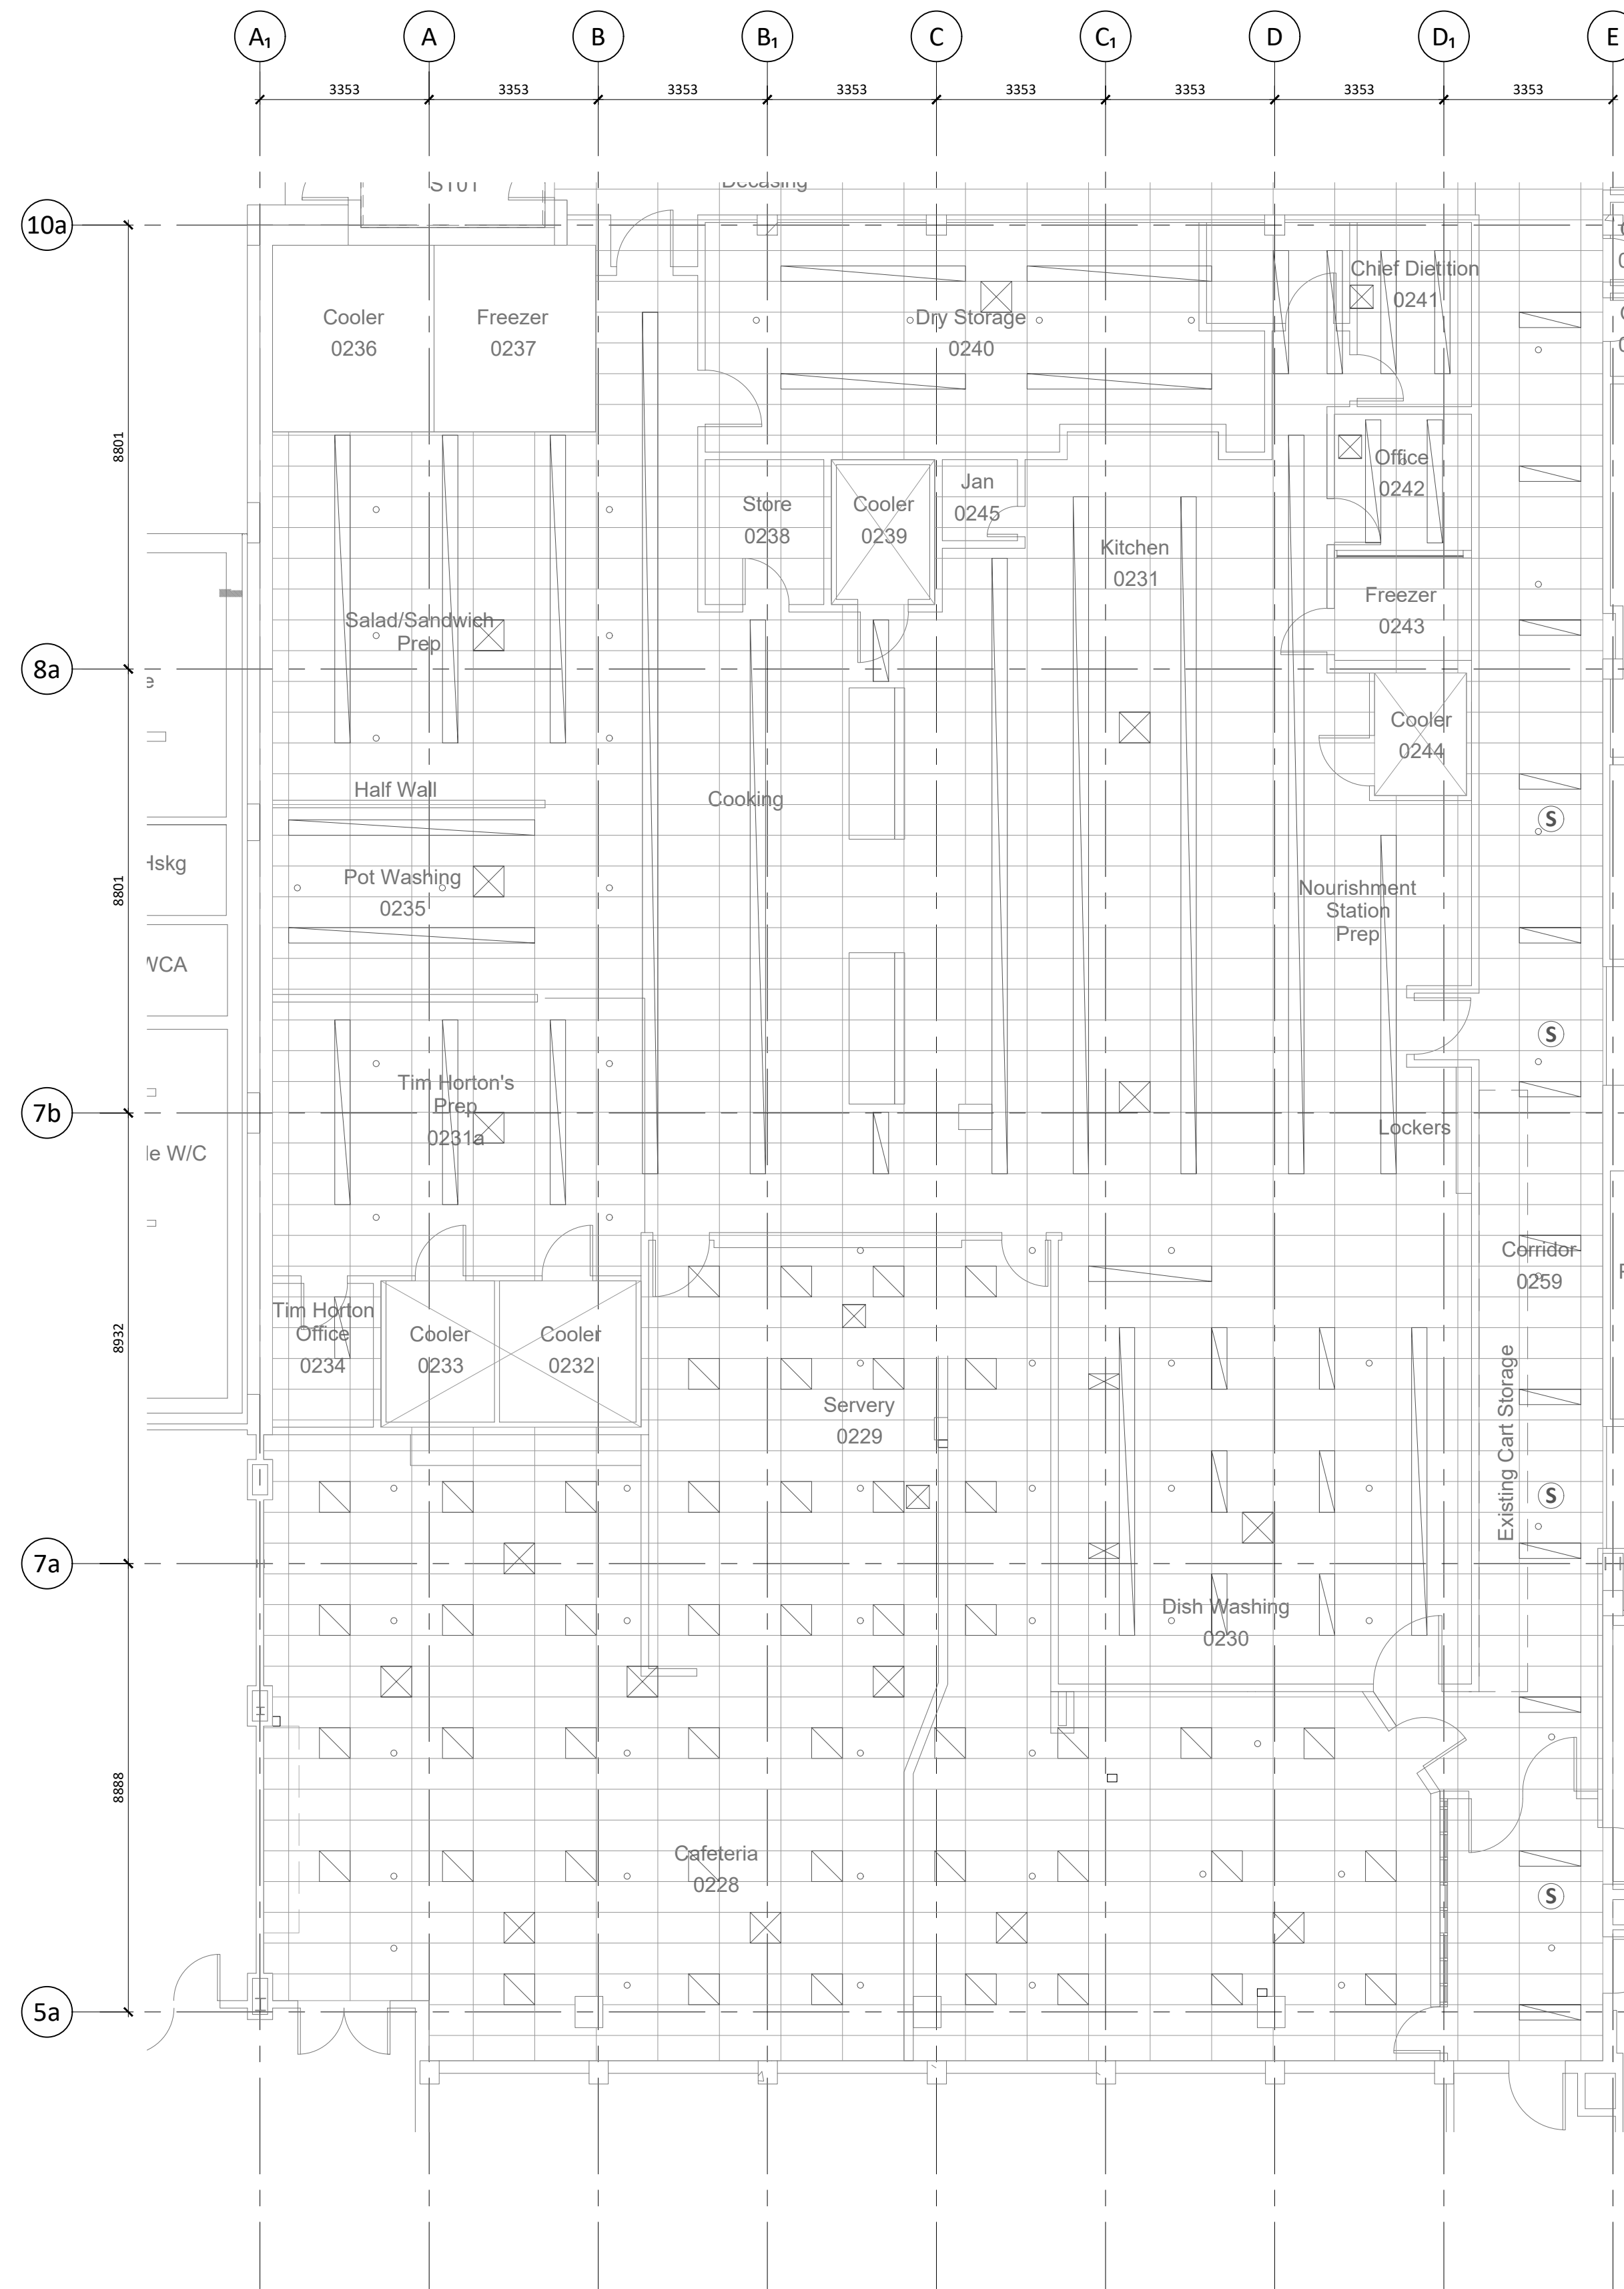


1 LEVEL 0 DEMO RCP - PHASE 2
A211 1:100

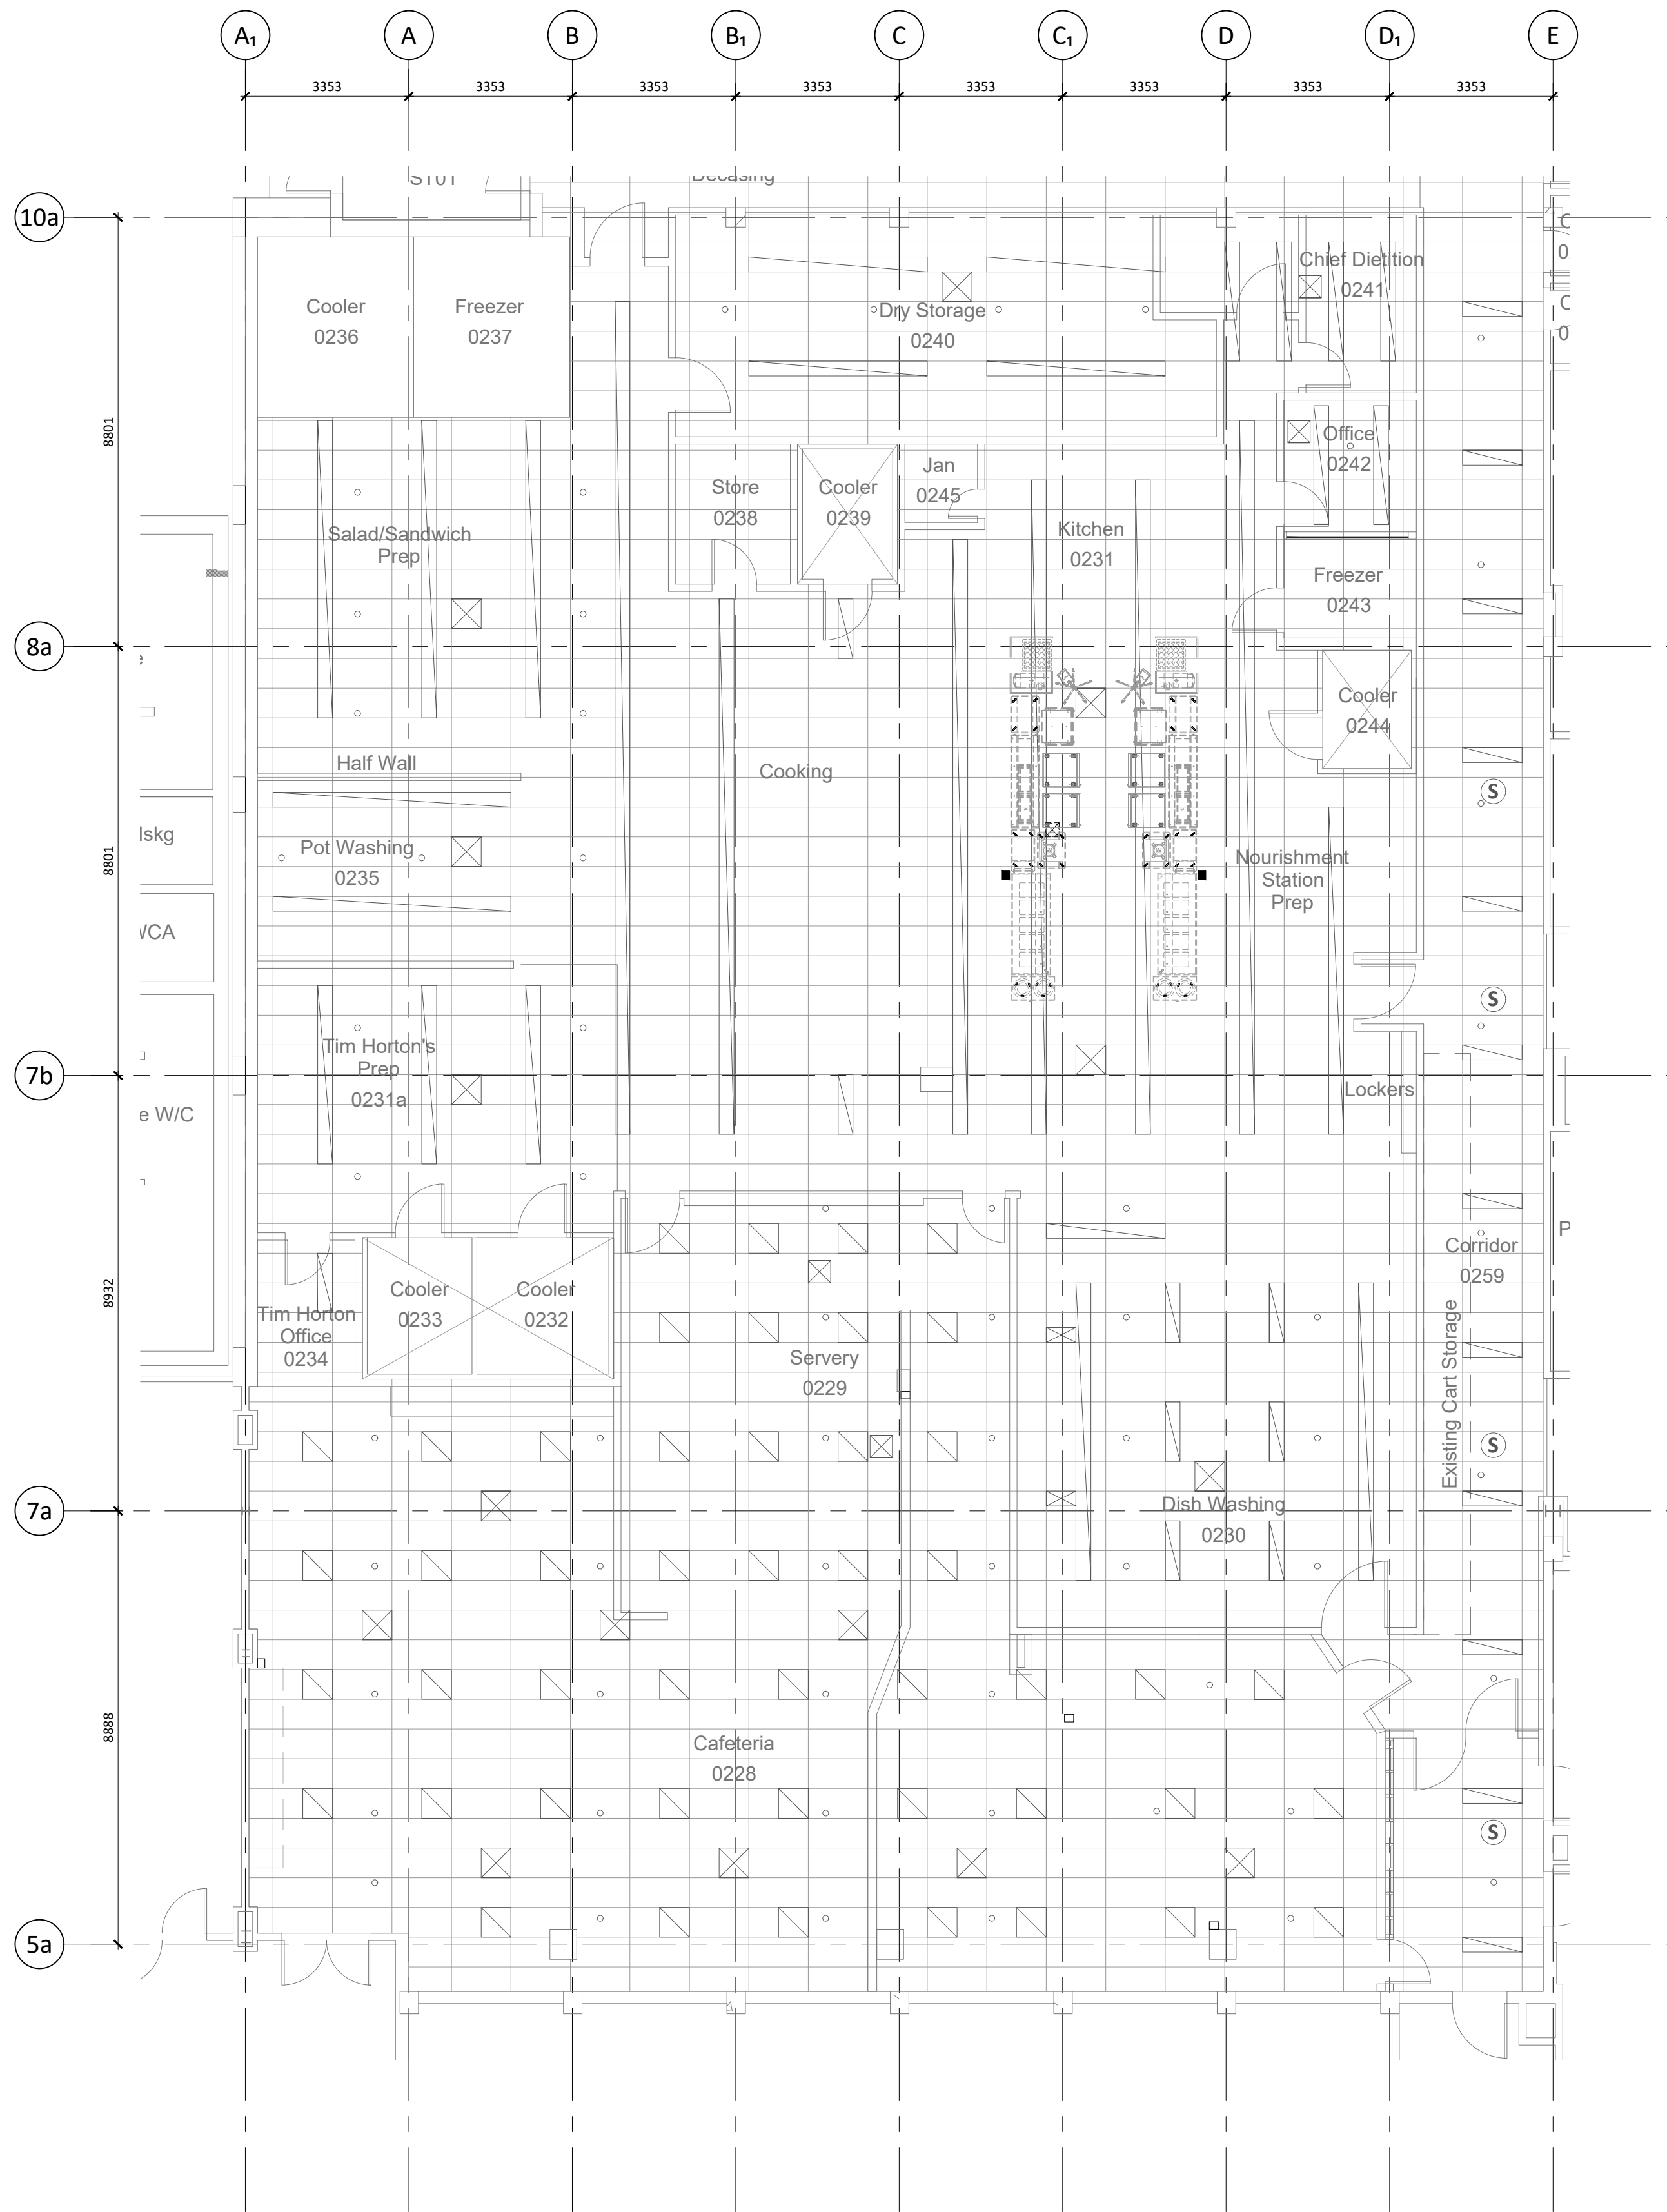

2 LEVEL 0 NEW RCP - PHASE 2
A211 1:100

- REFLECTED CEILING PLAN LEGEND**
- DUCT OPENING
 - SOUND SYSTEM
 - FLUORESCENT LIGHT FIXTURES
 - SPRINKLERS
 - DROP DOWN ELECTRICAL POWER SUPPLY. COORDINATE WITH ELECTRICAL

GENERAL NOTES
RE & RE CEILING AS REQUIRED TO ACCOMMODATE MECHANICAL & ELECTRICAL SERVICES

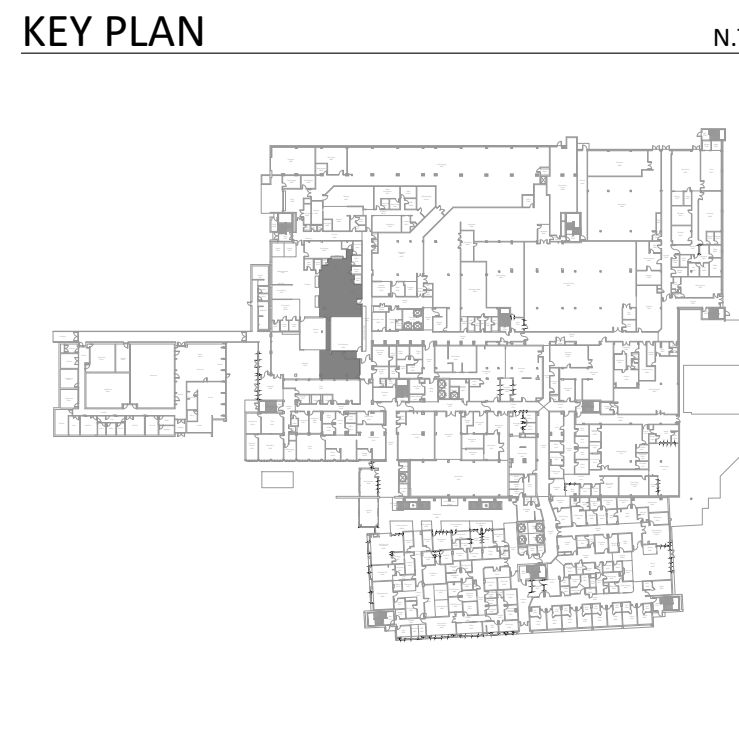

Copyright Reserved

This plan and design are the exclusive property of Thinkspace Architecture Inc. and shall not be reproduced, stored in a retrieval system, or transmitted in any form or by any means, electronic, mechanical, photocopying, recording, or by any information storage and retrieval system, without the prior written consent of Thinkspace. This office shall be informed of any variations from the information shown on this drawing. Do not scale drawing.

Thinkspace is a partnership of:
Todd Duff, Architect AIBC, AIA
Heidi Kampan, Architect AIBC, AIA
Ray Wolfe, Architect AIBC

Issue Date: 2023-04-11

NO.	DATE	DESCRIPTION
1	2023-02-08	ISSUED FOR BID
2	2023-03-01	ISSUED FOR ADDENDUM 01
3	2023-03-09	ISSUED FOR BLDG. PERMIT
4	2023-04-11	ISSUED FOR CONSTRUCTION

*Sheet changes clouded and tagged respectively.

thinkspace50
1963-2023 YEARS


architecture planning interior design ltd.

300 - 10190 152A St. | Surrey, BC | V3R 1J7
t 604.581.8128 | f 604.581.8148 | w thinkspace.ca


Project: **UHN TRAYLINE ASSEMBLY SYSTEM REPLACEMENT**
Drawing: 1475 EDMONTON STREET, PRINCE GEORGE, BC, V2M 1S2
Sheet Number: **A211**

NOTE1: LEVEL 0 REFLECTED CEILING PLAN - PHASE 2
NOTE2: LEVEL 0 REFLECTED CEILING PLAN - PHASE 2

Plot Date: 2023-02-08
File Path: I:\220937-ag-uhh-trayline-assembly-system-replacement\3.0-drawings\3.3-autocad\220937 - a211 level 0 reflected ceiling plan - phase 2.dwg

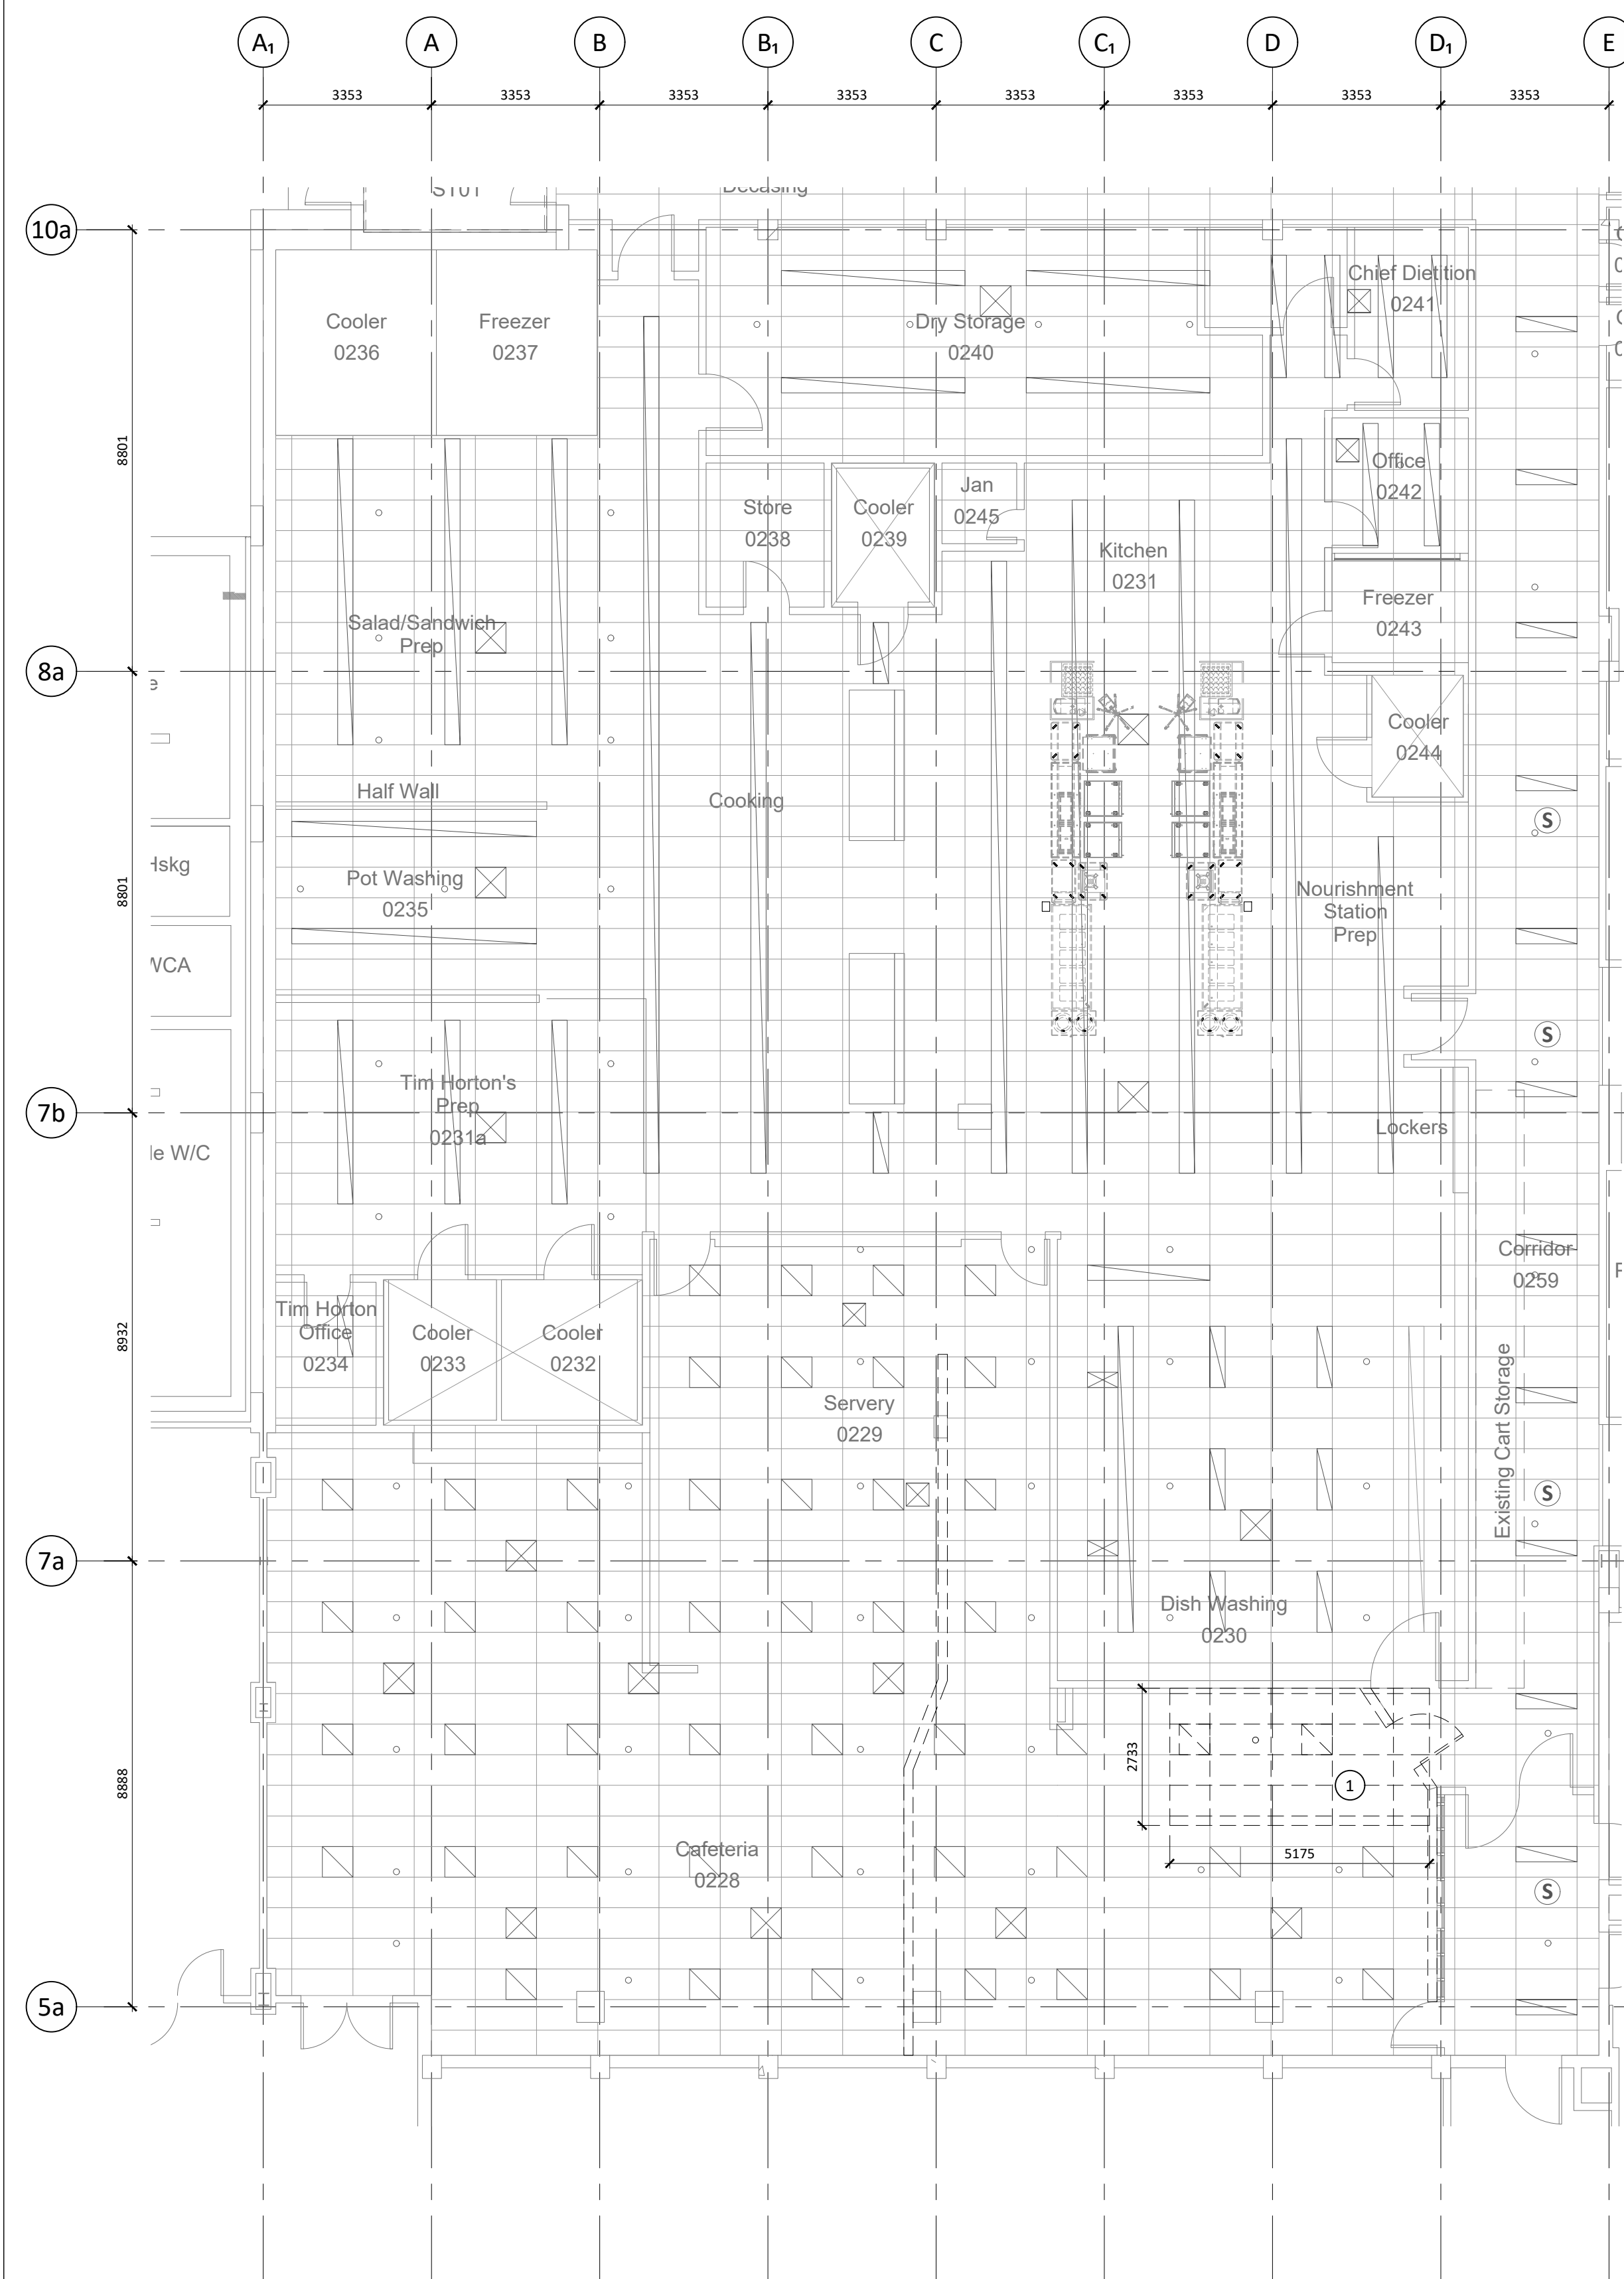

1 LEVEL 0 DEMO RCP - PHASE 3
A212 1:100

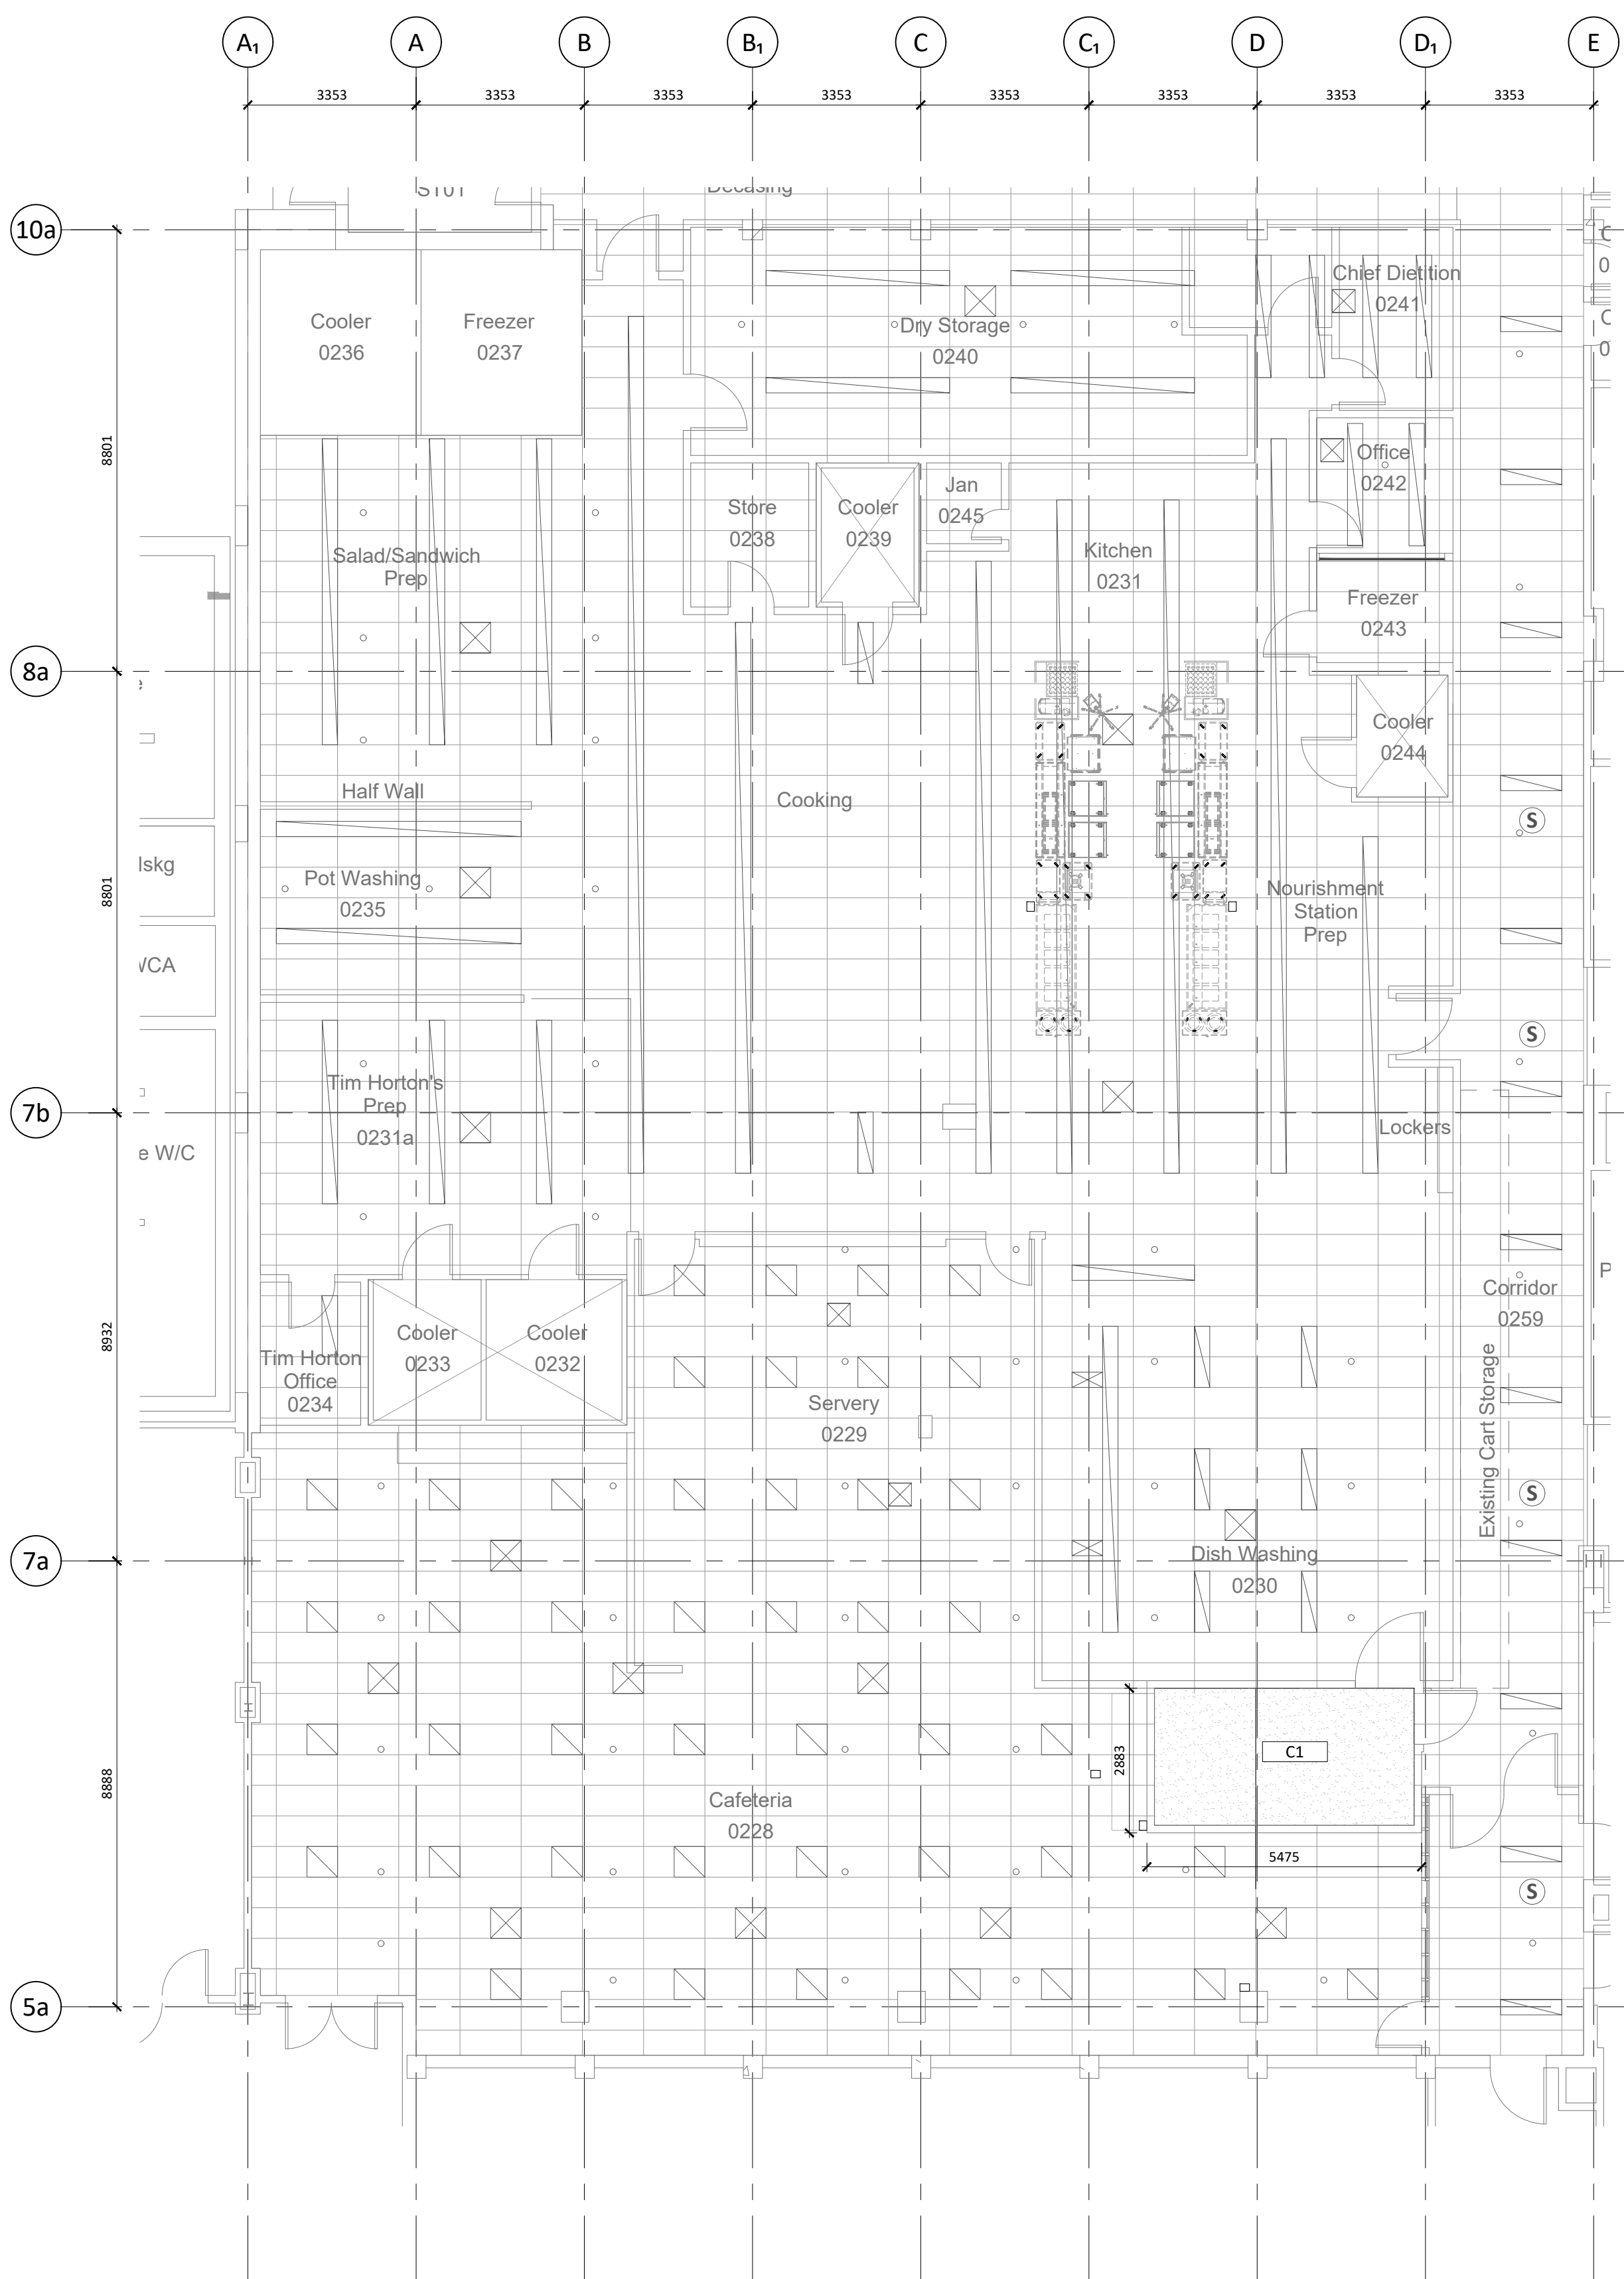

2 LEVEL 0 NEW RCP - PHASE 3
A212 1:100

REFLECTED CEILING PLAN LEGEND

- DUCT OPENING
- SOUND SYSTEM
- FLUORESCENT LIGHT FIXTURES
- SPRINKLERS
- DROP DOWN ELECTRICAL POWER SUPPLY


GENERAL NOTES

RE & RE CEILING AS REQUIRED TO ACCOMMODATE MECHANICAL & ELECTRICAL SERVICES

REFLECTED CEILING PLAN KEYNOTES

- DEMOLISH EXISTING T-BAR CEILING

KEY PLAN

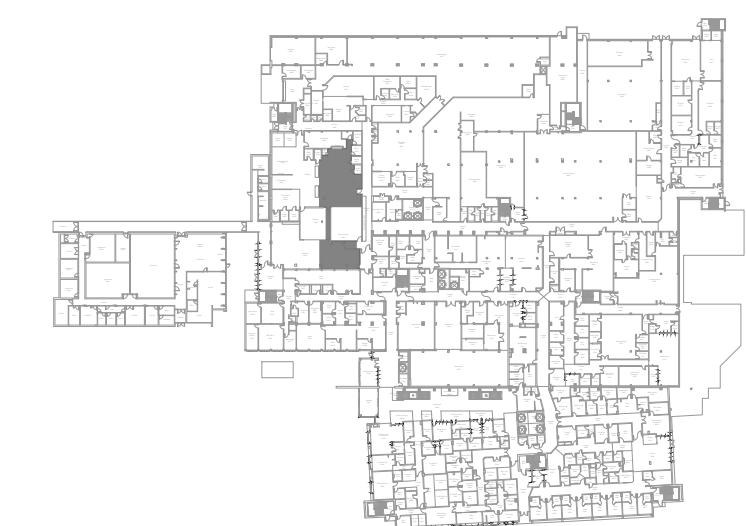

Copyright Reserved

This plan and design are the exclusive property of Thinkspace Architecture Inc. and shall not be reproduced, stored in a retrieval system, or transmitted in any form or by any means, electronic, mechanical, photocopying, recording, or by any information storage and retrieval system, without the prior written consent of Thinkspace. This office shall be informed of any variations from the information shown on this drawing. Do not scale drawing.

Thinkspace a partnership of:
Todd Duff, Architect AIBC, AIA
Henk Kampman, Architect AIBC, AIA
Ray Wolfe, Architect AIBC

Issue Date: 2023-04-11

NO.	DATE	DESCRIPTION
1	2023-02-08	ISSUED FOR BID
2	2023-03-01	ISSUED FOR ADDENDUM 01
3	2023-03-09	ISSUED FOR BLDG. PERMIT
4	2023-04-11	ISSUED FOR CONSTRUCTION

*Sheet changes clouded and tagged respectively.

thinkspace 1963-2023 YEARS
architecture planning interior design ltd.

300 - 10190 152A St. | Surrey, BC | V3R 1J7
t 604.581.8128 | f 604.581.8148 | w thinkspace.ca

Project: UHN TRAYLINE ASSEMBLY SYSTEM REPLACEMENT
Drawing: 1475 EDMONTON STREET, PRINCE GEORGE, BC, V2M 1S2
Sheet Number: 220937
LEVEL 0 REFLECTED CEILING PLAN - PHASE 3
A212
Plot Date: 2023-02-08
File Path: I:\220937 ag-uhh trayline assembly system replacement\3.0 drawings\3.3 autocad\220937 - 0212 level 0 reflected ceiling plan - phase 3.dwg

DOOR SCHEDULE

ID.	LOCATION	SIZE	TYPE AND MATERIAL			ULC	LIFE SAFETY HARDWARE										COMMENTS	
			AL - ALUMINUM HM - HOLLOW METAL HMI - HOLLOW METAL INSULATED SCW - SOLID CORE WOOD SCWL - SOLID CORE WOOD WITH LEAD LINING WD - WOOD PSF - PRESSED STEEL FRAME PSFT - PRESSED STEEL FRAME THERMALLY BROKEN			ULC RATING (MINUTES)	HARDWARE TYPE	PANIC HARDWARE - EXIT	PANIC HARDWARE - ENTER/EXIT	VERTICAL ROD DEVICE	ARM DEVICE	PUSH PLATES	PUSH/PULL	RECESSED DOOR PUSH & PUSH	EMERGENCY STRIKE	SMOKE SEAL GASTNETS	SECURITY PACKAGE	
			DOOR	FRAME	JAMB													
			TYPE	MATERIAL	TYPE	MATERIAL	TYPE											

BLOCK 1 - LEVEL 0

D0228A	CORRIDOR TO CAFETERIA	914x2130	D1	Hmi	F1	PSF	J1		INT1									USE SALVAGED ELECTRIC STRIKE, DOOR OPERATOR, STORE ROOM LOCKSET
D0228B	CORRIDOR TO CAFETERIA	914x2130	D1	Hmi	F1	PSF	J1		INT1									
D0230A	DIRTY CART TO DISHWASH	914x2130	D1	Hmi	F1	PSF	J1		INT1									USE SALVAGED ELECTRIC STRIKE, DOOR OPERATOR, STORE ROOM LOCKSET

DOOR SCHEDULE NOTES:


- 1) COORDINATE WITH MECHANICAL REQUIREMENTS FOR DOOR GRILLES, UNDERCUTS, ETC.

UHN TRAYLINE					Project Number: 220937					DATE: 08/02/2023				
1475 EDMONTON STREET, PRINCE GEORGE, BC, V2M 1S2										Issued for Bid				
TAG	MATERIAL	SPECIFICATION	LOCATIONS		SUPPLIER		NOTES							
FLOOR FINISHES														
RF-1	Resilient Sheet Flooring	MANUFACTURER: Tarkett PRODUCT NAME: Safetred Universal Plus CODE: COLOUR: INSTALLATION:	Refer to Finish Plans		SUPPLIER: CONTACT: TEL: EMAIL:									
EP-1	Epoxy Flooring	MANUFACTURER: Stonhard PRODUCT NAME: Stonclad UT CODE: COLOUR: INSTALLATION:			SUPPLIER: CONTACT: TEL: EMAIL:		Refer to alternate price							
TRANSITION STRIPS, TRIMS & STAIRS														
CG-1	Corner Guard	MANUFACTURER: Construction Specialties PRODUCT NAME: Heavy Duty Corner Guards SIZE: FINISH:	Refer to Finish Plans		SUPPLIER: CONTACT: TEL: EMAIL:		Trim to be used at all exposed outside corners							
WALL FINISHES														
PT-1	Paint Finish	MANUFACTURER: Dulux PRODUCT NAME: Enduring Ice CODE: FINISH: DLX1102-1 Refer to spec	Paint finish throughout Refer to Finish Plans		SUPPLIER: CONTACT: TEL: EMAIL:		Low VOC All walls and ceilings to be painted PT-1 unless otherwise noted.							
WP-1	Wall Protection	MANUFACTURER: Altro PRODUCT NAME: Altro Whiterock FT41 CODE: FINISH: Textured Pearl	Refer to Finish Plans		SUPPLIER: CONTACT: TEL: EMAIL:									
WALL BASE FINISHES														
RB-1	Integral Flash Cove Base	MANUFACTURER: Stonhard PRODUCT NAME: Stonclad UT SIZE: FINISH: INSTALLATION:	Refer to Finish Plans		SUPPLIER: CONTACT: TEL: EMAIL:									
RB-2	Rubber Cove Base	MANUFACTURER: PRODUCT NAME: SIZE: 152mm FINISH: INSTALLATION: VCT to match, as closely as possible, the existing adjacent flooring. Contractor to allow for 2 colours.	Refer to Finish Plans		SUPPLIER: CONTACT: TEL: EMAIL:									
CEILING FINISHES														
GB-1	Dropped Drywall Ceiling	MANUFACTURER: PRODUCT NAME: COLOUR: INSTALLATION:	Refer to Reflected Ceiling Plans		SUPPLIER: CONTACT: TEL: EMAIL:									
MILLWORK FINISHES														
PL-1	Plastic Laminate	MANUFACTURER: PRODUCT NAME: CODE: COLOUR:	Countertops Refer to Finish Plans and Interior Elevations		SUPPLIER: CONTACT: TEL: EMAIL:									
SS-1	Stainless Steel	MANUFACTURER: PRODUCT NAME: CODE: COLOUR: NOTE: T304 Stainless Steel with a #4 finish unless noted otherwise	Countertops Refer to Finish Plans and Interior Elevations		SUPPLIER: CONTACT: TEL: EMAIL:									
INTERIOR GLAZING														
GF-1	Glazing Film	MANUFACTURER: PRODUCT NAME: SERIES: FINISH: INSTALLATION:	Refer to Finish Plans and Interior Elevations		SUPPLIER: CONTACT: TEL: EMAIL:									


HARDWARE SCHEDULE

ID.	DESCRIPTION	ID.	DESCRIPTION
INT 1	ELEC/MECH/STORAGE DOUBLE DOOR TYPE: 3 HINGES ELECTRICAL STRIKE CARD READER (CORRIDOR SIDE) STORE ROOM LOCKSET AUTOMATIC DOOR OPERATOR		


DOOR TYPES

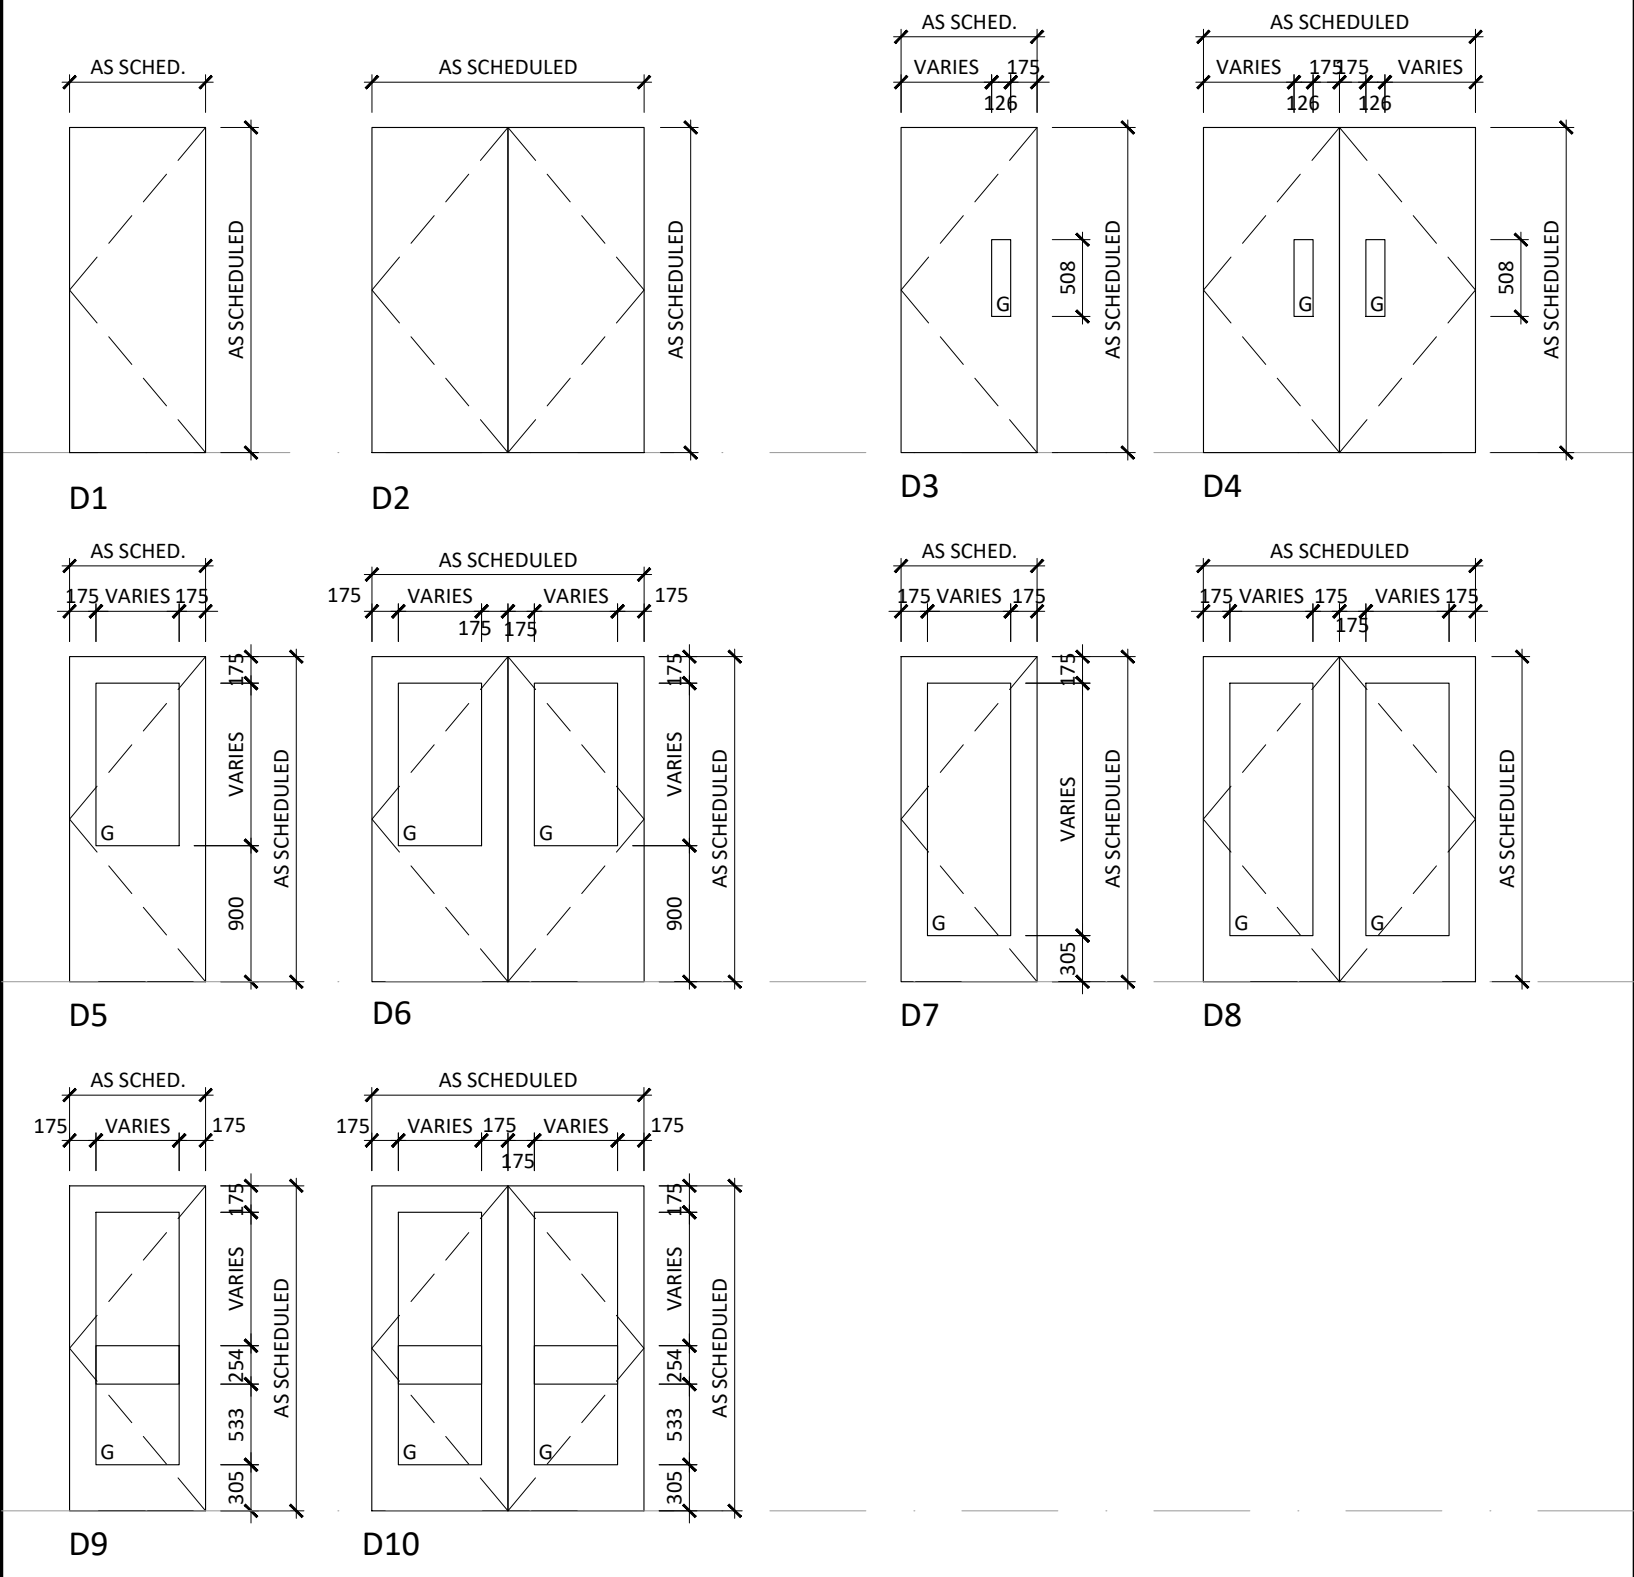

FRAME TYPES

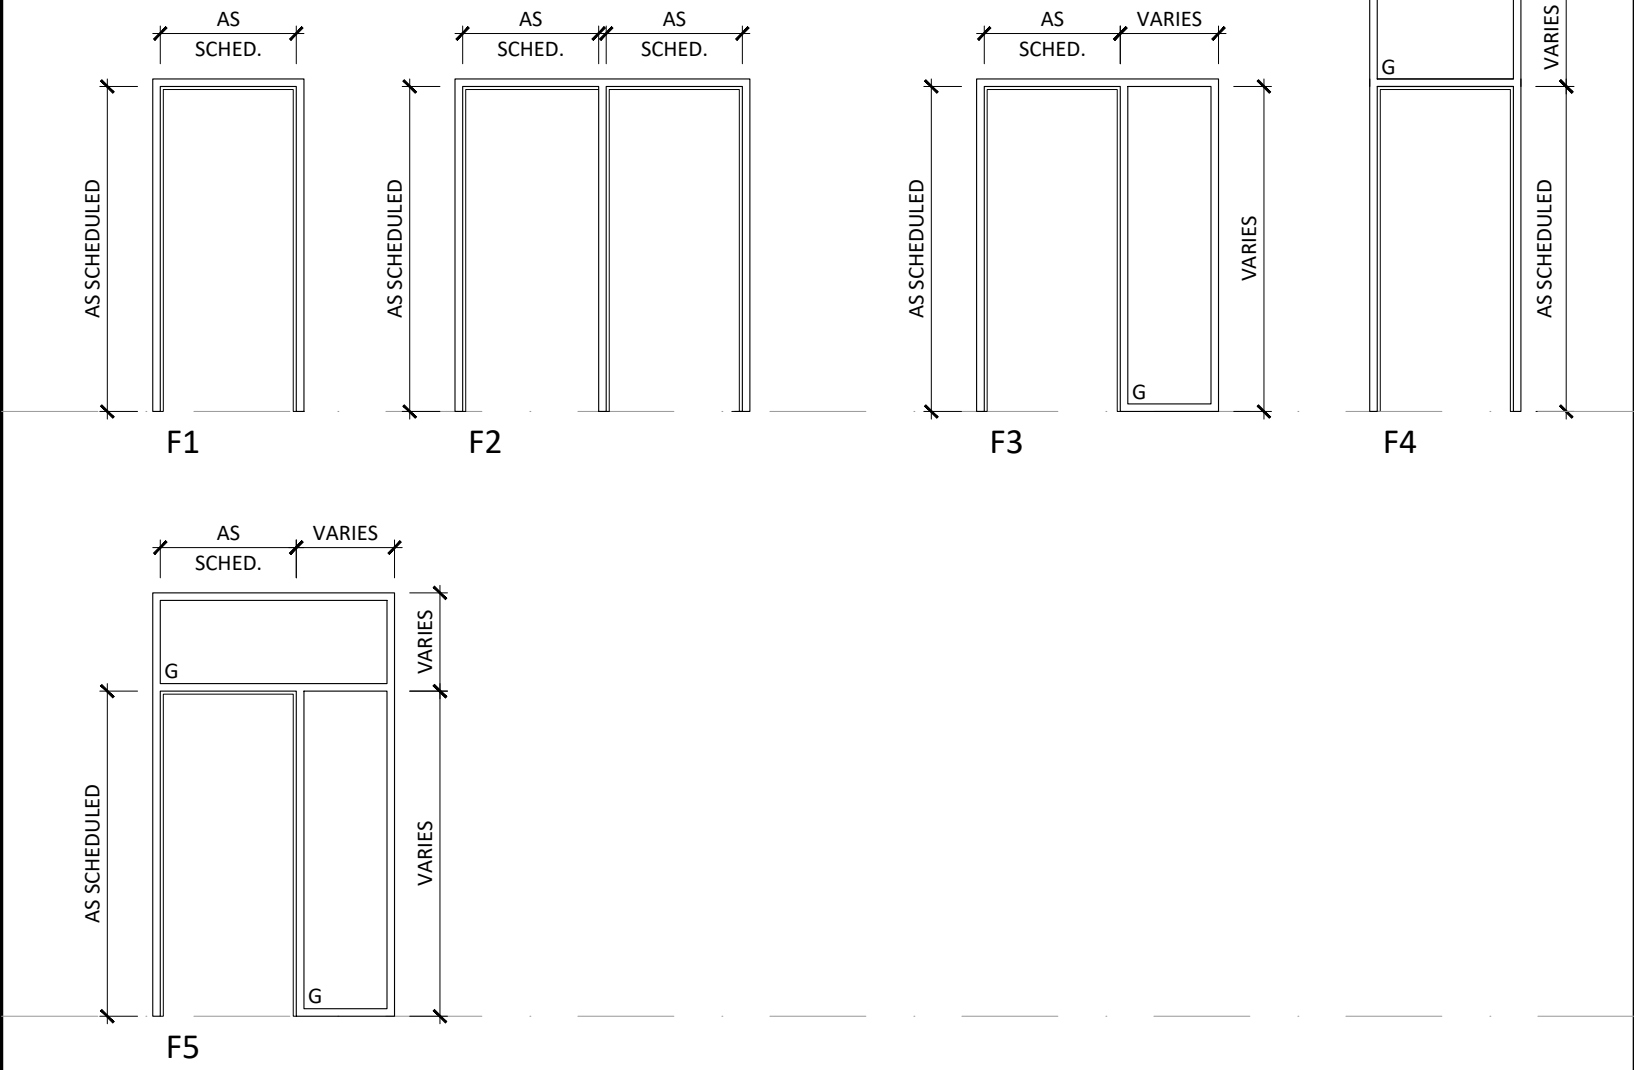

JAMB TYPES

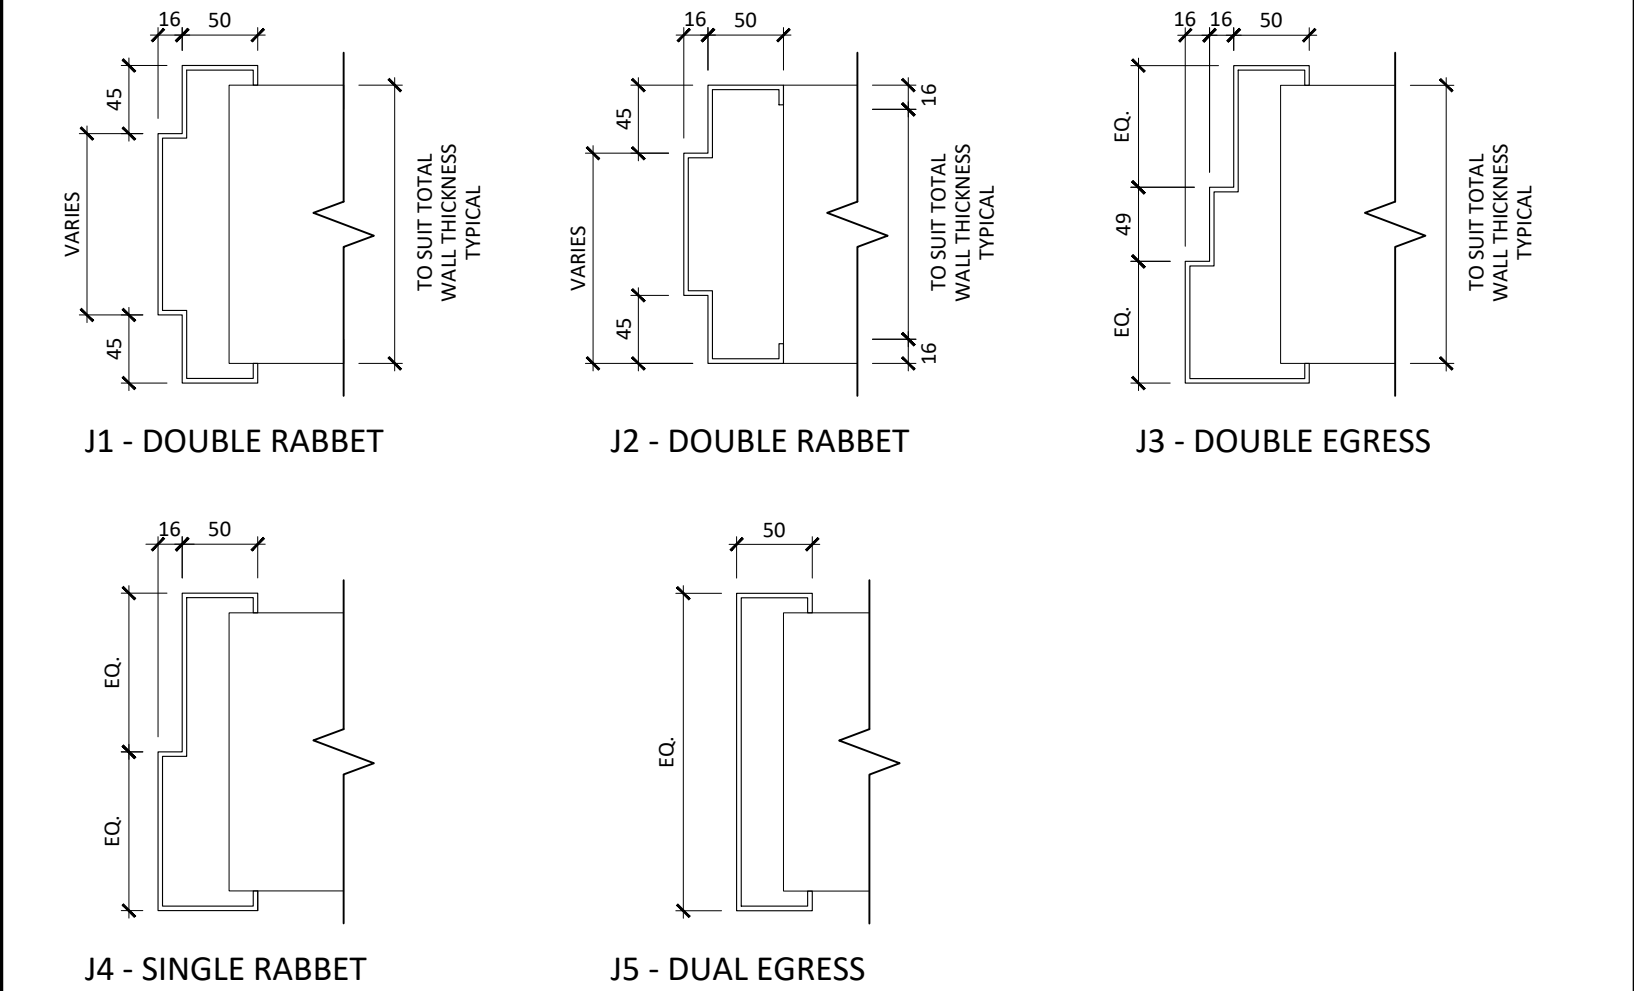

Copyright reserved
This plan and design are the exclusive property of
Thinkspace Architecture Planning Interior Design
© 2023. All rights reserved. No part of this
document may be reproduced without the
written consent of Thinkspace. This office shall be
informed of any variations from the information shown
on this drawing. Do not start drawings.

Issue Date: 2023-04-11
Issued For
CONSTRUCTION
GLOBAL REVISIONS LIST
NO. DATE DESCRIPTION
1 2023-02-08 ISSUED FOR BID
2 2023-03-01 ISSUED FOR ADDENDUM 01
3 2023-03-09 ISSUED FOR BLDG. PERMIT
4 2023-04-11 ISSUED FOR CONSTRUCTION

Thinkspace: a partnership of:
Todd Dutt, Architect AIBC, AAA
Henk Kampman, Architect AIBC, AAA
Ray Wolfe, Architect AIBC

*Sheet changes clouded and tagged respectively.

thinkspace60
1963-2023 YEARS
architecture planning interior design ltd.
300 - 10190 152A St. | Surrey, BC | V3R 1J7
t 604.581.8128 | f 604.581.8148 | w thinkspace.ca

Project
UHN TRAYLINE ASSEMBLY SYSTEM
REPLACEMENT

Project Number
220937

Drawing
SCHEDULES



Sheet Number
A750

NOTE1

NOTE2

Plot Date: 2023-02-08

File Path: I:\220937 pg-uhn trayline assembly system replacement\3.0 drawings\3.3 autocad\220937 - s750 schedules.dwg

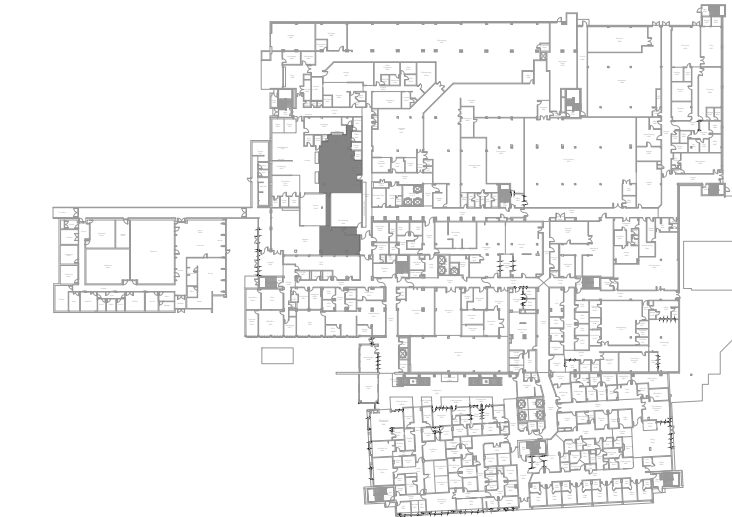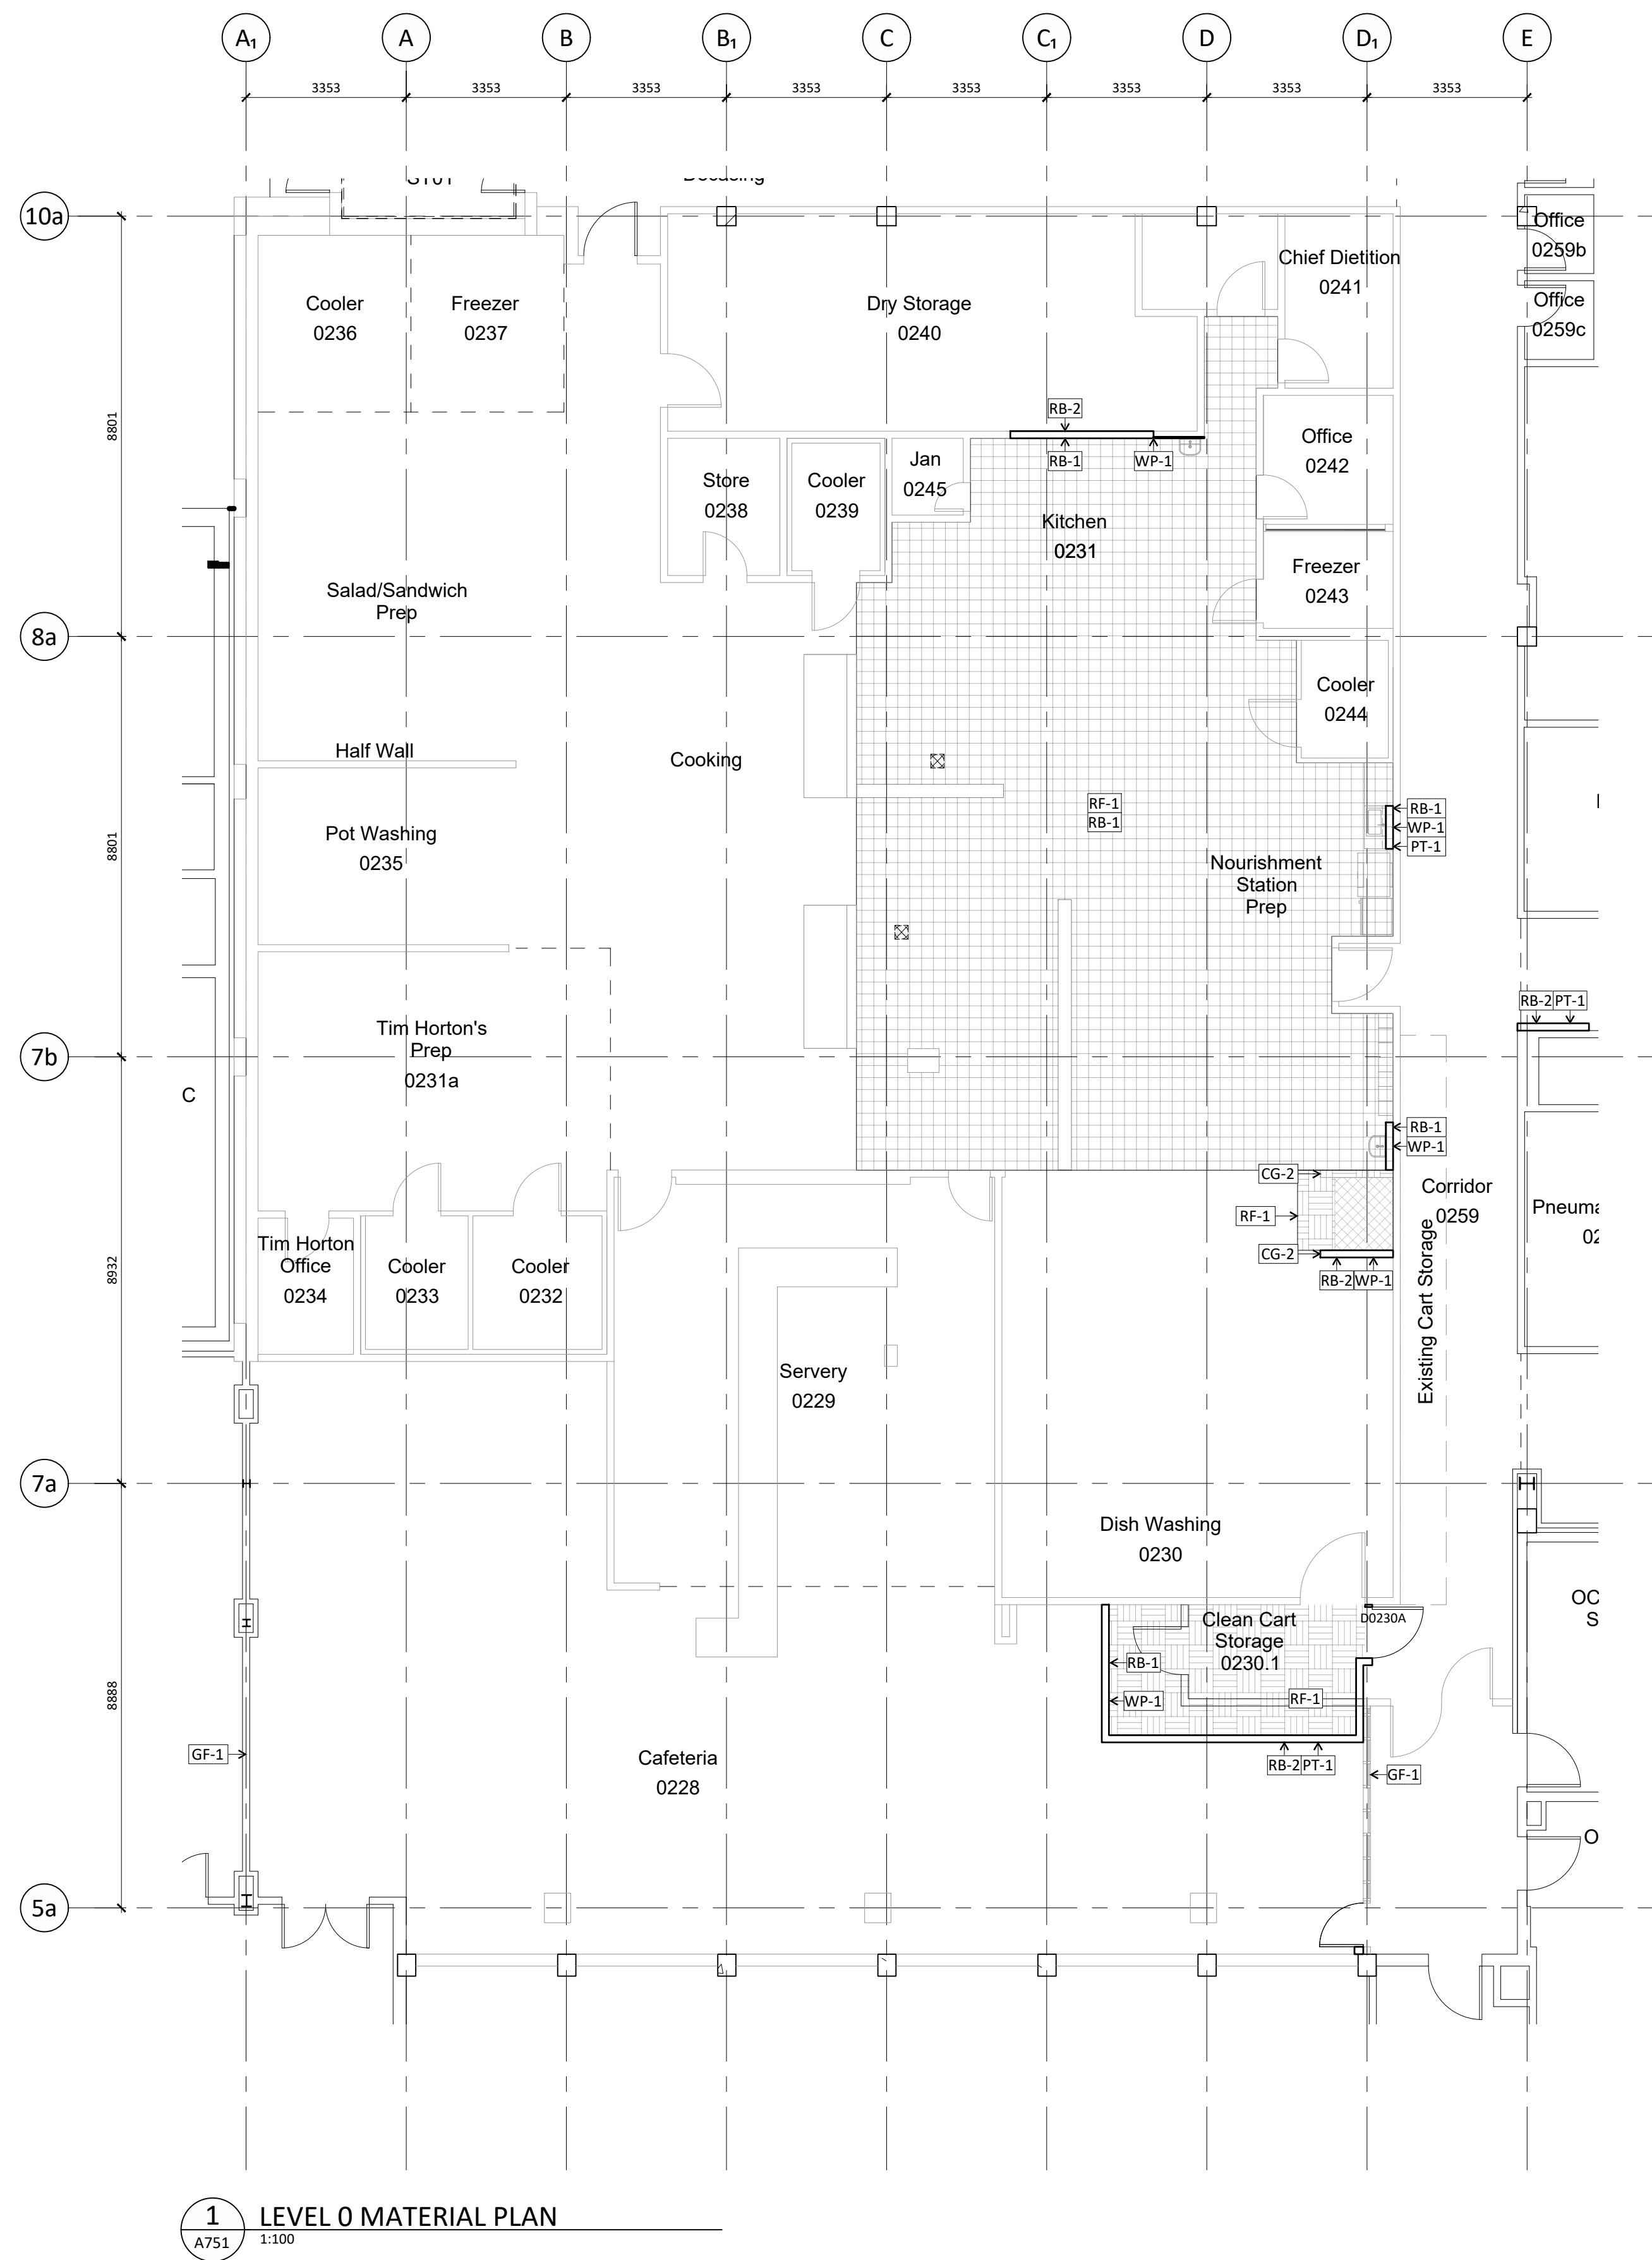

KEY PLAN N.T.S.

FLOOR PLAN KEYNOTES

FLOOR PLAN LEGEND

NEW PARTITION

EXISTING PARTITION

EXIT SIGNAGE

AD - AREA DRAIN

FD - FLOOR DRAIN

RD - ROOF DRAIN

RAIN WATER LEADER

EXISTING FLOOR DRAIN

DEMOLISHED PARTITION

- FLOOR PLAN GENERAL NOTES**
- REPAIR AND LEVEL ALL FLOOR SUBSTRATES IN PREPARATION FOR INSTALLATION OF NEW FLOORING FINISHES AS REQUIRED.
 - THE CONTRACTOR IS TO SUBMIT ALL FINISH SAMPLES TO THE ARCHITECT FOR REVIEW PRIOR TO INSTALLATION.

Project: **UHN TRAYLINE ASSEMBLY SYSTEM REPLACEMENT**

1475 EDMONTON STREET, PRINCE GEORGE, BC, V2M 1S2

Drawing: **LEVEL 0 MATERIAL PLAN**

Sheet Number: **A751**

Plot Date: 2023-02-08

File Path: I:\220937_uhn-trayline-assembly-system-replacement\3.0-drawings\3.3-autocad\220937 - 0751 level 0 material plan.dwg

Issue Date: 2023-04-11

NO.	DATE	DESCRIPTION
1	2023-02-08	ISSUED FOR BID
2	2023-03-01	ISSUED FOR ADDENDUM 01
3	2023-03-09	ISSUED FOR BLDG. PERMIT
4	2023-04-11	ISSUED FOR CONSTRUCTION

Copyright Reserved

This plan and design are the exclusive property of Thinkspace Architecture & Planning, Interior Design (Thinkspace). No part of this drawing may be reproduced, stored in a retrieval system, or transmitted in any form or by any means, electronic, mechanical, photocopying, recording, or by any information storage and retrieval system, without the prior written consent of Thinkspace. This office shall be informed of any variations from the information shown on this drawing. Do not scale drawing.

Thinkspace is a partnership of:
Todd Duff, Architect ABC, AAA
Heidi Kampman, Architect ABC, AAA
Ray Wolfe, Architect ABC

thinkspace 1963-2023 YEARS

architecture planning interior design ltd.

300 - 10190 152A St. | Surrey, BC | V3R 1J7

t 604.581.8128 | f 604.581.8148 | w thinkspace.ca



Project Number	220937	Project	UHN TRAYLINE ASSEMBLY SYSTEM REPLACEMENT	NOTE1	 1963-2023 YEARS architecture planning interior design ltd. 300 - 10190 152A St. Surrey, BC V3R 1J7 t 604.581.8128 f 604.581.8148 w.thinkspace.ca
Sheet Number	A850	Drawing	MILLWORK DETAILS	NOTE2	


File Path: L:\220937-ue-uh-trayline assembly system replacement\3.0 drawings\3.3 autocad\220937_a850 millwork details.dwg

Print Date: 2023-02-08

Copyright Reserved

This plan and design are the exclusive property of **Thinkspace Architecture® Planning Interior Design** and cannot be used or reproduced without written consent of **Thinkspace**. This office shall be informed of any variations from the information shown on this drawing. Do not scale drawings.


Thinkspace, a partnership of:
David Lee Blanchard, Architect ABC, AAA
Todd Dust, Architect ABC, AAA
Henk Kampman, Architect ABC, AAA
Ray Wolfe, Architect ABC

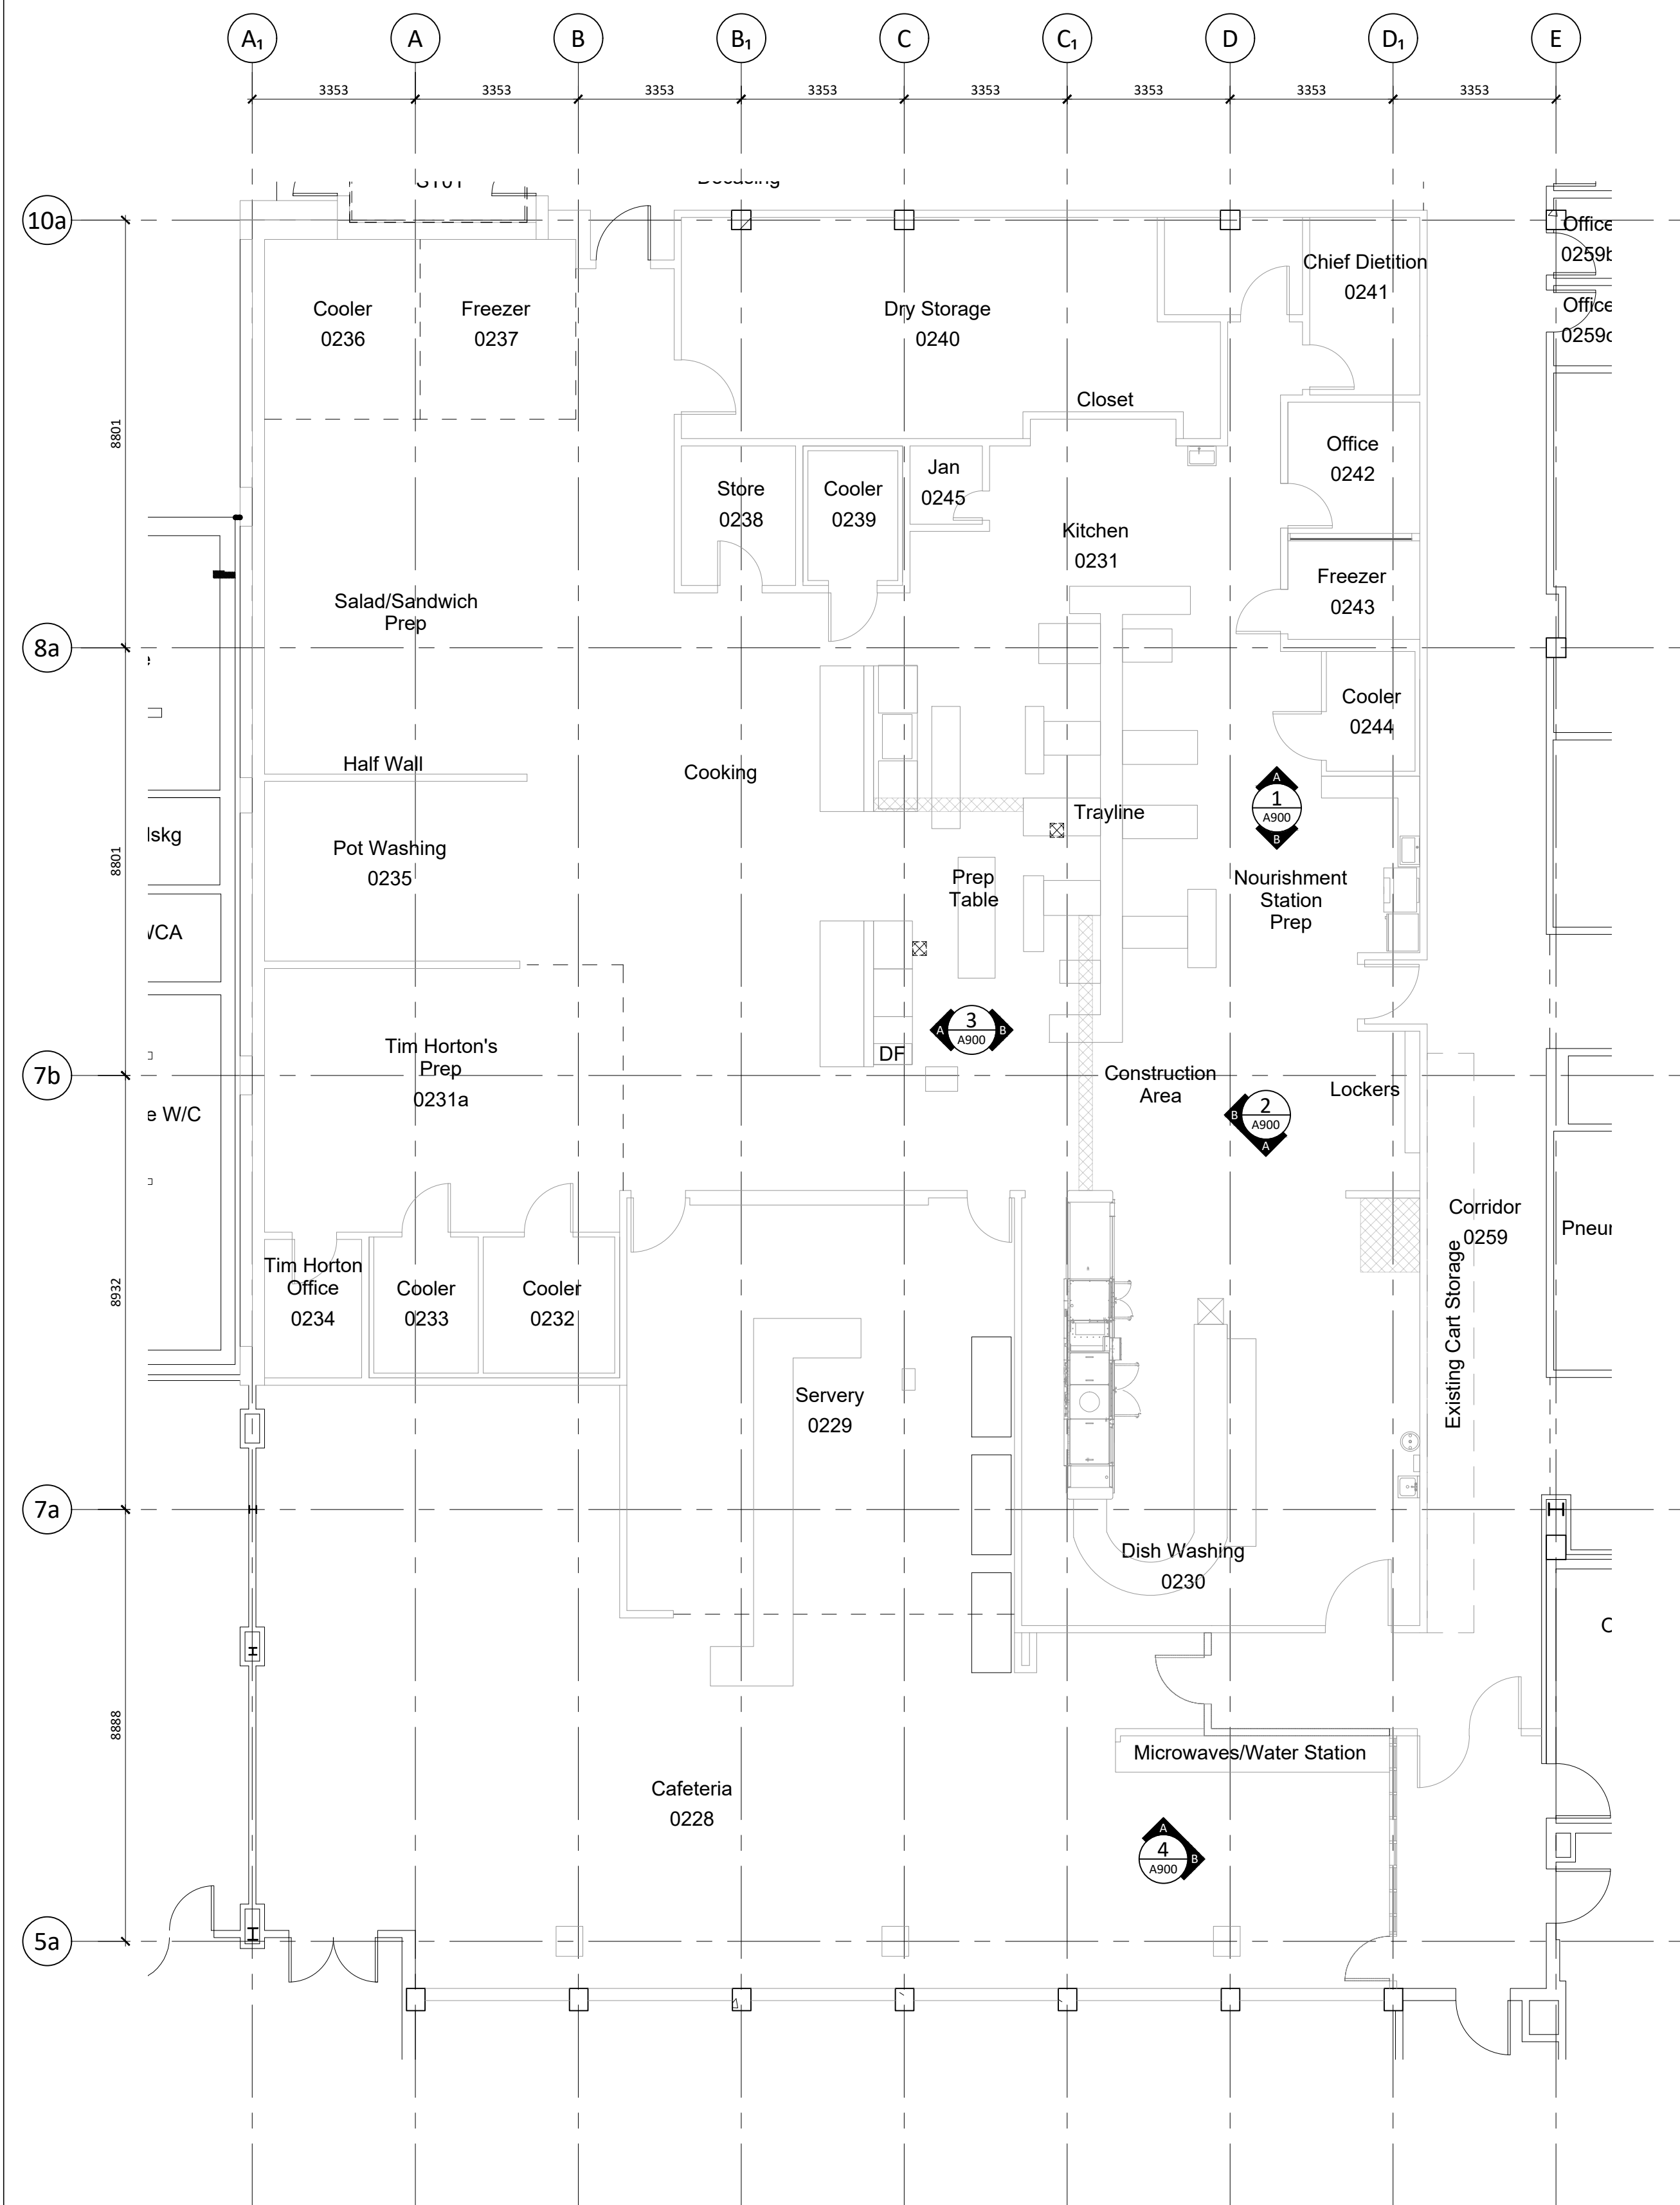

1 LEVEL 0 PHOTO REFERENCES
A900 1:100



1 PHOTO A
A900

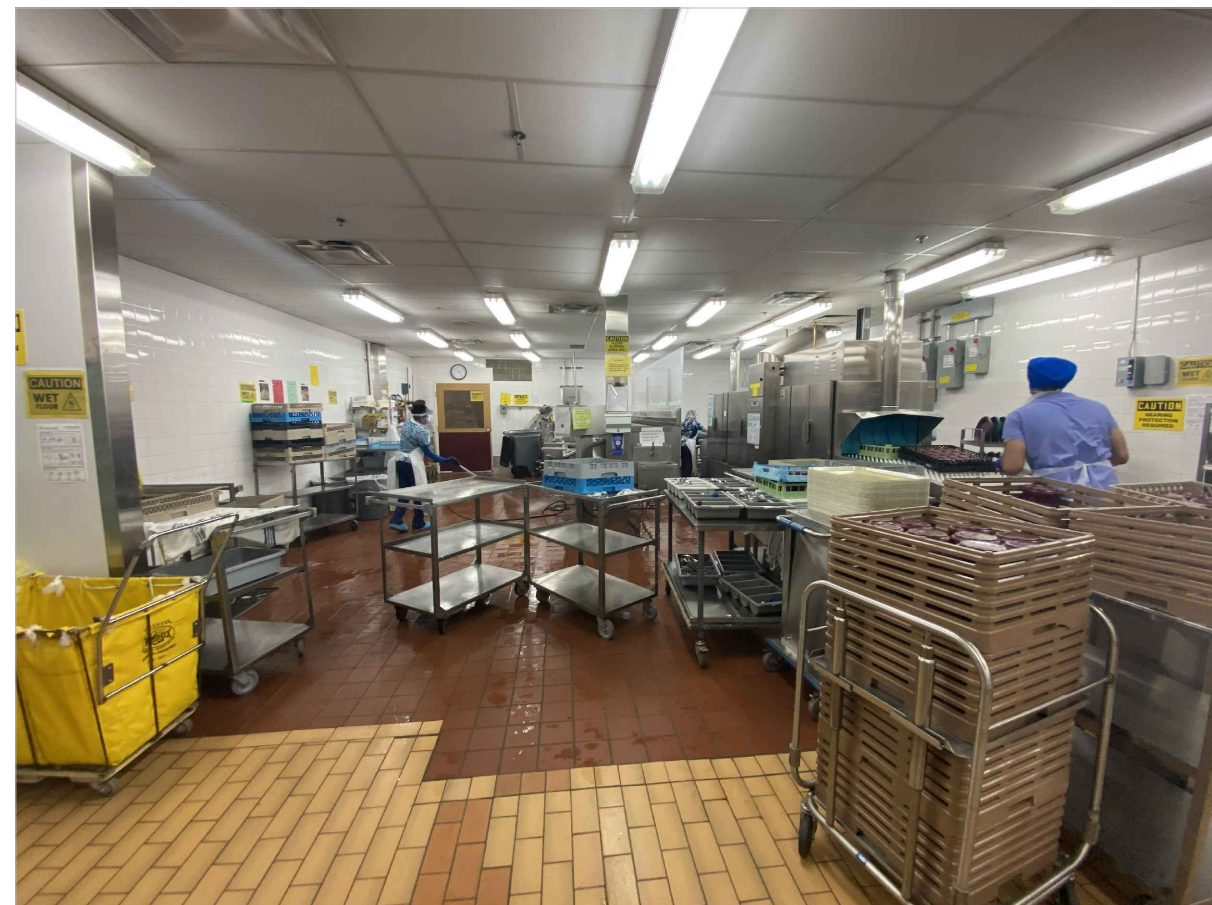

1 PHOTO B
A900



2 PHOTO A
A900




2 PHOTO B
A900




3 PHOTO A
A900





3 PHOTO B
A900

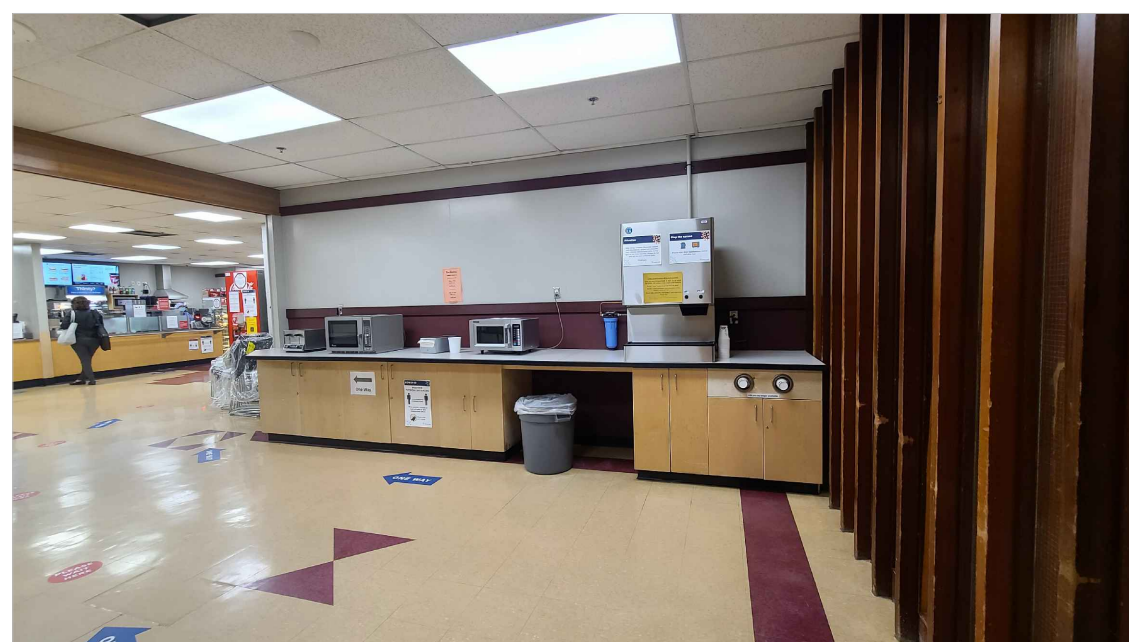

4 PHOTO A
A900

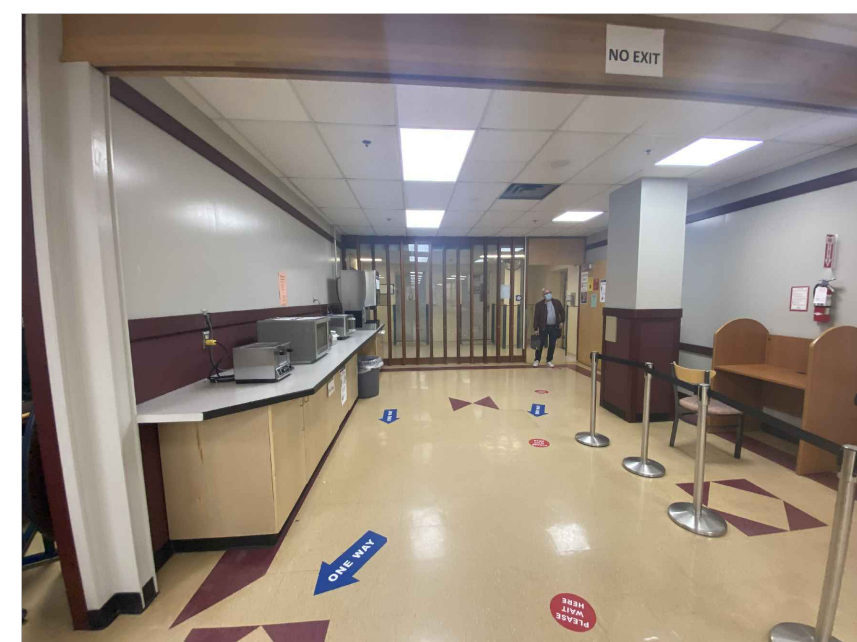

4 PHOTO B
A900

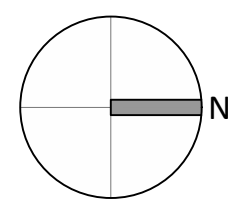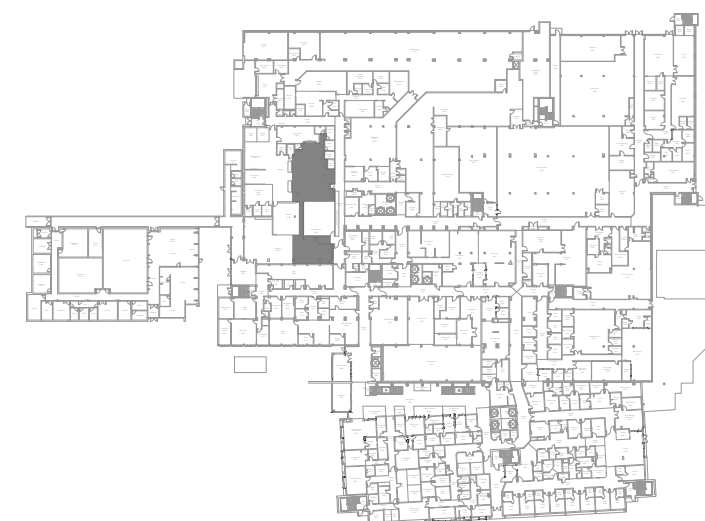

Copyright Reserved

This plan and design are the exclusive property of Thinkspace Architecture. No part of this drawing may be reproduced or transmitted in any form or by any means, electronic or mechanical, including photocopying, recording, or by any information storage and retrieval system, without the prior written consent of Thinkspace. This office shall be informed of any variations from the information shown on this drawing. Do not scale drawings.

Thinkspace a partnership of:
Todd Dust, Architect ABC, AAA
Henk Kampman, Architect ABC, AAA
Ray Wolfe, Architect ABC

CONSTRUCTION GLOBAL REVISIONS LIST*	
NO.	DATE
1	2023-02-08
2	2023-03-01
3	2023-03-09
4	2023-04-11

*Sheet changes clouded and tagged respectively.

thinkspace 50 1963-2023 YEARS

architecture planning interior design ltd.

300 - 10190 152A St. | Surrey, BC | V3R 1J7

t 604.581.8128 | f 604.581.8148 | w thinkspace.ca

NOTE1		NOTE2	
Project	UHN TRAYLINE ASSEMBLY SYSTEM REPLACEMENT	Project	UHN TRAYLINE ASSEMBLY SYSTEM REPLACEMENT
Sheet Number	220937	Sheet Number	220937
Drawing	LEVEL 0 PHOTO REFERENCES	Drawing	LEVEL 0 PHOTO REFERENCES

Plot Date: 2023-02-08